


LUMINAIRE SCHEDULE:

SYMBOL	QTY	CATALOG NUMBER
LP1	3	CTM-3-400-SMH-F 25' POLE 3' BASE Mounting Height = 28 feet. From Pole to Photometric Center = 2 feet. IES Condata File: L5100514.IES Initial Lumens per Lamp = 40000. Light Loss Factor (LLF) = 0.75 Number Poles this type = 3
LP2	5	CTM-3-400-SMH-F 25' POLE 3' BASE Mounting Height = 28 feet. 2 units per pole. From Pole to Photometric Center = 2 feet. IES Condata File: L5100514.IES Initial Lumens per Lamp = 40000. Light Loss Factor (LLF) = 0.75 Number Poles this type = 5

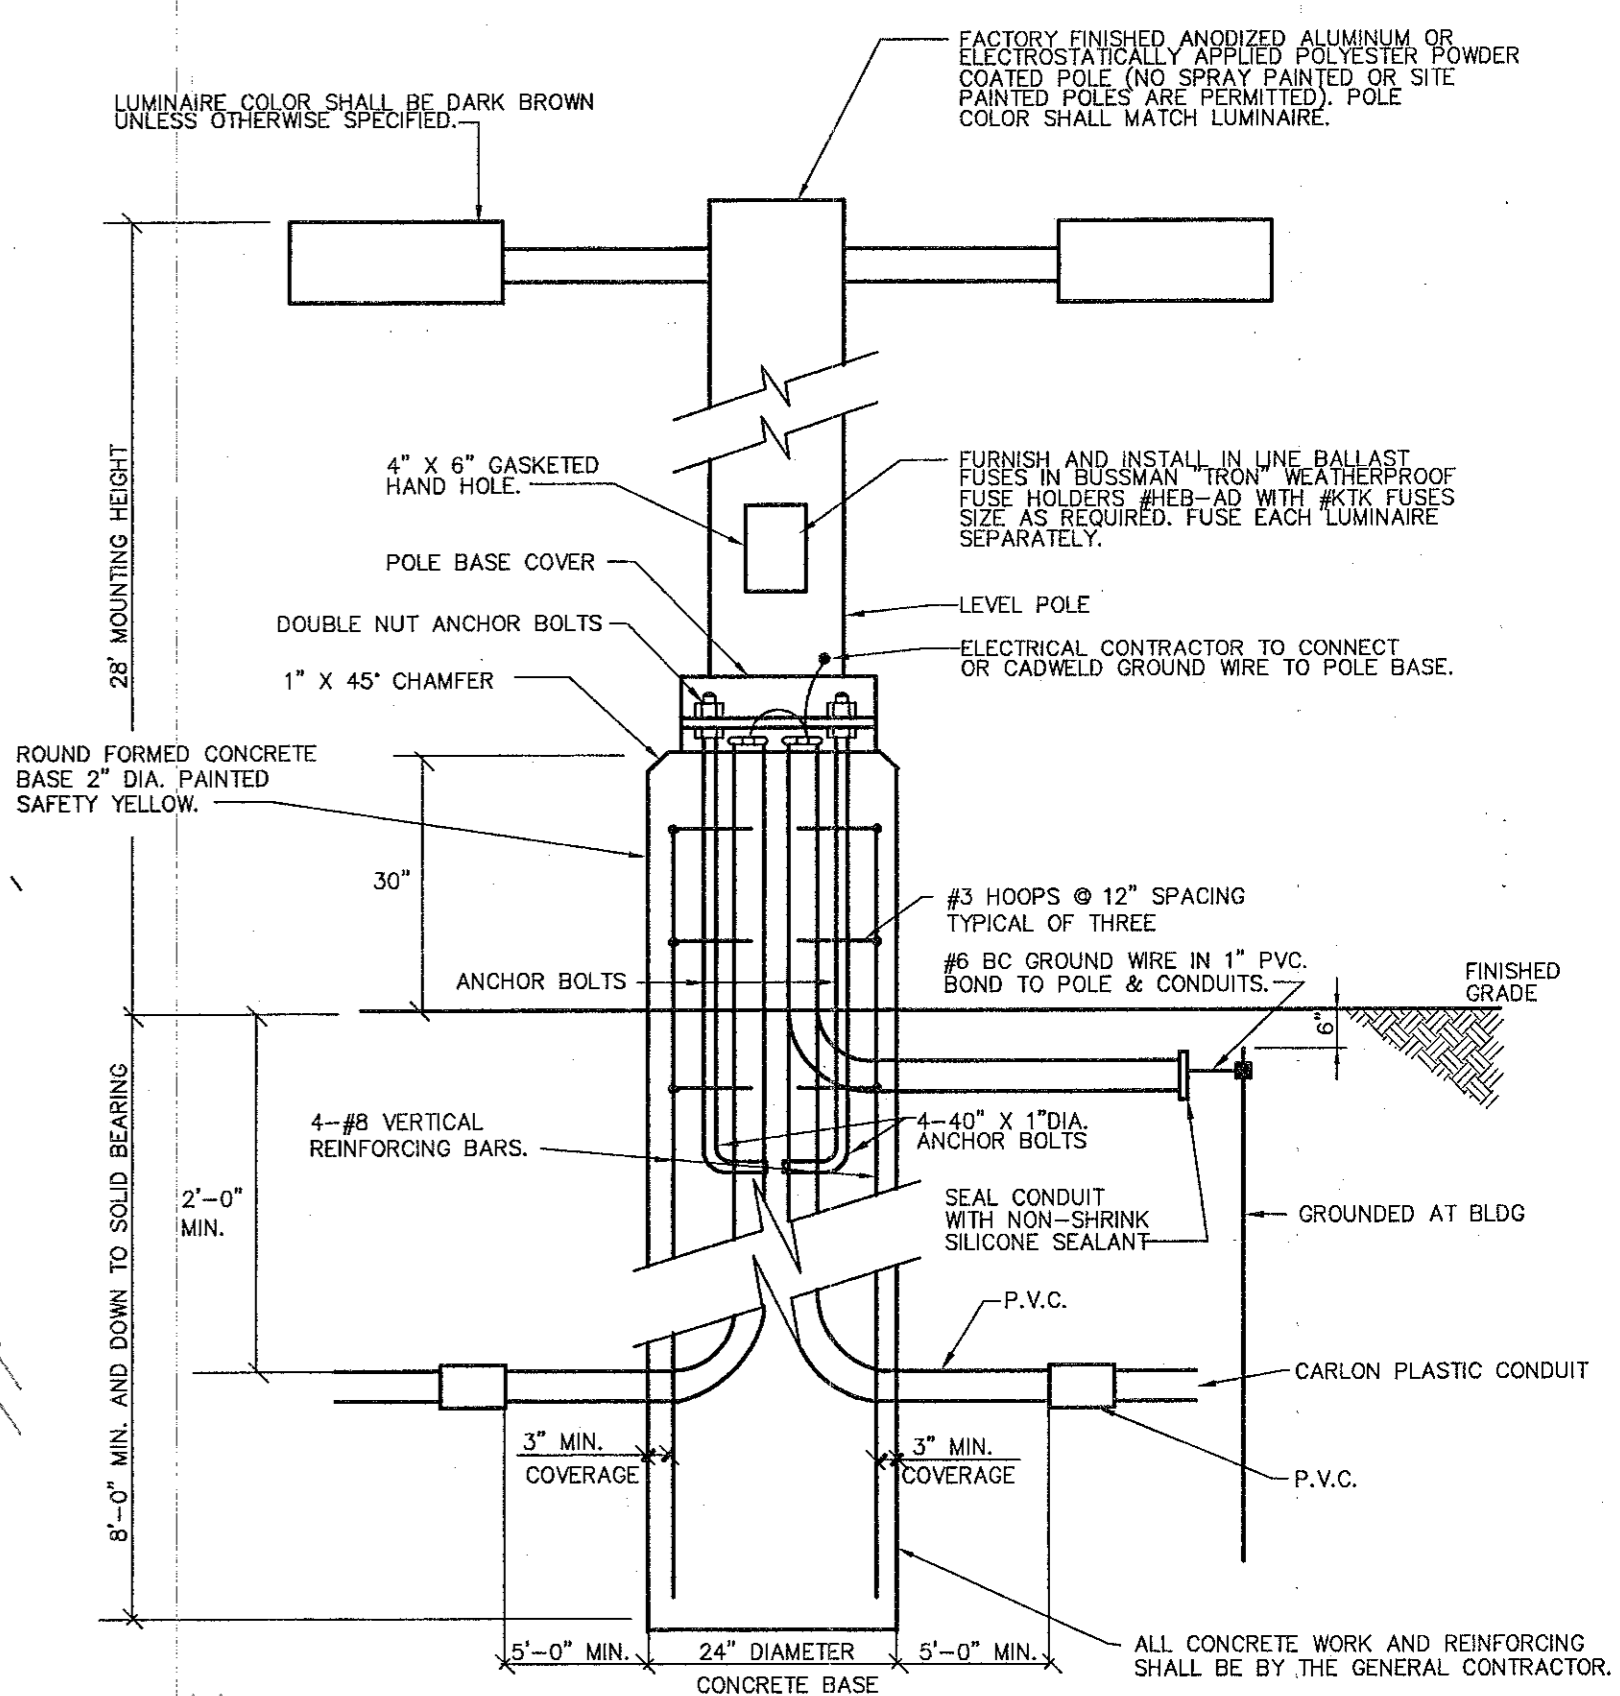

1 SD7

PARKING LOT LIGHTING STANDARD WITH CONCRETE BASE

SCALE: NONE
CROSS REFERENCE:

- NOTES:**
1. READINGS SHOWN ARE MAINTAINED ILLUMINATION AS NOTED.
 2. BASED ON A LIGHT LOSS FACTOR OF 0.72.
 3. RESULTS ARE SHOWN IN UNITS OF FOOTCANDELS.
 4. READINGS SHOWN ARE TAKEN AT GRADE.
 5. LUMINAIRES ARE MOUNTED AS NOTED ON PLAN.

RECORDED
DEC 8 2004
PLANNING BOARD
TOWN OF BETHLEHEM


APPLICANT:
FIRST COLUMBIA L.L.C.
26 Century Hill Drive
Latham, New York 12113
Tel: (518) 213-1000
Fax: (518) 213-1020

TOWN OF BETHLEHEM PLANNING BOARD APPROVAL

PLANNING BOARD
TOWN OF BETHLEHEM
ALBANY COUNTY, NEW YORK

This plat **APPROVED** subject to such conditions as are stated in Building Project Approval (B/P/A)

No. 31, dated 11-10-01
Parker D. Mathison
TITLE CHAIRMAN
Date MAR 30 2005

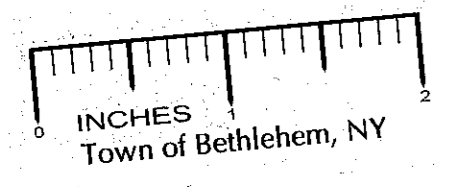

ALL RIGHTS RESERVED. COPY OR REPRODUCTION OF THIS PLAN OR ANY PORTION THEREOF IS PROHIBITED WITHOUT THE WRITTEN PERMISSION OF THE DESIGN ENGINEER, SURVEYOR, OR ARCHITECT.
ALTERATION OF THIS DRAWING, EXCEPT BY A LICENSED P.E. IS ILLEGAL. ANY ALTERATION BY A P.E. MUST BE INDICATED AND BEAR THE APPROPRIATE SEAL, SIGNATURE AND DATE OF ALTERATION.

THE Chazen COMPANIES
Engineers/Surveyors
Planners
Environmental Scientists

CHAZEN ENGINEERING & LAND SURVEYING CO., P.C.

Dutchess County Office: 21 Fox Street, Poughkeepsie, New York 12601
Capital District Office: 20 Quary Avenue, Troy, New York 12182
Orange County Office: 283 Route 17K, Newburgh, New York 12550
North Country Office: 110 Glen Street, Glens Falls, New York 12035

rev.	date	description
8	11/12/04	REVISIONS PER TOWN COMMENTS DATED 11/4/04
9	9/7/04	REVISIONS PER TOWN COMMENTS DATED 8/12/04
7		
6	2/03/03	REVISIONS PER TOWN COMMENTS DATED 1-27-03 & 1-29-03
5	12/20/02	REVISIONS PER TOWN COMMENTS DATED 9-10-02
4	6/28/02	PRE CONSTRUCTION REVISIONS
3	1/04/02	REVISIONS PER TOWN COMMENTS DATED 12-14-01 & 12-21-01
2	11/10/01	REVISIONS PER TOWN COMMENTS DATED 9-12-01
1	8/01/01	REVISIONS PER TOWN COMMENTS DATED 7-19-01

PROPOSED AMENDMENT TO PLANNED COMMERCIAL DISTRICT NO. 6
NEW SCOTLAND ROAD
COMMERCIAL BUSINESS PARK
ILLUMINATION PLAN

TOWN OF BETHLEHEM, ALBANY COUNTY, NEW YORK

drawn JMB checked JML
date 7/8/04 scale AS NOTED
project no. 30124.00
sheet no. SP5