



1 WEST ELEVATION
 1/16" = 1'-0" BUILDING 'B'

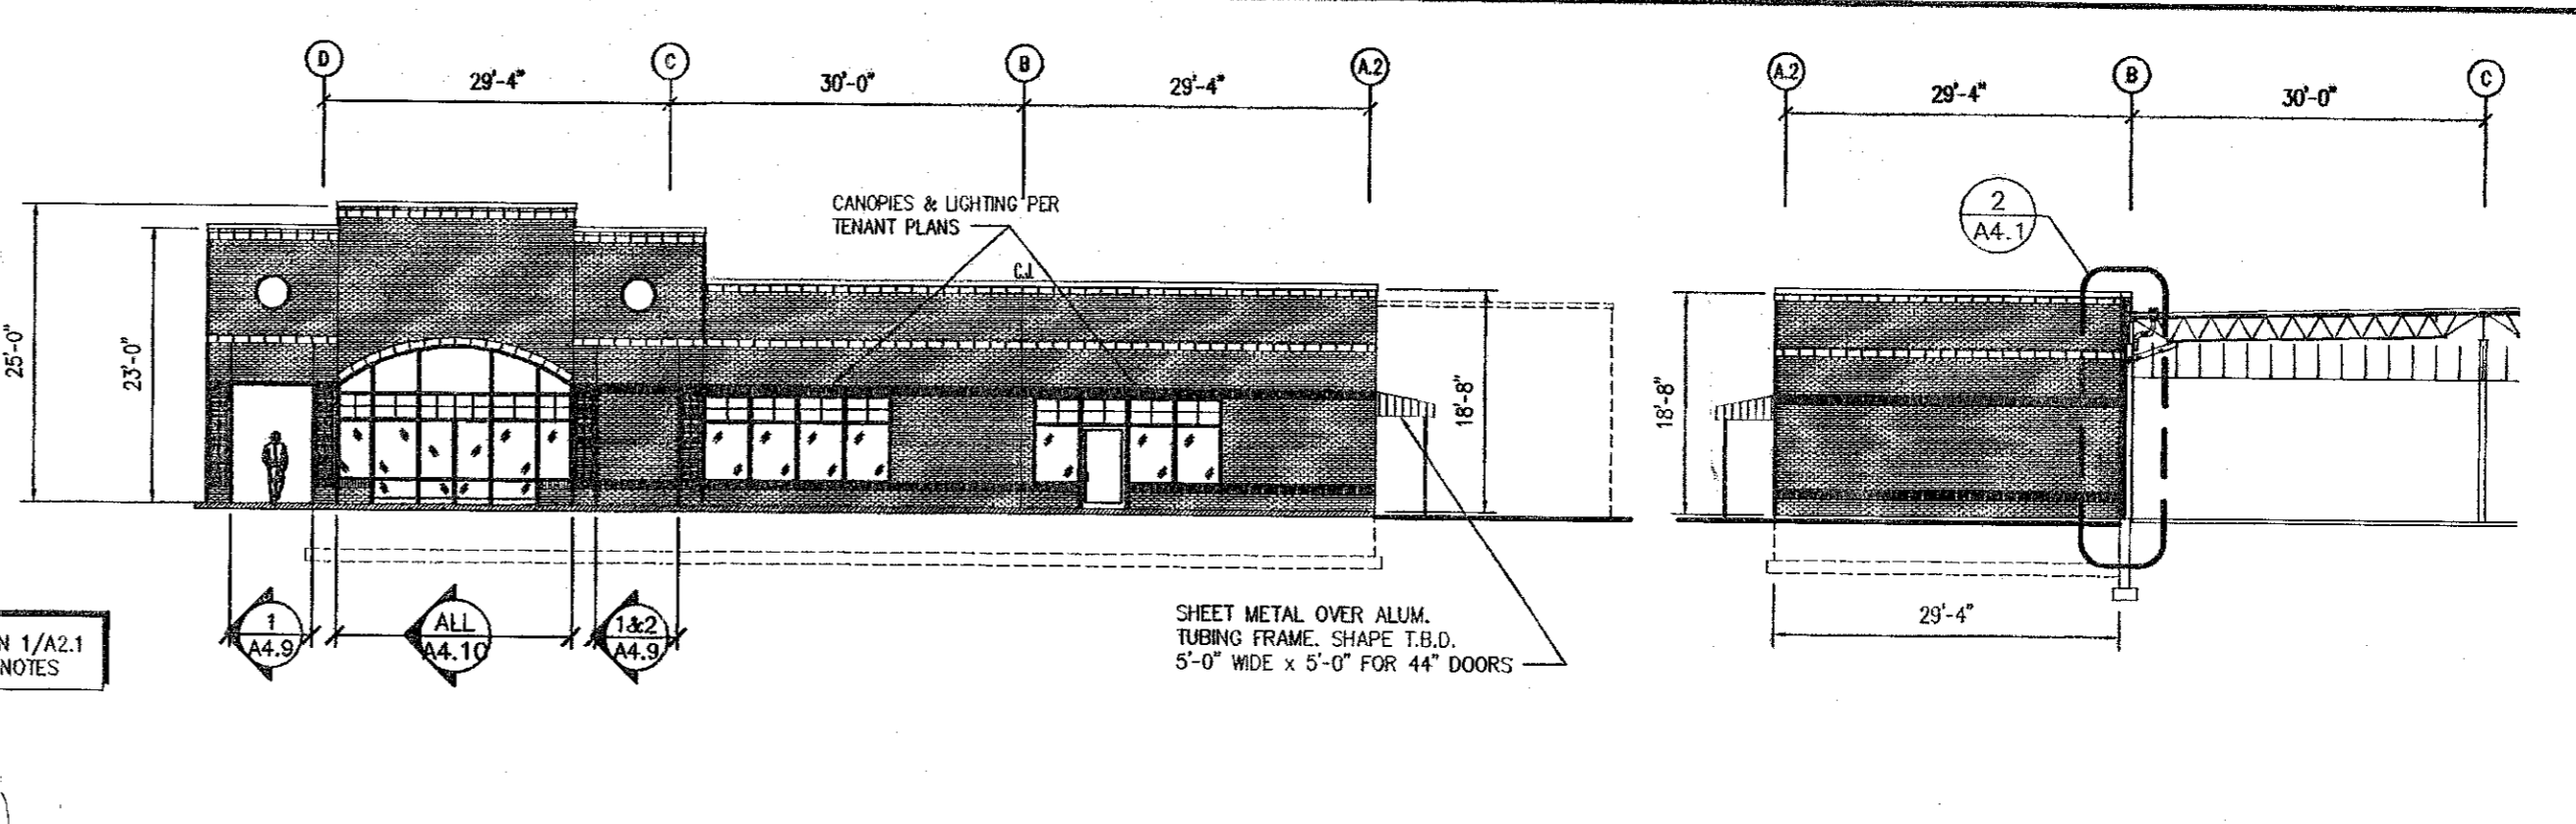


2 WEST ELEVATION
 1/16" = 1'-0" BUILDING 'A'


3 EAST ELEVATION
 1/16" = 1'-0" BUILDING 'A'

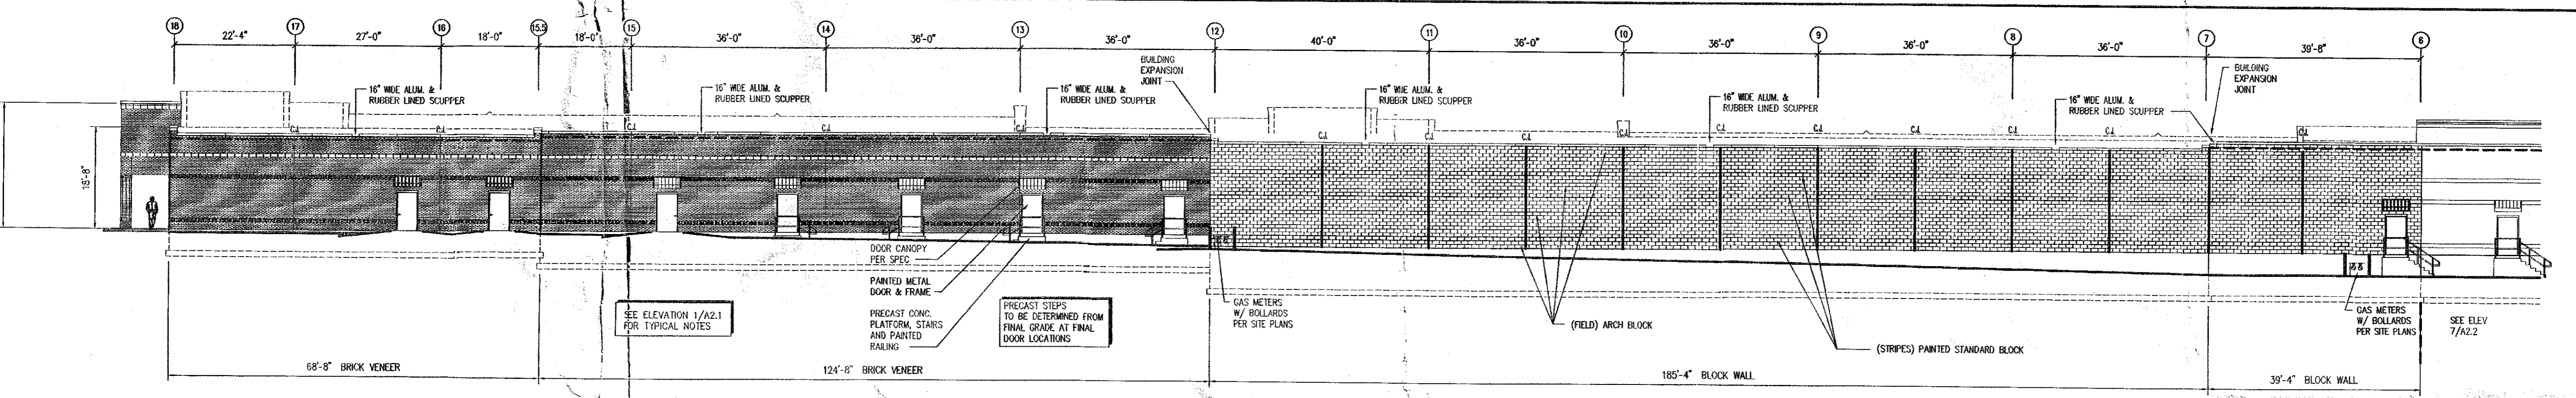


4 NORTH ELEVATION
 1/16" = 1'-0" BUILDING 'A'

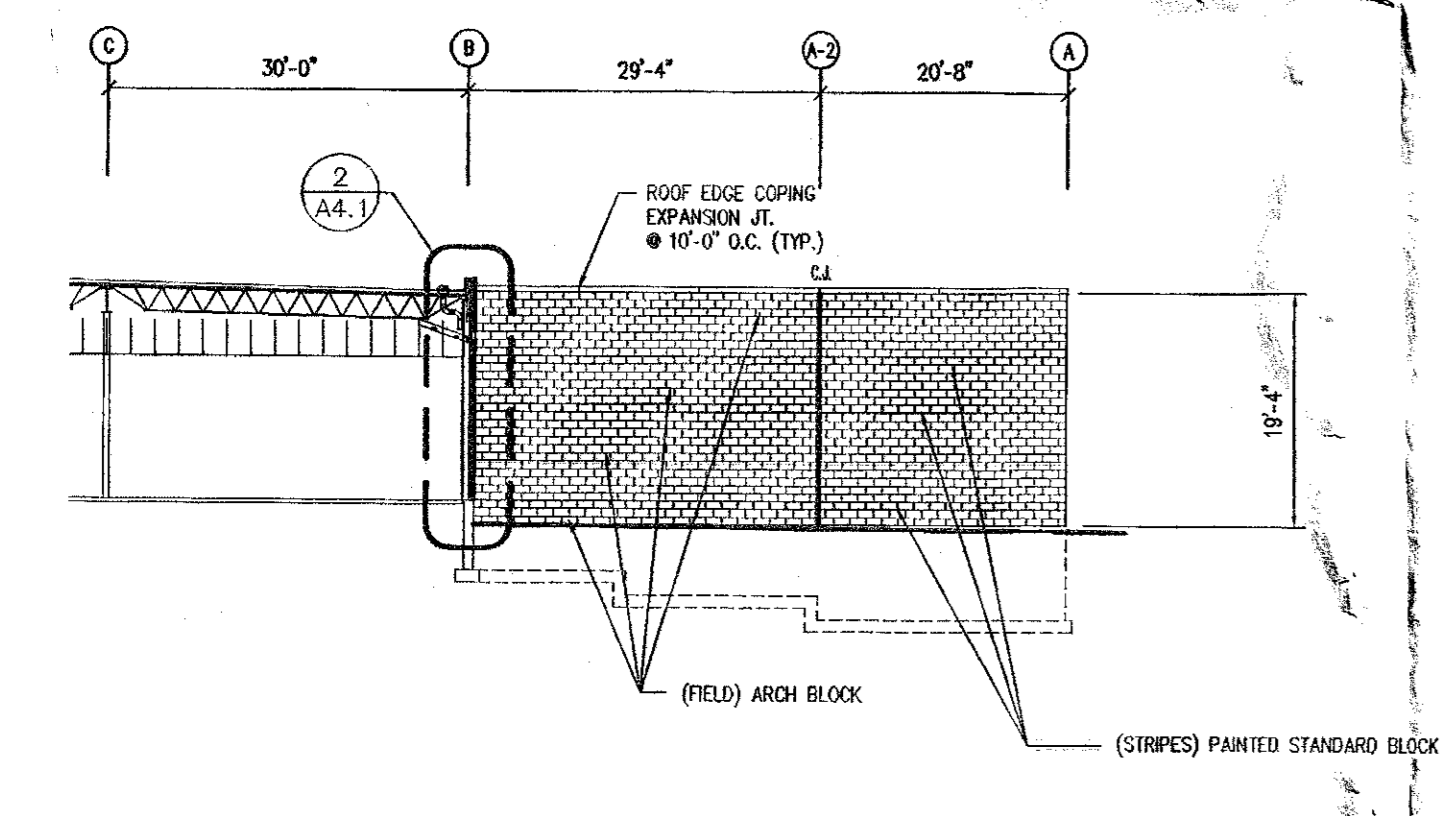


5 WEST ELEVATION
 1/16" = 1'-0" BUILDING 'A'

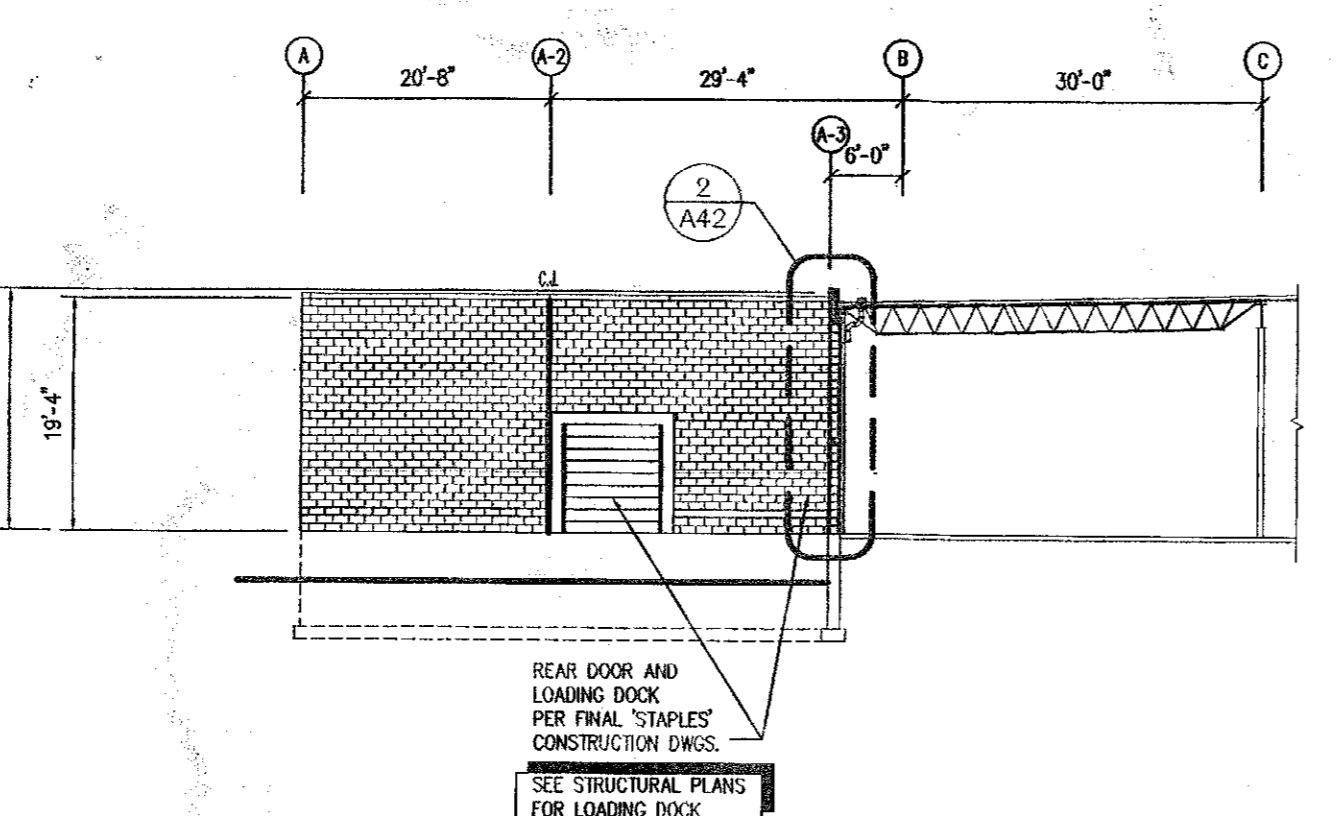

6 EAST ELEVATION
 1/16" = 1'-0" BUILDING 'A'

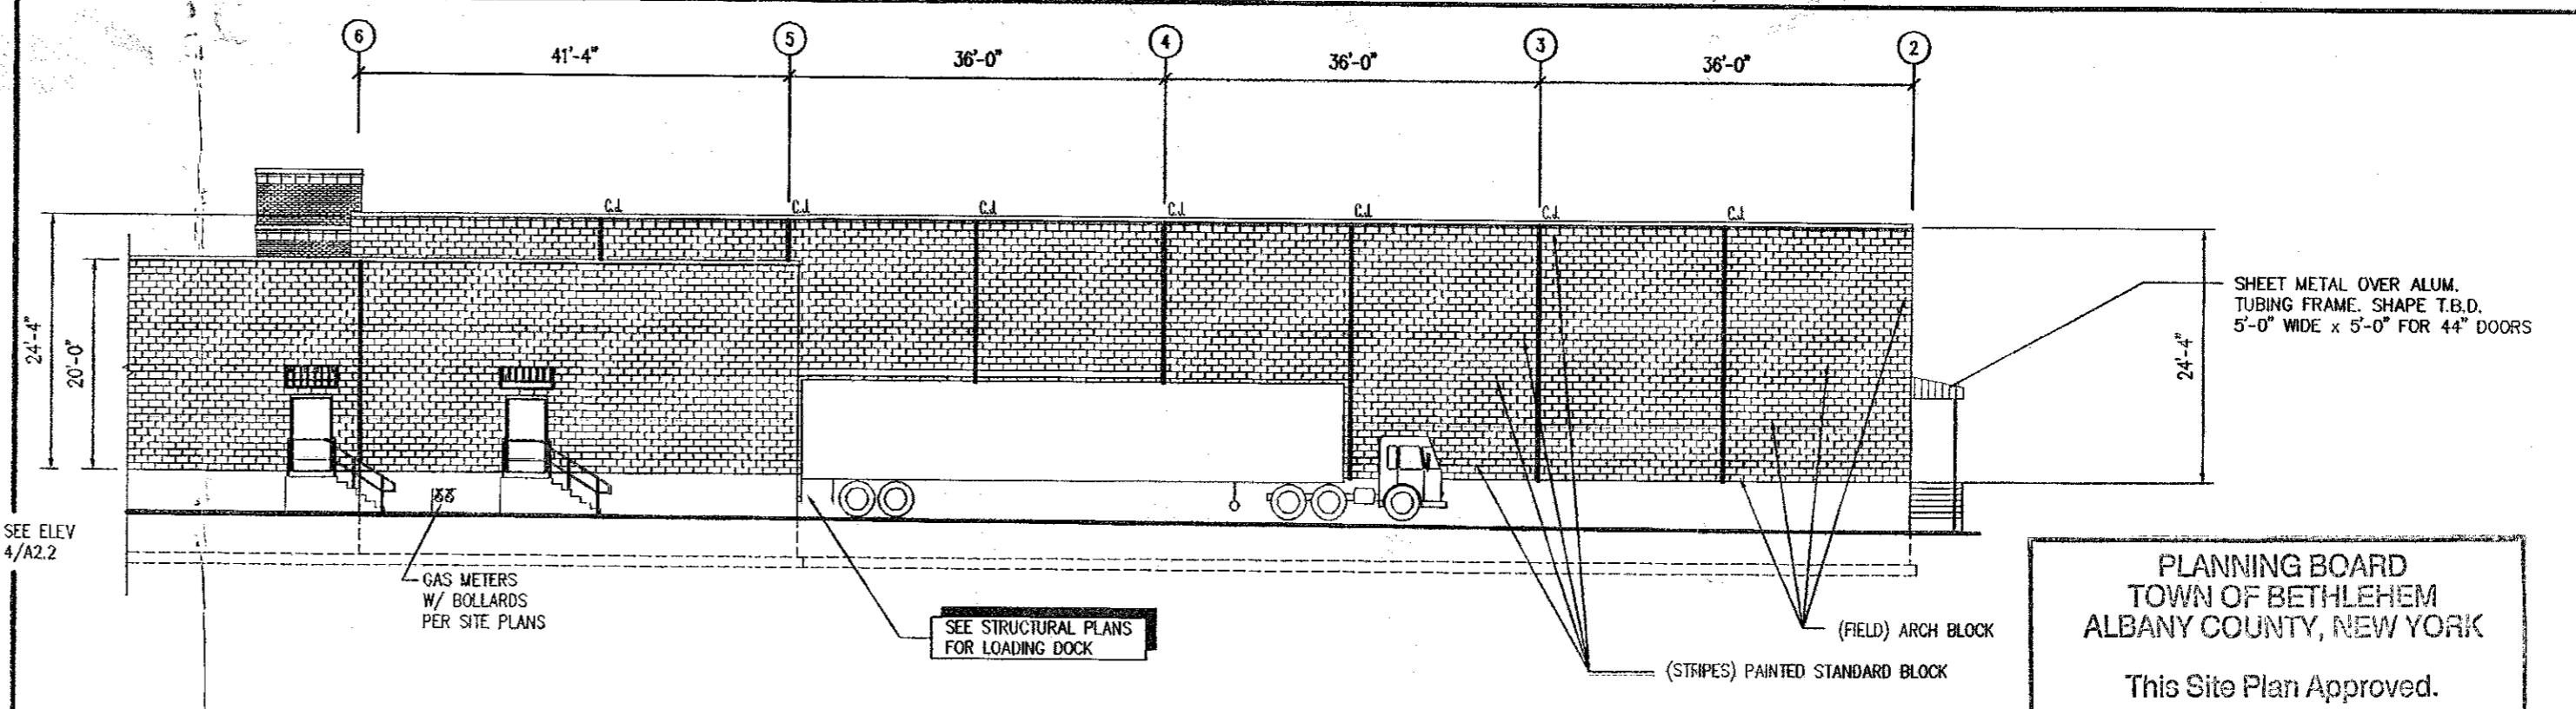


7 NORTH ELEVATION
 1/16" = 1'-0" BUILDING 'B'

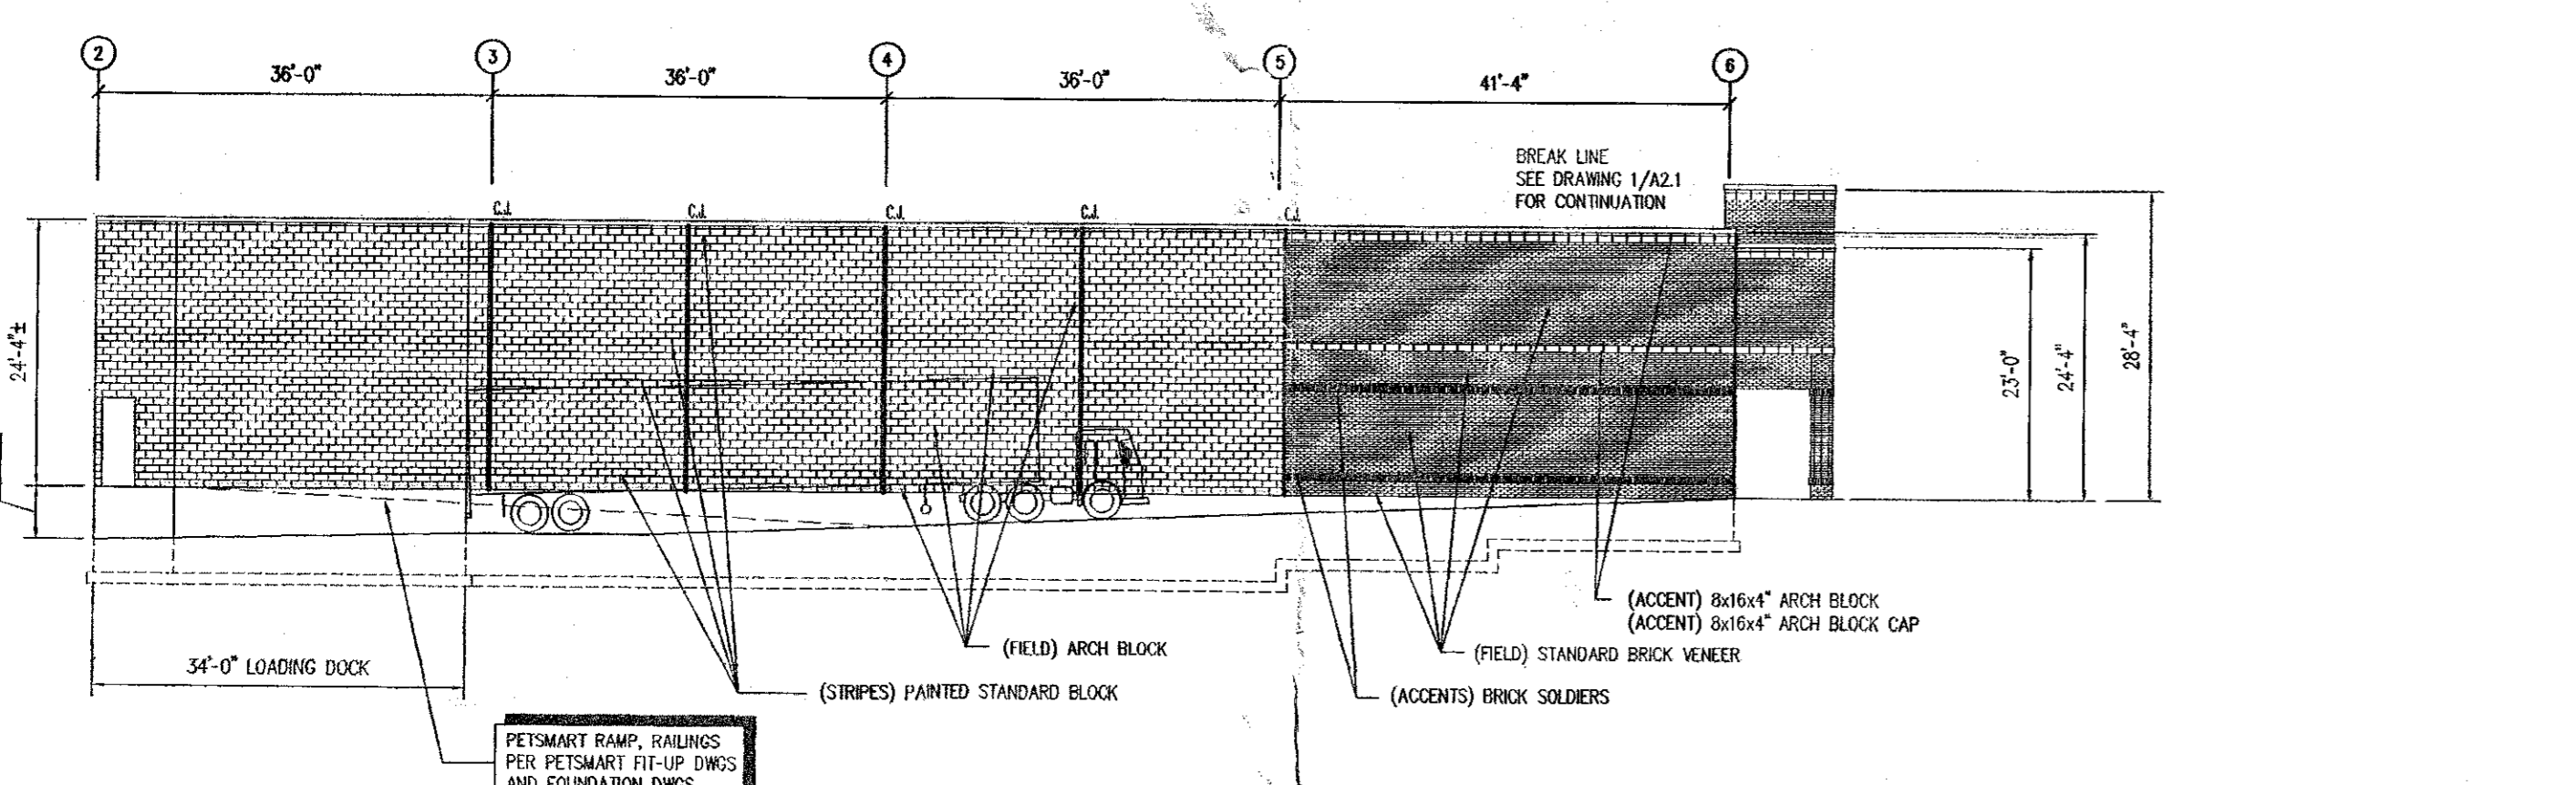


8 SOUTH ELEVATION
 1/16" = 1'-0" BUILDING 'B'

- GENERAL NOTES:**
- REFER TO STRUCTURAL PLANS FOR ALL BOLLARD LOCATIONS
 - REFER TO SITE PLANS FOR LOCATION OF GAS METERS AND ELECTRIC TRANSFORMERS
 - REFER TO SITE PLANS FOR LOCATION OF CURBS, SIDEWALKS AND HANDICAP RAMPS
 - REFER TO SITE PLANS FOR LOCATION OF DUMPSTER ENCLOSURES. CONTRACTOR TO PROVIDE ALL WORK (INC. FENCING, BRICK & BLOCK)
 - REFER TO ELECTRIC PLANS & SPECS FOR LOCATIONS OF ALL EXTERIOR WALL PACKS AND MISC. ELECTRIC
 - REFER TO PLUMBING PLANS AND/OR SPECS FOR LOCATIONS OF ALL EXTERIOR HOSE BIBS AND SPRINKLER CONNECTIONS
 - REFER TO FINAL TENANT LAYOUTS FOR LOCATION OF FRONT & REAR DOORS
 - REFER TO WALL SECTIONS FOR ALL BLOCK WALL PAINTED ACCENT STRIPING. ALL COLORS OF MASONRY BRICK, BLOCK, AND MORTAR PER TOWN APPROVED COLOR SCHEME. ALL ARCHITECTURAL BLOCK TO BE COLORED. ALL SMOOTH BLOCK ACCENTS TO BE PAINTED OR COLORED
 - PROVIDE BLOCK CONTROL JOINT MAX. 20'-0" O.C.
 - PROVIDE BLOCK CONTROL JOINT AT CHANGE OF HEIGHT.
 - PLAN SHOWS CONTROL JOINTS IN BLOCK WALL AT GRID LINES. MASONRY CONTRACTOR TO AVOID CONTROL JOINTS AT GRID LINES.

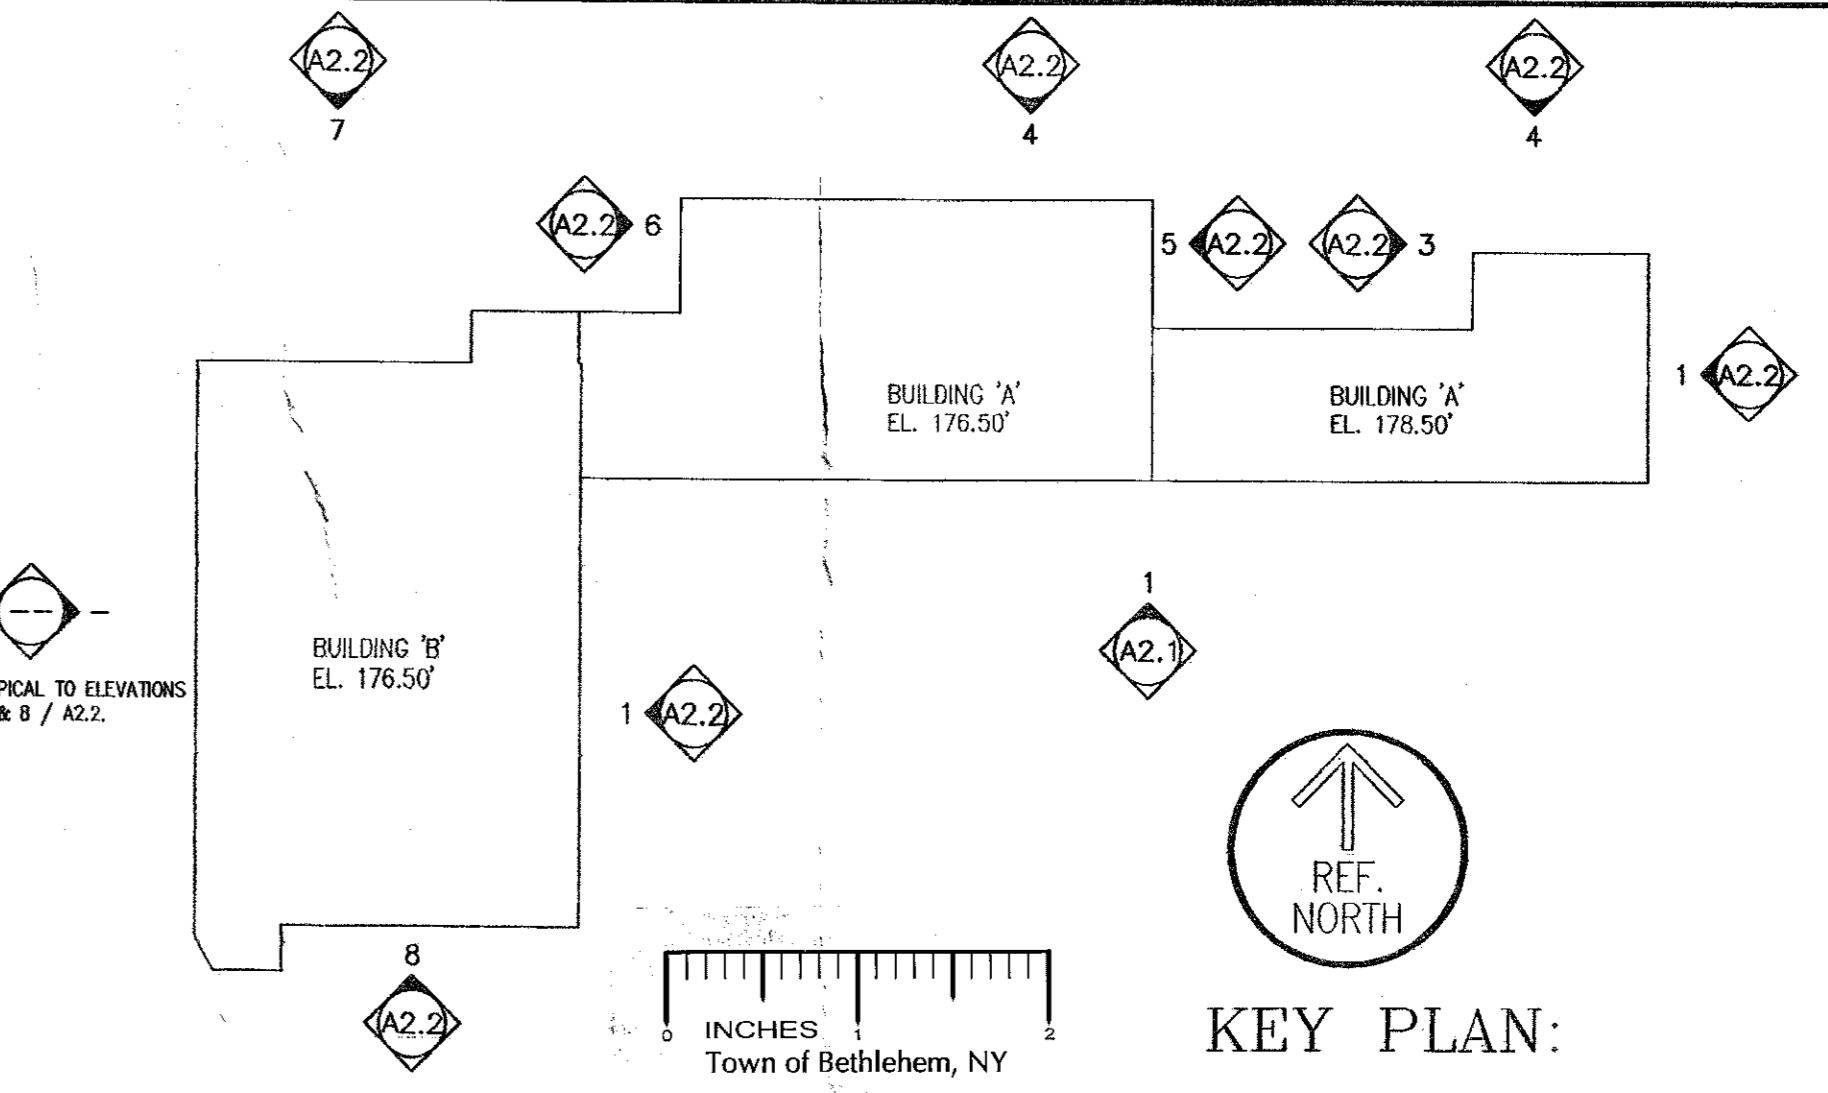

KEY PLAN:

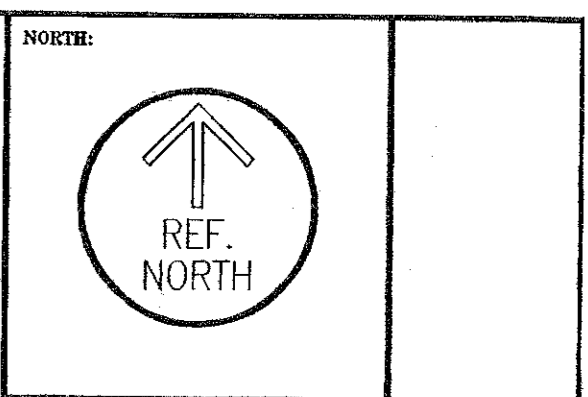

NIGRO COMPANIES
 REAL ESTATE DEVELOPMENT & MGMT.
 20 Corporate Woods Blvd.
 Albany, New York 12211
 Phone: 518/436-8421 Fax: 518/436-8129

BRITISH AMERICAN
 CONSTRUCTION SERVICES L.L.C.
 4 British American Boulevard, LaSalle, NY 12110
 Phone: 518/786-6000 Fax: 518/786-6001
 Website: www.britishamerican.com

To the best of my knowledge, information and belief, the plans and specifications are in accordance with applicable requirements of the New York State Uniform Fire Prevention & Building Code, State Energy Conservation Code, local building codes and requirements, as well as National Plumbing and Electrical Codes.

Unauthorized alteration, addition or duplication to this document is prohibited without the expressed written consent of British American Construction Services L.L.C.

PROGRESS DRAWINGS:
 CONTRACT DRAWINGS:
 CONSTRUCTION DRAWINGS:
 ESTIMATED BY:
 CHECKED BY:

70,440 S.F. RETAIL PLAZA

BETHLEHEM CENTER II
 BUILDING A & B
 241 NYS Route 9W
 BETHLEHEM, NY

PLANNING BOARD
 TOWN OF BETHLEHEM
 ALBANY COUNTY, NEW YORK

This Site Plan Approved.

Paul J. Maloney
 Title: Chairman

Date: 5/17/06

DRAWING: BUILDING ELEVATIONS NOTES & DETAILS BUILDING 'A' & 'B'

SCALE: 1/16" = 1'-0"

DRAWN BY: K.D.S.

DATE: FEBRUARY 15, 2006

REVISIONS:	DATE	BY
PLANS FOR PRICING	K.D.S.	3/9/06
PETSMART ELEVATION REVISED	K.D.S.	3/23/06
REVISED PETSMART ELEVATION PLANS FOR PERM	K.D.S.	4/6/06

STAMP: PROJECT NO. DRAWING NO. A2.2