

PROPOSED ENTRANCE AND PARKING IMPROVEMENTS

**AIR PRODUCTS AND CHEMICALS, INC.
461 RIVER ROAD
GLENMONT, NEW YORK**

URS
URS CORPORATION
3 CORPORATE DRIVE
SUITE 203
CLIFTON PARK, NY 12065
1-(518)-688-0015

PROFESSIONAL SEAL



REVISIONS

PROJECT NO: 38397178

DRAWN BY: A.R.Z.

DESIGNED BY: A.R.Z.

CHECKED BY: M.K.C.

THE INFORMATION CONTAINED IN THIS SET OF DOCUMENTS IS PROPRIETARY BY NATURE. ANY USE OR DISCLOSURE OTHER THAN THAT WHICH RELATES TO THIS PROJECT IS STRICTLY PROHIBITED.

**PROPOSED ENTRANCE AND PARKING IMPROVEMENTS
GLENMONT, N.Y.**

461 RIVER ROAD (ROUTE 144)
GLENMONT, NEW YORK

TITLE SHEET

SCALE: NO SCALE

DATE: 5/22/2013


DRAWING 1 OF 13

T-1



INDEX OF DRAWINGS

SHT. NO.	DESCRIPTION	DWG. NO.
1	TITLE SHEET	T-1
2	SITE PLAN / GENERAL NOTES	SP-1
3	TYPICAL SECTIONS-DRIVEWAY	TS-1
4	TYPICAL SECTION-PARKING LOT	TS-2
5	ROADWAY PROFILE	PR-1
6	GRADING AND UTILITIES PLAN	GR-1
7	WATER METER PLAN	WM-1
8	SIGNING & PAVEMENT MARKING PLAN	PM-1
9	LIGHTING PLAN	L-1
10	EROSION CONTROL NOTES	ECN-1
11	EROSION CONTROL PLAN	ECP-1
12	MISCELLANEOUS DETAILS I	MD-1
13	MISCELLANEOUS DETAILS II	MD-2

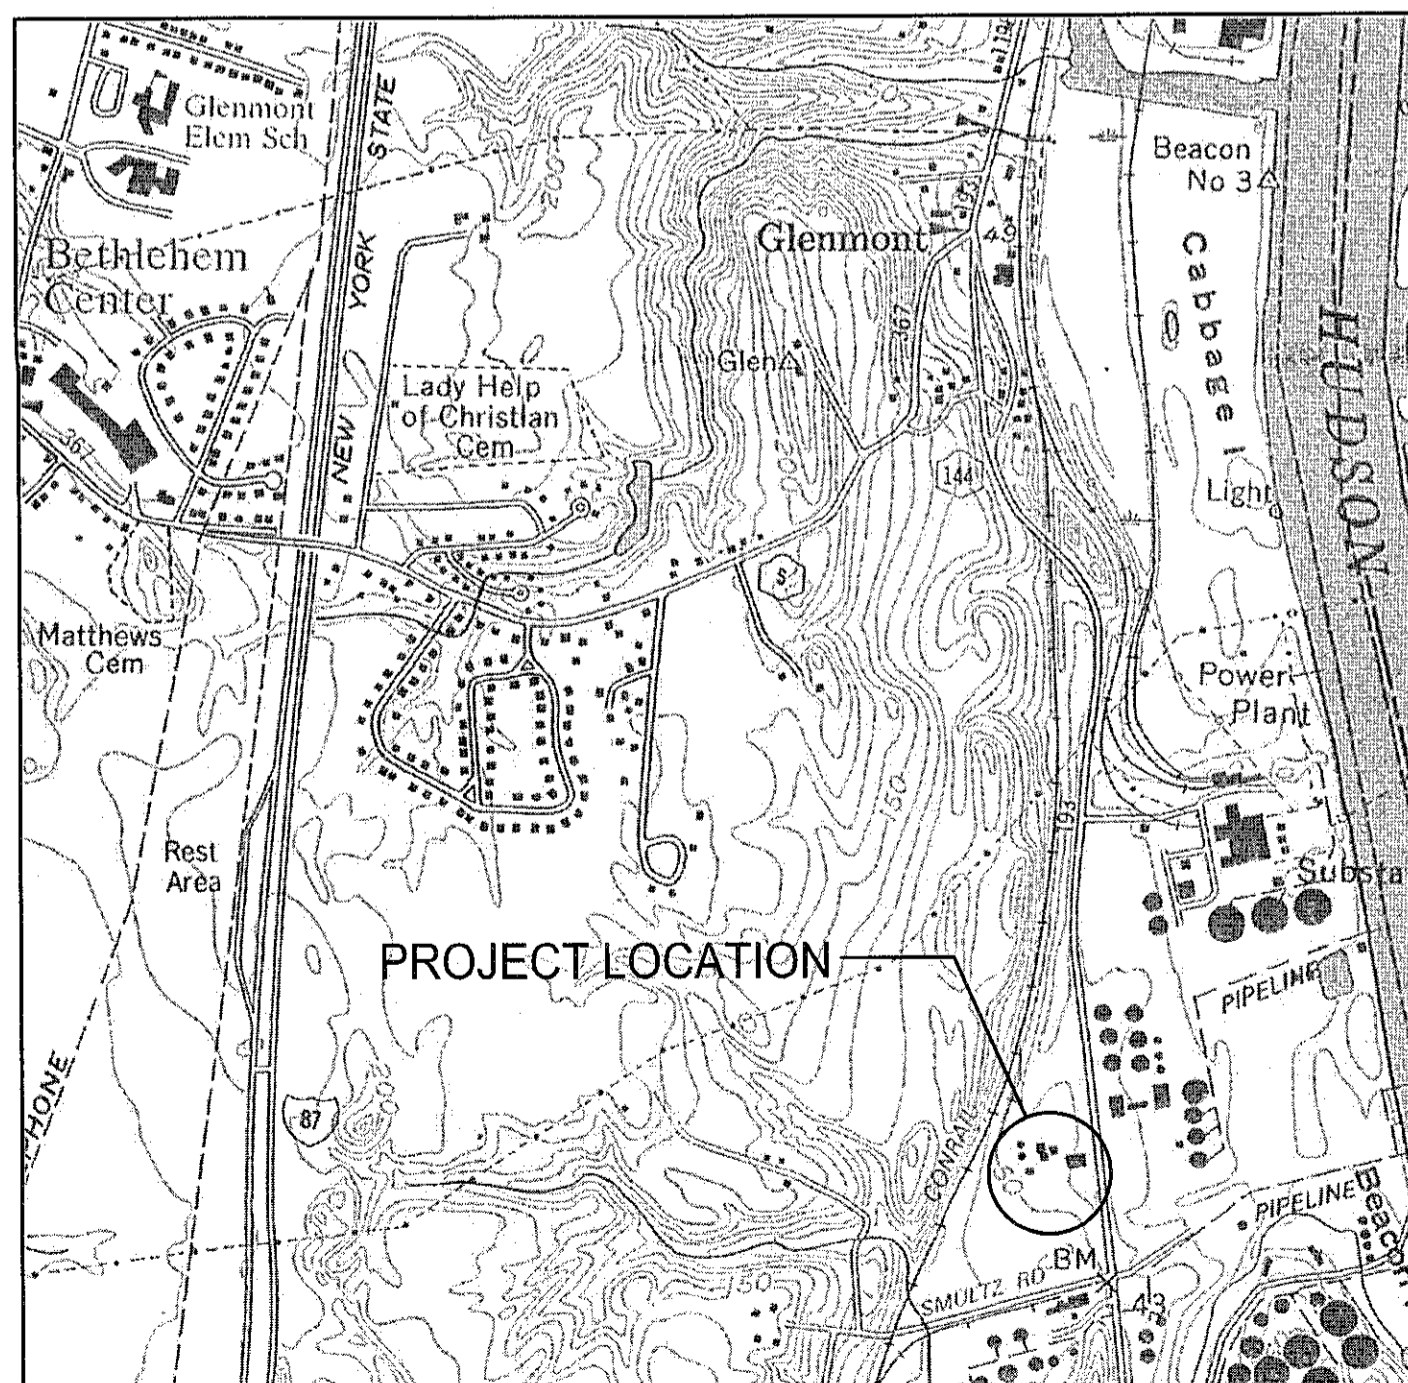

LOCATION MAP
N.T.S.

PREPARED FOR:

AIR PRODUCTS AND CHEMICALS, INC.
7201 HAMILTON BOULEVARD
ALLENTOWN, PA.
18195-1501
USA

Town of Bethlehem Planning Board
By direction of the Chairman
these plans are hereby Approved.
See sheet for date & signature.

2 of 13 (SP-1)

SPA 193

SPA 193

