


FED. ROAD REG. NO.	STATE	FEDERAL AID PROJECT NO.	SHEET NO.	TOTAL SHEETS
1	N.Y.	BRM-5605 (5)	672	113
GLENMONT - FEURA BUSH, S.H. 367				
RTE 32 OVER CONRAIL				
TOWNS OF BETHLEHEM & NEW SCOTLAND, ALBANY COUNTY				

IN CHARGE OF *Robert J. [Signature]* DESIGNED BY *Robert J. [Signature]* CHECKED BY *[Signature]* ESTIMATED BY *[Signature]* DRAFTED BY *[Signature]*

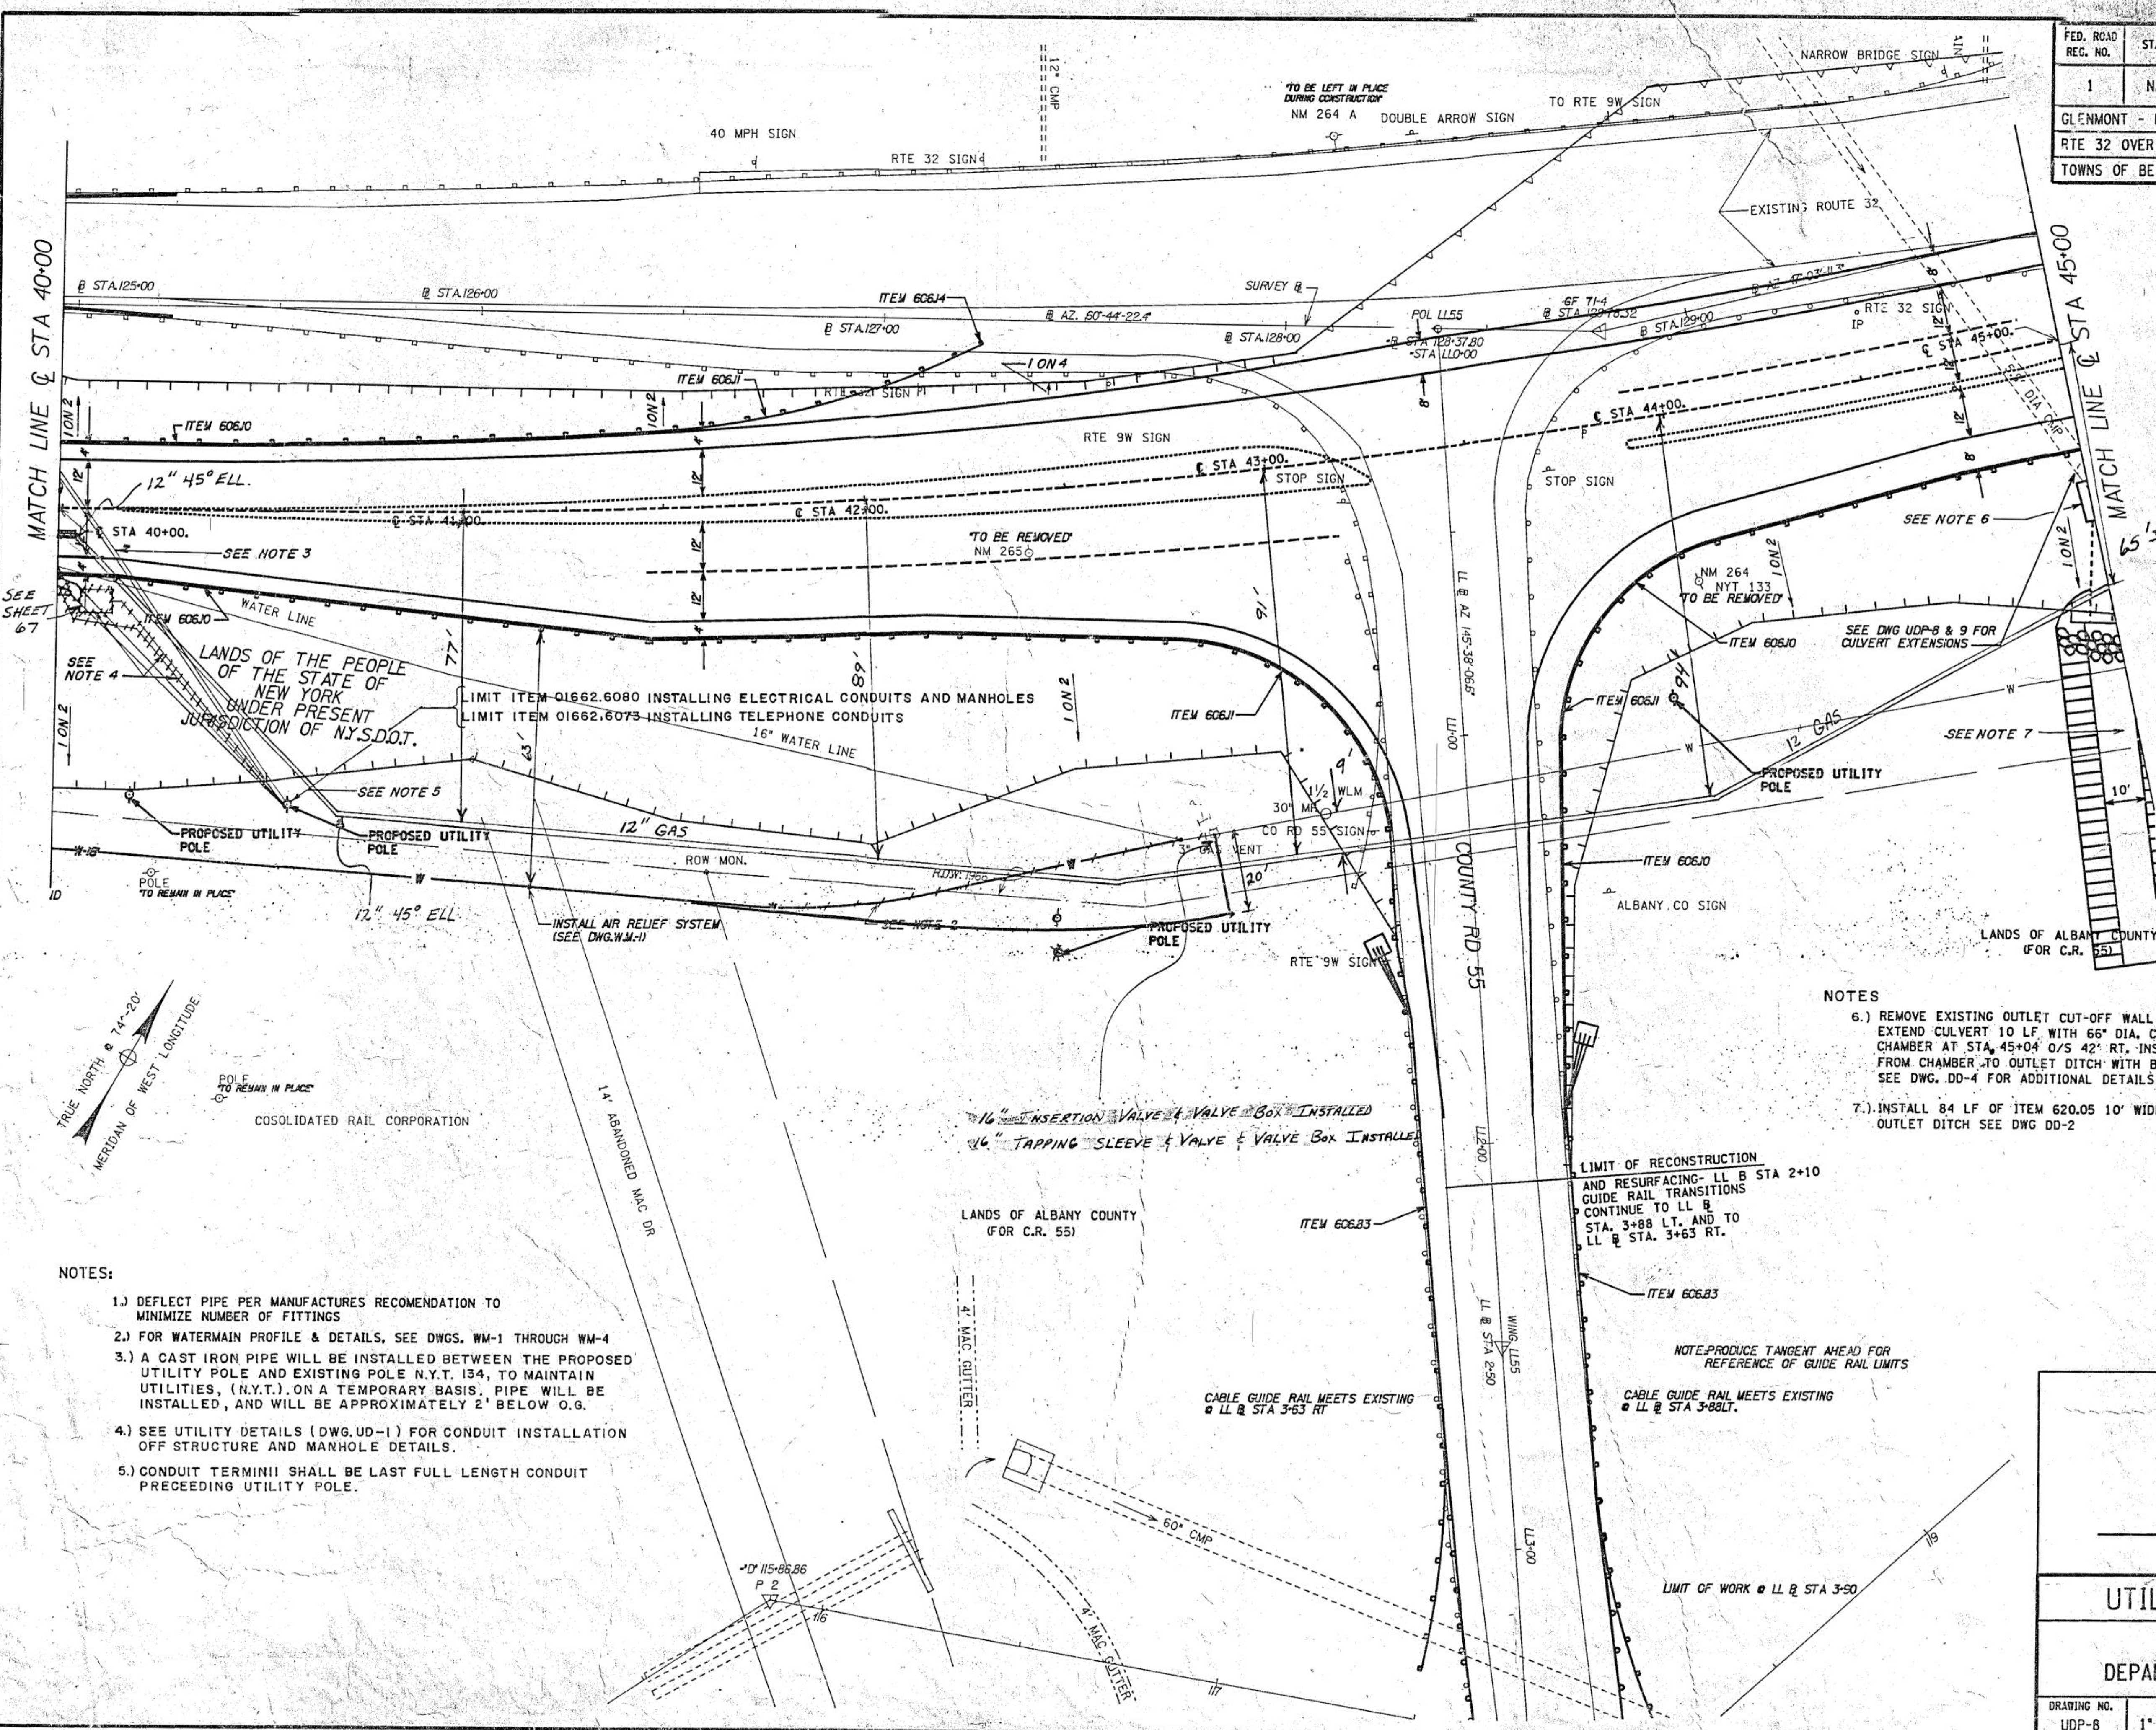

NOTES:

- 1.) DEFLECT PIPE PER MANUFACTURES RECOMENDATION TO MINIMIZE NUMBER OF FITTINGS
- 2.) FOR WATERMAIN PROFILE & DETAILS, SEE DWGS. WM-1 THROUGH WM-4
- 3.) A CAST IRON PIPE WILL BE INSTALLED BETWEEN THE PROPOSED UTILITY POLE AND EXISTING POLE N.Y.T. 134. TO MAINTAIN UTILITIES, (N.Y.T.) ON A TEMPORARY BASIS, PIPE WILL BE INSTALLED, AND WILL BE APPROXIMATELY 2' BELOW O.G.
- 4.) SEE UTILITY DETAILS (DWG. UD-1) FOR CONDUIT INSTALLATION OFF STRUCTURE AND MANHOLE DETAILS.
- 5.) CONDUIT TERMINII SHALL BE LAST FULL LENGTH CONDUIT PRECEEDING UTILITY POLE.

NOTES

- 6.) REMOVE EXISTING OUTLET CUT-OFF WALL AND BEULLED END SECTION. EXTEND CULVERT 10 LF. WITH 66\"/>
- 7.) INSTALL 84 LF OF ITEM 620.05 10' WIDE, 3.5' DEEP & 3' THICK IN. OUTLET DITCH SEE DWG DD-2

AS-BUILT REVISIONS

SIGNATURE _____ DATE _____

UTILITY & DRAINAGE PLAN

STATE OF NEW YORK
DEPARTMENT OF TRANSPORTATION

DRAWING NO.	SCALE	DATE	REGION
UDP-8	1" = 20'	3/89	ONE