

KEYED DEMOLITION NOTES

A4 FLOOR DEMO NOTES

- (A1) REMOVE ALL INTERIOR WALL FINISHES, WALL MOUNTED ACCESSORIES, STUD FRAMING, WD FURRINS, INSULATION & ALL RELATED ATTACHMENTS DOWN TO EXISTING EXTERIOR MASONRY WALL CONSTRUCTION.
- (A2) REMOVE INTERIOR STUD PARTITION, WALL, MTD ACCESSORIES & ALL RELATED ATTACHMENTS.
- (A3) REMOVE DOOR, FRAME & ALL RELATED ACCESSORIES.
- (A4) REMOVE POS MILLWORK, BASE CABINETS, SWING GATE, SHELVING, COUNTERTOPS, WOOD PLATFORM & ALL RELATED ACCESSORIES.
- (A5) REMOVE WALK-IN COOLER DISPLAY DOOR UNITS & RELATED ATTACHMENTS.
- (A6) REMOVE ENTIRE WALK-IN COOLER, CEILING PANELS, ACCESS DOOR, LIGHT FIXTURES, EVAP FAN UNITS, ELEC WIRING & ALL RELATED ATTACHMENTS.
- (A7) REMOVE PLUMBING FIXTURES & RELATED ACCESSORIES, CUT & CAP PIPING AS REQ'D TO ACCOMMODATE NEW LAYOUT.
- (A8) REMOVE WATER FILTRATION SYSTEM & RELATED ATTACHMENTS, SALVAGE FOR RELOCATION IN NEW LAYOUT, CUT & CAP PIPING AS REQ'D TO ACCOMMODATE NEW LAYOUT. (SEE PLUMB DWGS)
- (A9) REMOVE WATER HEATER, WOOD SHELVING & ALL RELATED ATTACHMENTS, CUT & CAP PIPING AS REQ'D.
- (A10) REMOVE MILLWORK COUNTER, BASE CABINETS, COUNTER & ALL RELATED ATTACHMENTS.
- (A11) REMOVE WALL MOUNTED SHELVING & ALL RELATED ATTACHMENTS.
- (A12) REMOVE FIRE EXTINGUISHER & RELATED ATTACHMENTS.
- (A13) REMOVE VEEDER ROOT & RELATED ATTACHMENTS, SALVAGE FOR RELOCATION. (SEE ELEC DWGS).

- (A14) REMOVE ELEC PANELS, ELEC CONDUITS, ACCESSORIES & ALL RELATED ATTACHMENTS.
- (A15) REMOVE T5-B0 & RELATED ATTACHMENTS, SALVAGE & RETURN TO OWNER.
- (A16) REMOVE POWER POLE, ELEC WIRING & RELATED ATTACHMENTS.
- (A17) REMOVE E-STOP BUTTON & RELATED ATTACHMENTS, SALVAGE FOR RELOCATION. (SEE ELEC DWGS).
- (A18) REMOVE FIRE ALARM PULL STATION & RELATED ATTACHMENTS, SALVAGE FOR RELOCATION. (SEE ELEC DWGS).
- (A19) REMOVE FIRE SUPPRESSION BOTTLE & RELATED ATTACHMENTS.
- (A20) REMOVE WAYNE DISTRIBUTION BOX & RELATED ATTACHMENTS.
- (A21) REMOVE ELEC METER, CONDUIT & ALL RELATED ATTACHMENTS.
- (A22) REMOVE ENTIRE VGT FLOOR FINISH, VINYL WALL BASE & ALL RELATED ATTACHMENTS.
- (A23) REMOVE ENTIRE CARPET FLOOR FINISH, VINYL WALL BASE & ALL RELATED ATTACHMENTS.
- (A24) REMOVE ENTIRE CERAMIC TILE FLOOR FINISH, VINYL WALL BASE & ALL RELATED ATTACHMENTS.
- (A25) SAWCUT & REMOVE FLOOR SLAB AS REQUIRED TO ACCOMMODATE NEW PLUMBING & ELECTRICAL.
- (A26) REMOVE ENTIRE ALUMINUM STOREFRONT SYSTEM, ENTRY DOOR, ALL RELATED ATTACHMENTS.
- (A27) SAWCUT & REMOVE PORTION OF MASONRY KNEEWALL CONSTRUCTION.
- (A28) SAWCUT & REMOVE PORTION OF EXTERIOR MASONRY WALL CONSTRUCTION, SC TO PROVIDE TEMPORARY SUPPORT FOR EXISTING STRUCTURE AS REQ'D.

- (A29) REMOVE STEEL COLUMN, BASE PLATE & RELATED ATTACHMENTS, PROVIDE SUPPORT FOR ETR STEEL BEAM AS REQ'D.
- (A30) SAWCUT & REMOVE PORTION OF EXISTING CONCRETE FLOOR SLAB & FOUNDATION WALL (1'-0" BELOW SLAB) IN PREPARATION FOR NEW STEEL COLUMN BASE PLATE/FOOTING.
- (A31) REMOVE MASONRY DEMISING WALL & RELATED ATTACHMENTS, PROVIDE SUPPORT FOR ETR STRUCTURE ABOVE AS REQ'D.
- (A32) REMOVE CO2 TANK & RELATED ATTACHMENTS, SALVAGE FOR RELOCATION.
- (A33) REMOVE GAS METER, GAS PIPING & RELATED ATTACHMENTS.
- (A34) SAWTOOTH REMOVE PORTION OF MASONRY WALL CONSTRUCTION @ LOCATION OF NEW DOOR OPENING.
- (A35) REMOVE STEEL BEAM & RELATED ATTACHMENTS, PROVIDE TEMPORARY SUPPORT AS REQ'D FOR ETR STRUCTURE DURING CONSTRUCTION.
- (A36) REMOVE CF GAS METER & RELATED ATTACHMENTS, SALVAGE FOR REUSE, COORDINATE W/ UTILITY COMPANY.
- (A37) REMOVE PORTION OF CONCRETE FOUNDATION WALL DOWN 12" BELOW FLOOR SLAB ELEVATION.

B1 CEILING DEMO NOTES

- (B1) REMOVE ENTIRE ACT CEILING SYSTEM, CEILING MOUNTED ACCESSORIES, SURVEILLANCE CAMERAS, CCTV MONITORS, ETR VALANCE, FLUORESCENT LIGHT FIXTURES, TRACK LIGHTING & ALL RELATED ATTACHMENTS.
- (B2) REMOVE CEILING MOUNTED SUPPLY/RETURN DIFFUSERS, HVAC DUCTWORK & RELATED ATTACHMENTS.
- (B3) REMOVE ENTIRE ACT CEILING SYSTEM, CEILING MOUNTED ACCESSORIES, LIGHT FIXTURES & ALL RELATED ATTACHMENTS.

C8 CEILING DEMO NOTES


- (C8) REMOVE EXTERIOR WOOD SOFFIT PANELS, LIGHT FIXTURES & ALL RELATED ATTACHMENTS, REMOVE BLOCKING/FURRING AS REQ'D FOR NEW WORK.
- (C9) REMOVE GYP BD ENCLOSURE & RELATED ATTACHMENTS.
- (C10) REMOVE VERTICAL STEEL ANGLE & CUT BACK HORIZONTAL STEEL ANGLE SOFFIT FRAMING AS REQ'D, PROVIDE SUPPORT FOR ETR STRUCTURE DURING DEMOLITION/CONSTRUCTION.
- (C11) REMOVE EXISTING STORE ID SIGNAGE, MOUNTING HARDWARE & RELATED ATTACHMENTS.
- (C12) REMOVE VINYL GRAPHIC FROM ETR MTL FASCIA, CLEAN & REPAIR SURFACE IN PREPARATION FOR NEW GRAPHICS.
- (C13) REMOVE DAMAGED TOP COURSE OF BRICK VENEER KNEEWALL & REMOVED STOREFRONT SYSTEM AS REQ'D. (TYP)
- (C14) SAWTOOTH REMOVE BRICK VENEER.
- (C15) REMOVE H.C. ACCESS RAMP, CONC (OR ASPHALT) SIDEWALK & RELATED ATTACHMENTS.
- (C16) REMOVE AIR STATION, ELEC CONDUIT & RELATED ATTACHMENTS, SALVAGE FOR RELOCATION AS DIRECTED BY OWNER.
- (C17) REMOVE PLYWOOD SHEATHING, FASTENERS & RELATED ATTACHMENTS.
- (C18) REMOVE ELECTRICAL STUB-UP & RELATED ATTACHMENTS.
- (C19) REMOVE WALL CAP, DUCT & RELATED ATTACHMENTS.
- (C20) REMOVE CONDENSATE PIPE & RELATED ATTACHMENTS.
- (C21) REMOVE FASCIA BOARD, METAL ROOF EDGE COPING & RELATED ATTACHMENTS.

C18 EXTERIOR DEMO NOTES


- (C12) REMOVE WALL MOUNTED LIGHT FIXTURE & RELATED ATTACHMENTS.
- (C15) SAWTOOTH REMOVE CMU.
- (C16) REMOVE PORTION OF METAL FASCIA TRIM, FASCIA FREEZE PANEL & RELATED ATTACHMENTS AS REQ'D @ LOCATION OF NEW STORE MONUMENT SIGNAGE, COORDINATE LOCATION WITH NEW EXTERIOR ELEVATIONS.
- (C18) REMOVE METAL LOUVER EXHAUST VENT, DUCT & ALL RELATED ATTACHMENTS.
- (C19) REMOVE WALL, MTD TANK STICK & RELATED ATTACHMENTS, SALVAGE FOR REINSTALLATION.
- (C21) REMOVE WALL MOUNTED ELEC EQUIPMENT, WIRING, CONDUIT & ALL RELATED ATTACHMENTS.
- (D1) ROOF DEMO NOTES
- (D1) REMOVE RTU, ROOF CURB & ALL RELATED ATTACHMENTS.
- (D2) REMOVE GAS PIPING & RELATED ATTACHMENTS BACK TO GAS METER.
- (D3) REMOVE CONDENSING UNIT, ELEC WIRING, REFRIGERATION PIPING & ALL RELATED ATTACHMENTS.
- (D4) REMOVE SATELLITE DISH & RELATED ATTACHMENTS.
- (D5) REMOVE ROOF MEMBRANE, RIGID INSULATION & RELATED ATTACHMENTS DOWN TO ETR MTL DECK.
- (D6) REMOVE EXHAUST FAN ROOF CAP, DUCT & RELATED ATTACHMENTS.
- (D7) REMOVE ABANDONED RTU, ROOF CURB & RELATED ATTACHMENTS.
- (D8) REMOVE VENT PIPE & RELATED ATTACHMENTS.
- (D9) REMOVE MASONRY WALL BELOW ROOF LINE.
- (D10) CUT BACK & REMOVE PORTION OF MTL ROOF DECK & RELATED ATTACHMENTS BACK TO NEAREST ETR STEEL JOIST. (SEE 3/D4.2 FOR DEMOLITION SECTION).
- (D11) REMOVE EXIST. MTL ROOF EDGE IN ITS ENTIRETY - PREPARE SURFACE FOR ACCEPTANCE OF NEW MEMBRANE & ROOF EDGE.

LEGEND

- ===== CONSTRUCTION TO REMAIN
- CONSTRUCTION TO BE REMOVED
- (X) INDICATES KEYED DEMOLITION NOTE
- ETR' EXISTING TO REMAIN

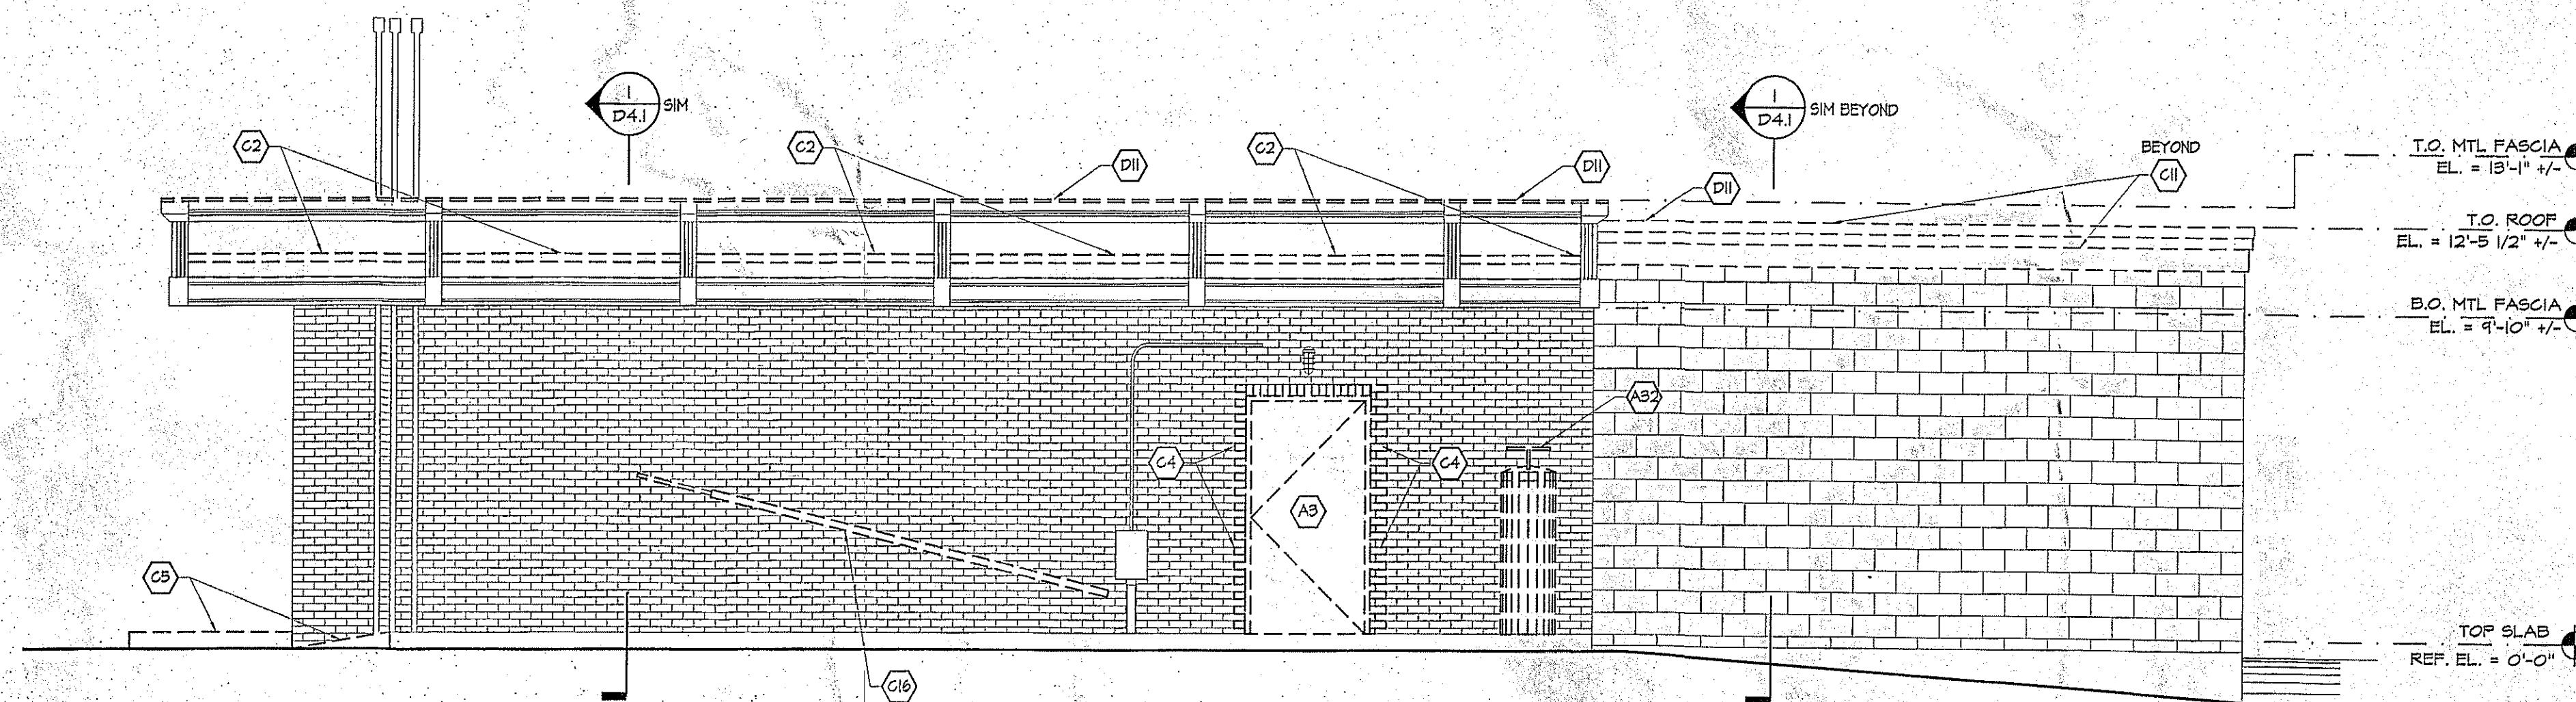


2 SOUTH (SIDE) DEMOLITION ELEVATION
SCALE: 1/4" = 1'-0"

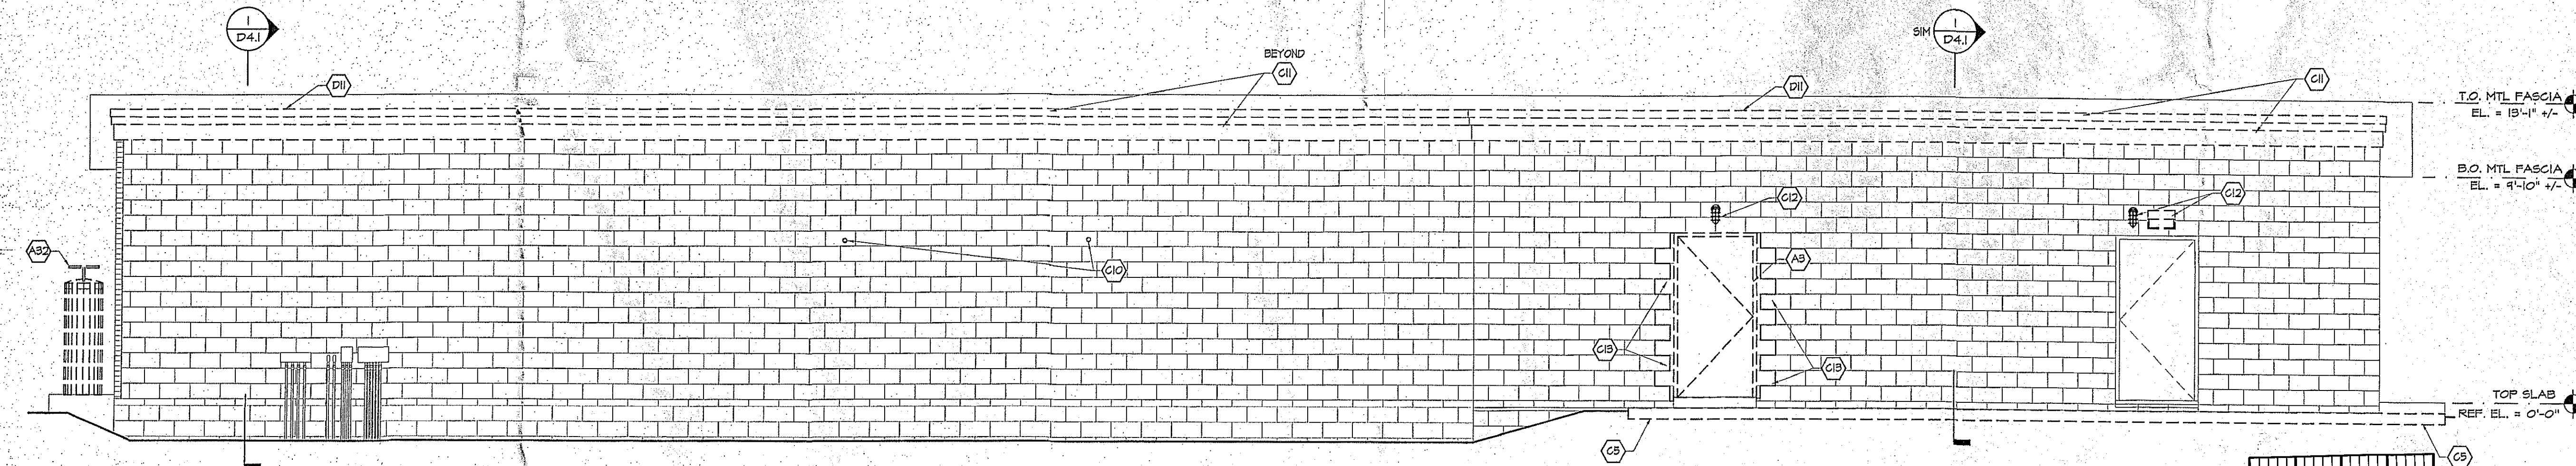

1 EAST (REAR) DEMOLITION ELEVATION
SCALE: 1/4" = 1'-0"

INCHES
Town of Bethlehem
NY KING BOARD
TOWN OF BETHLEHEM
ALBANY COUNTY, NEW YORK
By direction of the Chairman.
These drawings are hereby approved.
See sheet(s) CEG40
for date and signature.

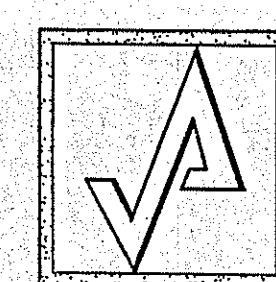


AHARONIAN
& ASSOCIATES INC.
ARCHITECTS

310 George Washington Highway
Suite 100
Smithfield, Rhode Island
0 2 9 1 7
T 401-232-5010
F 401-232-5080
WWW.ARCH-ENG.COM

DISCLAIMER


OWNERSHIP AND USE OF DOCUMENTS, DRAWINGS AND SPECIFICATIONS ARE INSTRUMENTS OF PROFESSIONAL SERVICE AND SHALL REMAIN THE PROPERTY OF THE ARCHITECT. THESE DOCUMENTS ARE NOT TO BE USED, IN WHOLE OR IN PART, FOR ANY OTHER PROJECTS OR PURPOSES OR BY ANY OTHER PARTIES THAN THOSE PROPERLY AUTHORIZED BY CONTRACT WITHOUT THE EXPRESS WRITTEN AUTHORIZATION OF THE ARCHITECT.

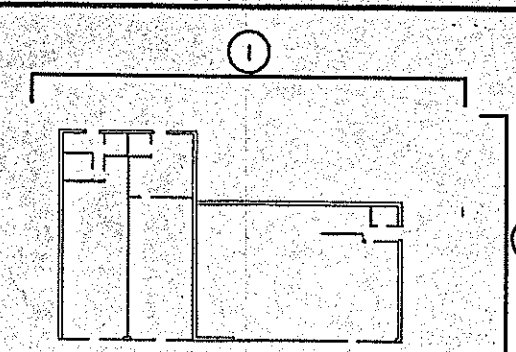

KEY PLAN

REVISIONS

NUMBER	REMARKS	DATE

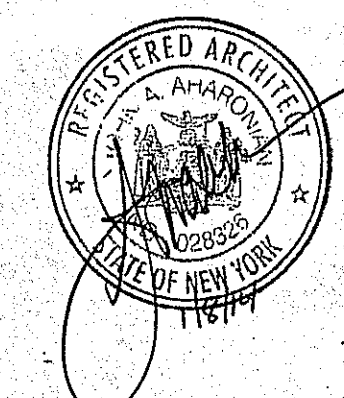

FOR CONSTRUCTION

PROJECT TITLE
Cumberland Farms
100 Crossing Blvd, Framingham, Massachusetts
STORE # 1626
PROP # V1584

430 RTE 9 WEST

GLENMONT, NY
ALBANY County

DRAWING TITLE

EXTERIOR
DEMOLITION
ELEVATIONS

DATE JULY 10, 2013	PROJ NO 1297
DRAWN BY JJ	CHECKED BY AZ

DRAWING NUMBER

D3.2