



This Site Plan Approved.

Title Darlene Mathusa
Chairman
SPA-60-A9
Date 11/21/06

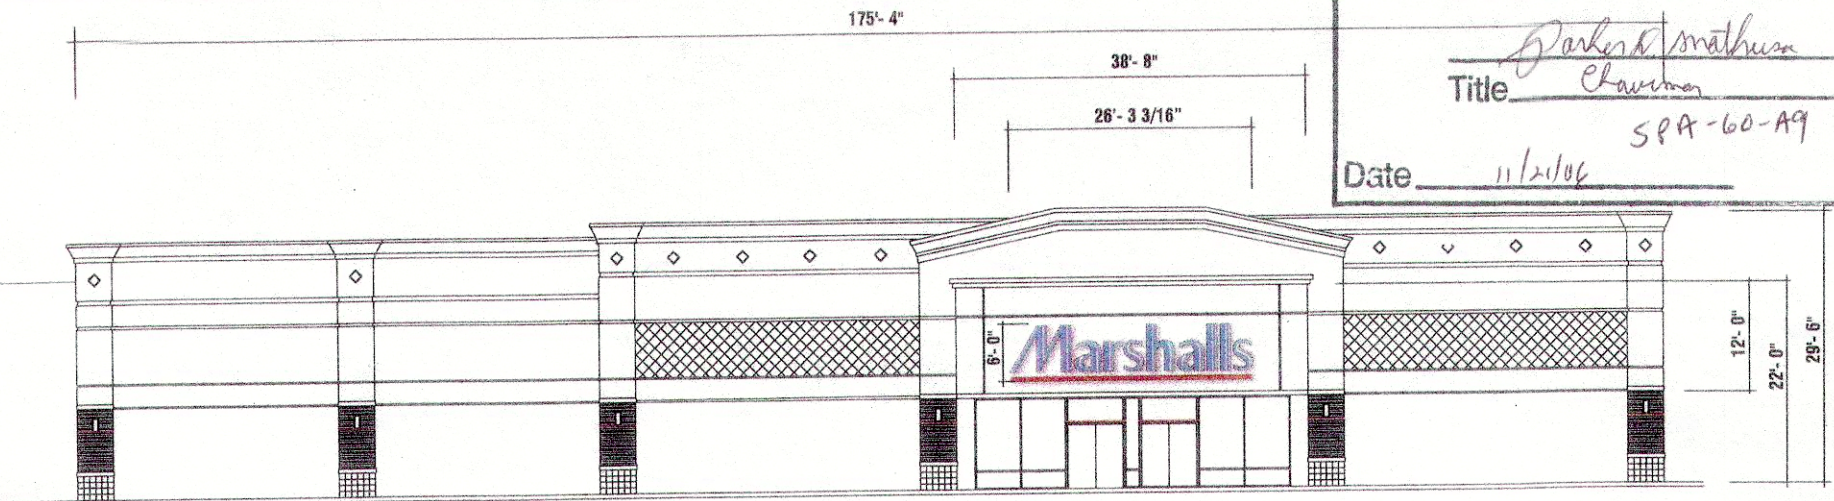

ELEVATION
NOT TO SCALE
DRAWING FROM TJX APPROVED

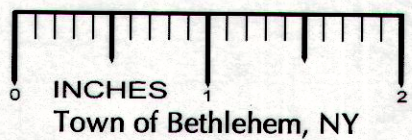

MARB-72

ILLUMINATED CHANNEL LETTERS

SCALE: 3/8" = 1'-0"

REV. 1 (B)

 75 Canal Street Suites 334-349 Bristol, PA 19007 Ph: 215.708.3838 Fax: 215.708.3878	LOCATION	PROJECT	DRAWING DESCRIPTION	REVISION	CHANGES THIS REV.:	This drawing is submitted for your exclusive use, in connection with a project being planned by Service Select, Inc. It is not to be shown to anyone outside your organization, nor is it to be used, reproduced, copied or exhibited in any fashion, without the expressed permission of Service Select, Inc.
	MARSHALLS	DATE	FACE LIT CHANNEL LETTERS (6'-0")	2-16-06 TF (B) 11-15-06 rjm (B)	DRAW. APPROVAL: DATE:	
	GLENMONT, NY	DRAWN BY:	VOLTAGE: 120 277		REF. URM. SHY # DATE:	
		SCALE	SQ. FT. ALLOWANCE		COMMENTS:	
		AS NOTED				



SPA 60-A9



16 Canal Street - Suite 1334
Bristol, PA 19007
Ph: 215.788.3898
Fax: 215.788.3876

CLIENT: **Marshall's**

LOCATION: **MARSHALL'S
GLENMONT, NY**

DESCRIPTION: **FACE LIT
CHANNEL LETTERS (6'-0")**

PROJECT #: **SS#13886-R2 (OPT. 2)**

SCALE: **AS NOTED**

DRAWN BY: **TF**

DATE: **1-18-05**

DESIGN APPROVAL: **X**

REV. DATE: **SHT. 6**

REVISION:

2-26-06	TF (OPT. 2)
11-15-06	rjm (OPT. 2)

CHANGE MADE ON REV:


VOLTAGE:

ALLOWABLE SQ. FT.:

PROPOSED SQ. FT.:

This drawing is submitted for your exclusive use, in connection with a project being planned by Service Select, Inc. It is not to be shown to anyone outside your organization, nor is it to be used, reproduced, copied or exhibited in any fashion, without the expressed permission of Service Select, Inc.

Page 2 of 2

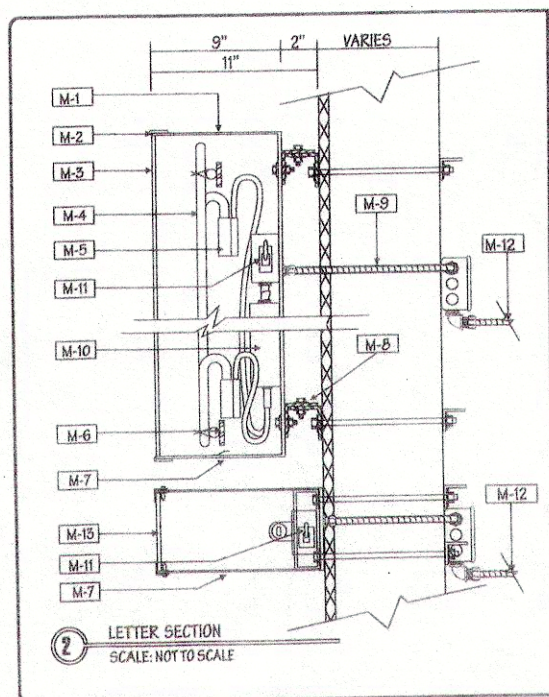

MATERIAL DESCRIPTION

M1 .050 ALUMINUM RETURNS. FINISH TO BE SPRAYED WHITE. .090 ALUMINUM BACKS. INSIDE OF LETTERS WHITE. ALL PAINTS TO BE INDUSTRIAL POLY-URETHANE FINISH.

M2 1" WHITE TRIM-CAP.

M3 3/16" FLAT WHITE SG ACRYLITE # TL-015-2 (CYRO) W/ BLUE VINYL OVERLAY

M4 15 MM 6500 WHITE NEON.

M5 DOUBLE BACK ELECTRODES WITH U.L. APPROVED ELECTRODE BOOTS AND 15000 VOLT GTO WIRE.

M6 CROSS BRACING BETWEEN RETURNS FOR TUBE SUPPORTS.

M7 1/4" WEEP HOLES AS REQUIRED.

M8 2" X 2" X 3/16" GALVANIZED STEEL CLIPS WITH MOUNTING HARDWARE (TYPE DEPENDING UPON WALL CONSTRUCTION).

M9 1/2" "SEALTITE" FLEX CONDUIT AND CONNECTORS.

M10 30 M.A. NORMAL POWER FACTOR SELF-CONTAINED TRANSFORMERS (GROUND FAULT PROTECTED AND 2161 U.L. APPROVED).

M11 20 AMP DISCONNECT SWITCH ON OUTSIDE OF LETTERS.

M12 J-BOXES AND PRIMARY ELECTRICAL LEADS.

M13 UNDERSCORE: ALUMINUM RETURNS TO MATCH P.M.S. #186C (RED). 1" RED TRIM CAP. FACE TO BE WHITE LEXAN W/ VINYL OVERLAY (3M #3630-33 RED) 800 M.A. HIGH OUTPUT FLUORESCENT ILLUMINATION WITH (120 VOLT) H.Q. BALLASTS.



UL REQUIRED

NEW UL 2161 G.F.P. SIGN TRANSFORMER REQUIRE THAT ALL CIRCUITS MUST HAVE DEDICATED HOT, NEUTRAL, GROUND TERMINATING AT PANEL. QUESTIONS: CALL ISO CORP. 1-800-780-7448

CIRCUITS REQUIRED

TWO (2) 20 AMP 120 VOLT CIRCUITS REQUIRED

SIGN MUST BE GROUNDED IN COMPLIANCE WITH ARTICLE 600 OF THE NATIONAL ELECTRIC CODE.



BRIGHT BLUE
3630-167 VINYL



LETTER RETURNS
WHITE



BAR FACE
OVERLAY WHITE
LEXAN
RED VINYL
3630-33 RED



BAR RETURNS
P.M.S. #186C RED



INCHES
Town of Bethlehem, NY



SQUARE FOOTAGE ACTUAL TOTAL: 115 SQ. FT.

MARB-72