


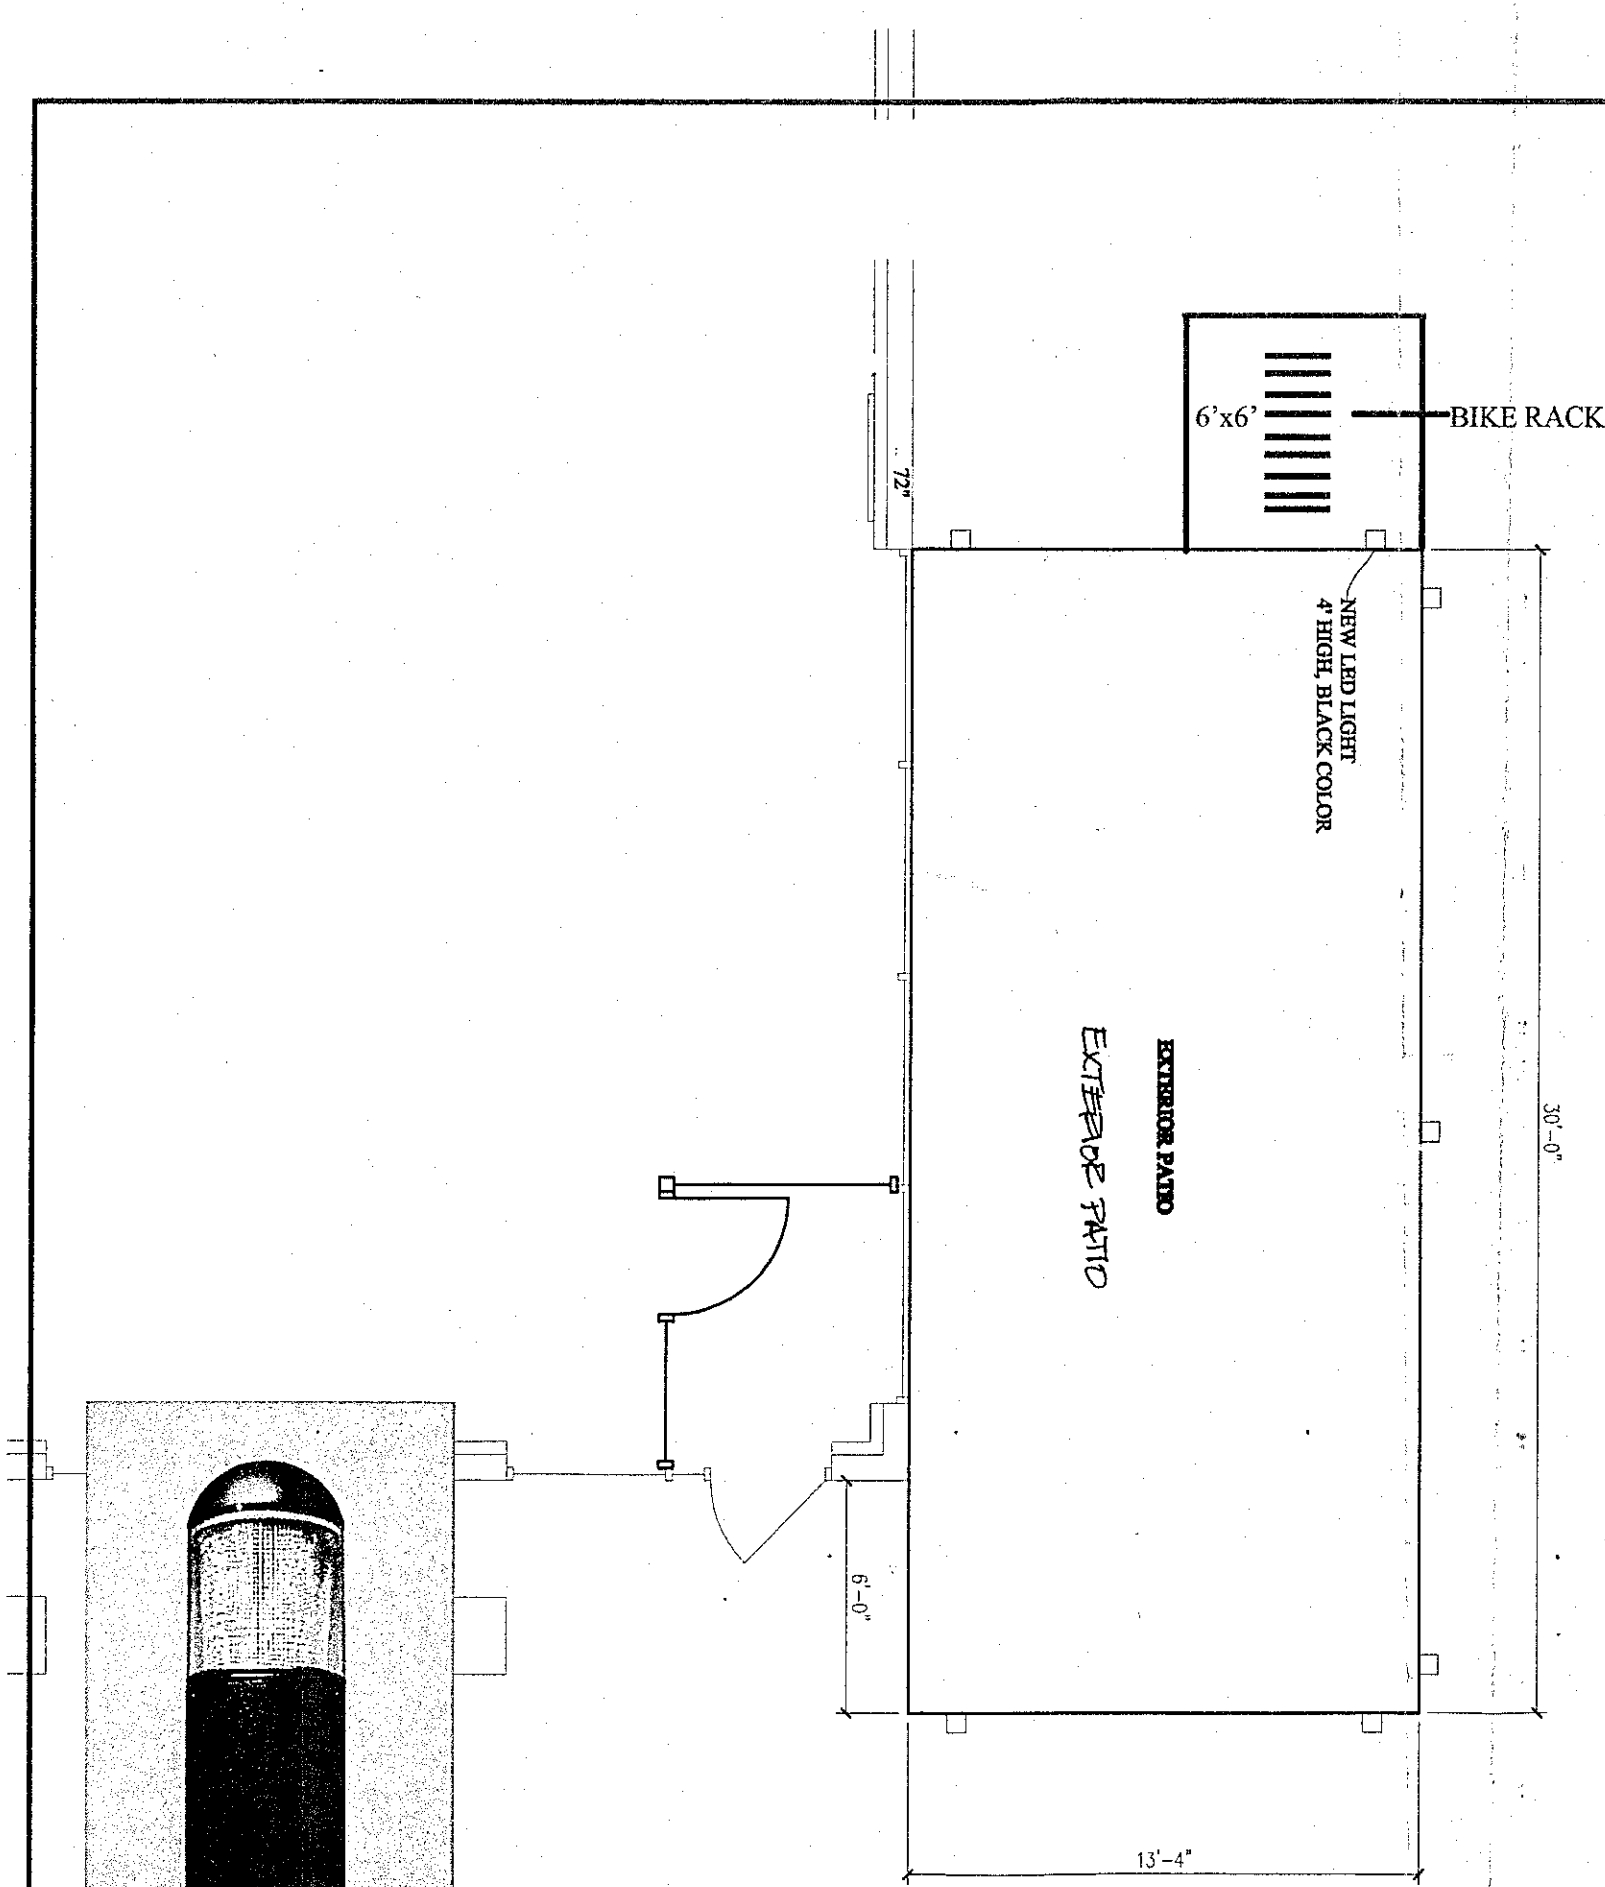



3 PATIO AND LIGHTING PLAN
1/4"=1'-0"

4 LIGHTING DETAIL
N.T.S.


5 LIGHTING DETAIL
N.T.S.




7 LIGHTING DETAIL
N.T.S.

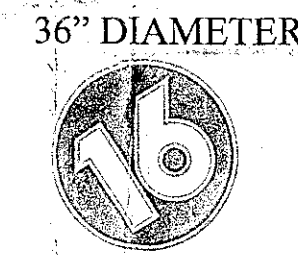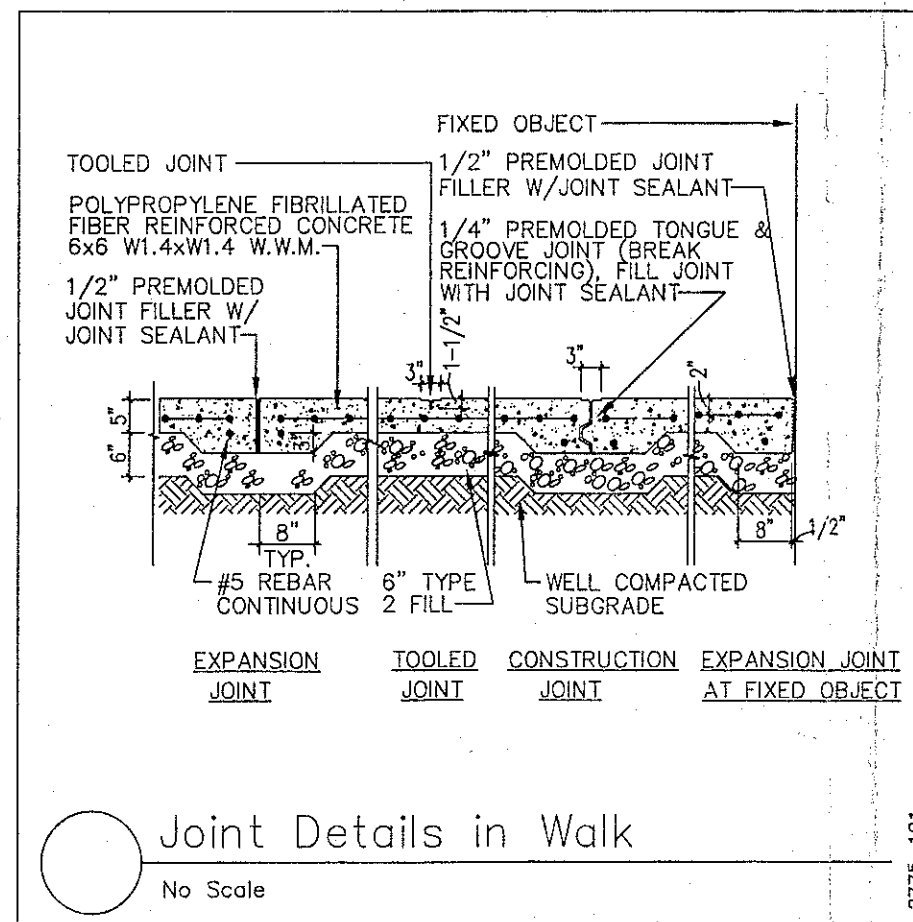


6 LIGHTING DETAIL
N.T.S.

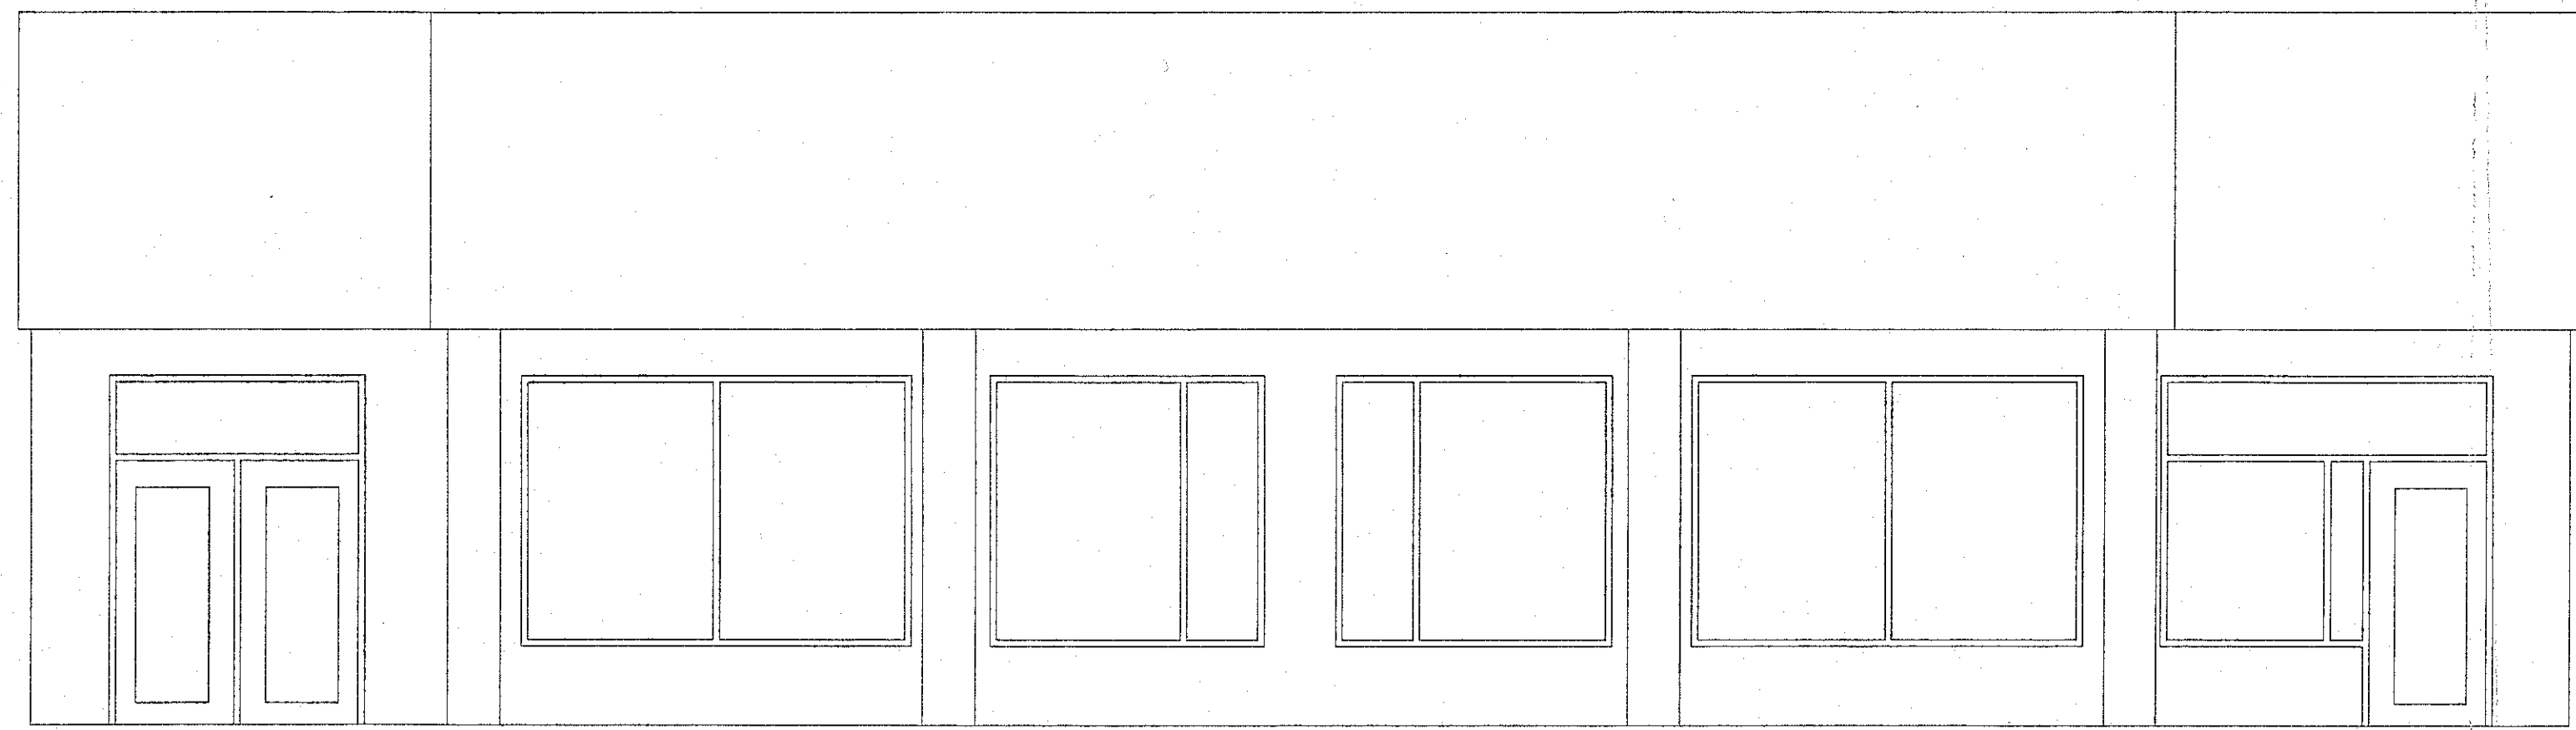



1 EXISTING ELEVATION
1/4"=1'-0"

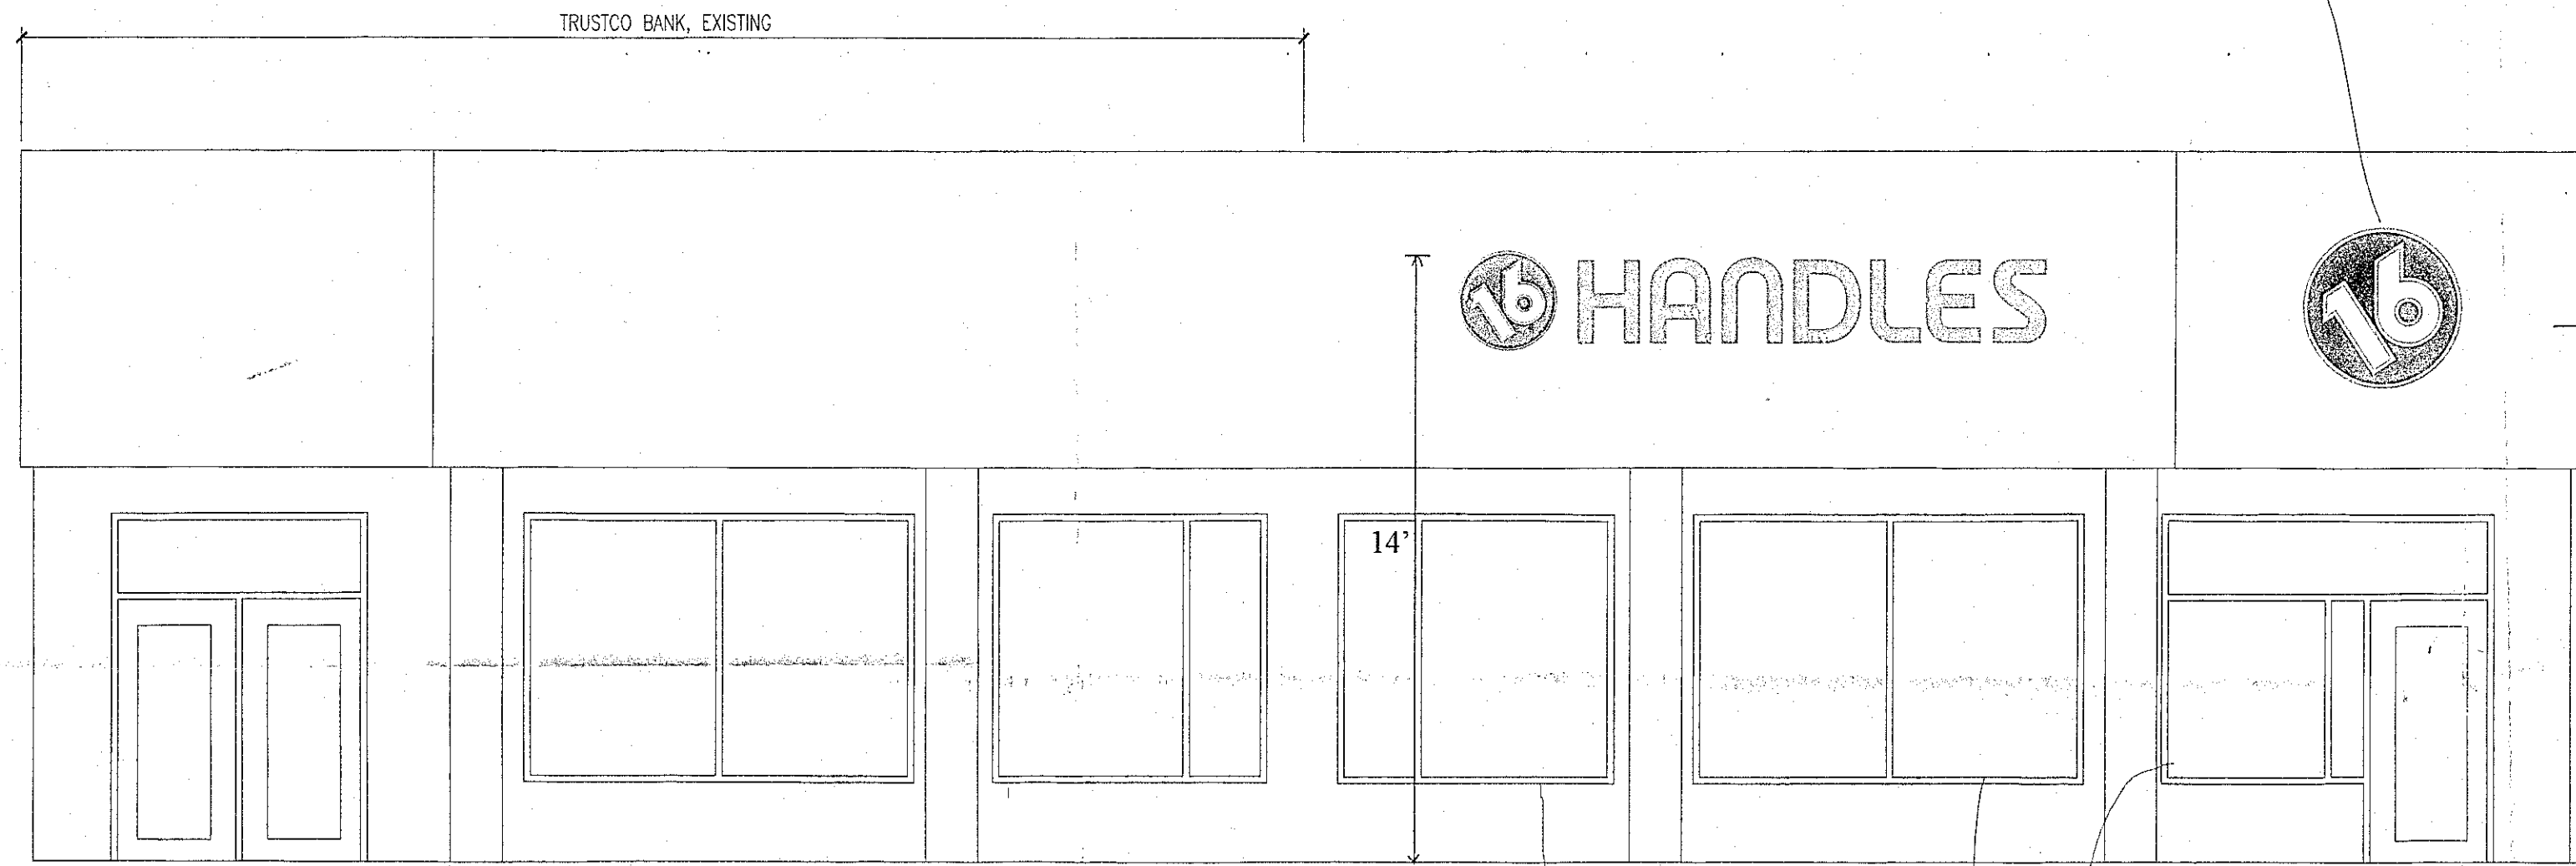


2 PROPOSED ELEVATION
1/4"=1'-0"

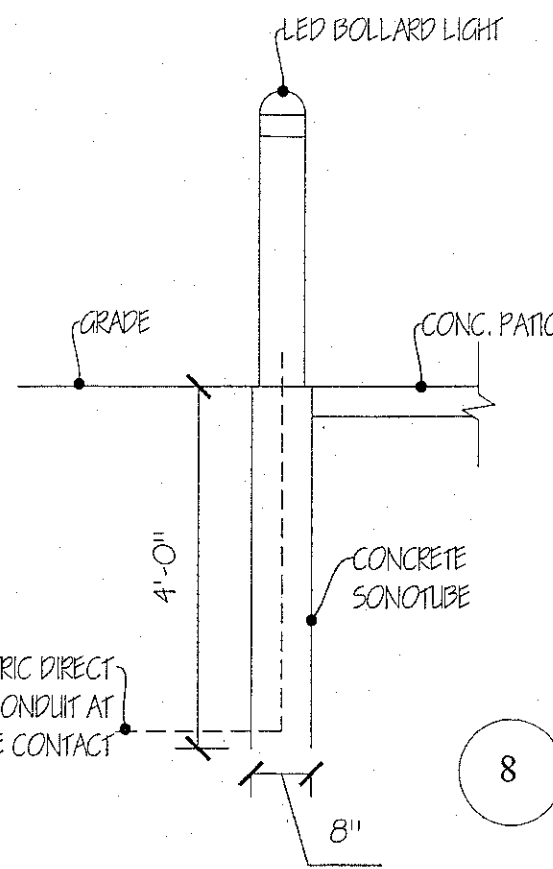

8 LIGHTING DETAIL
N.T.S.

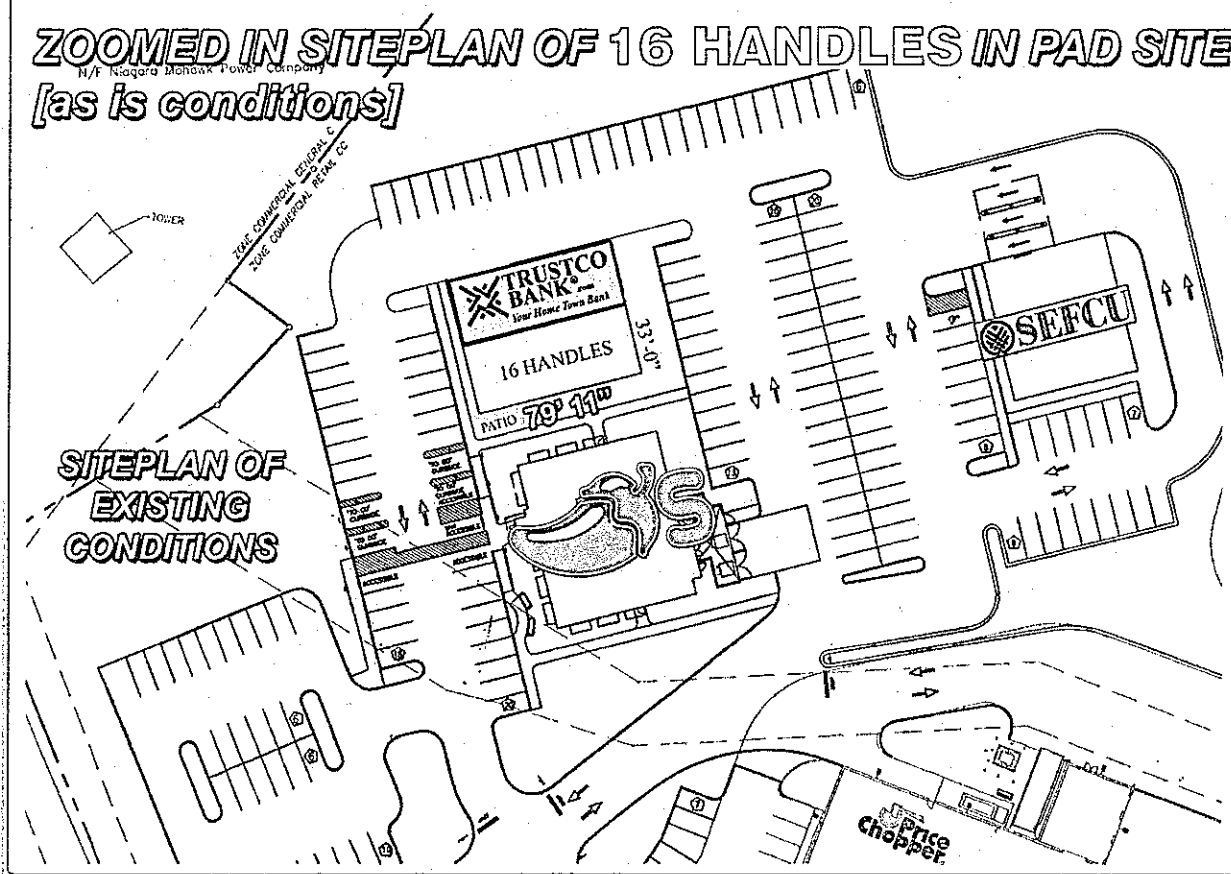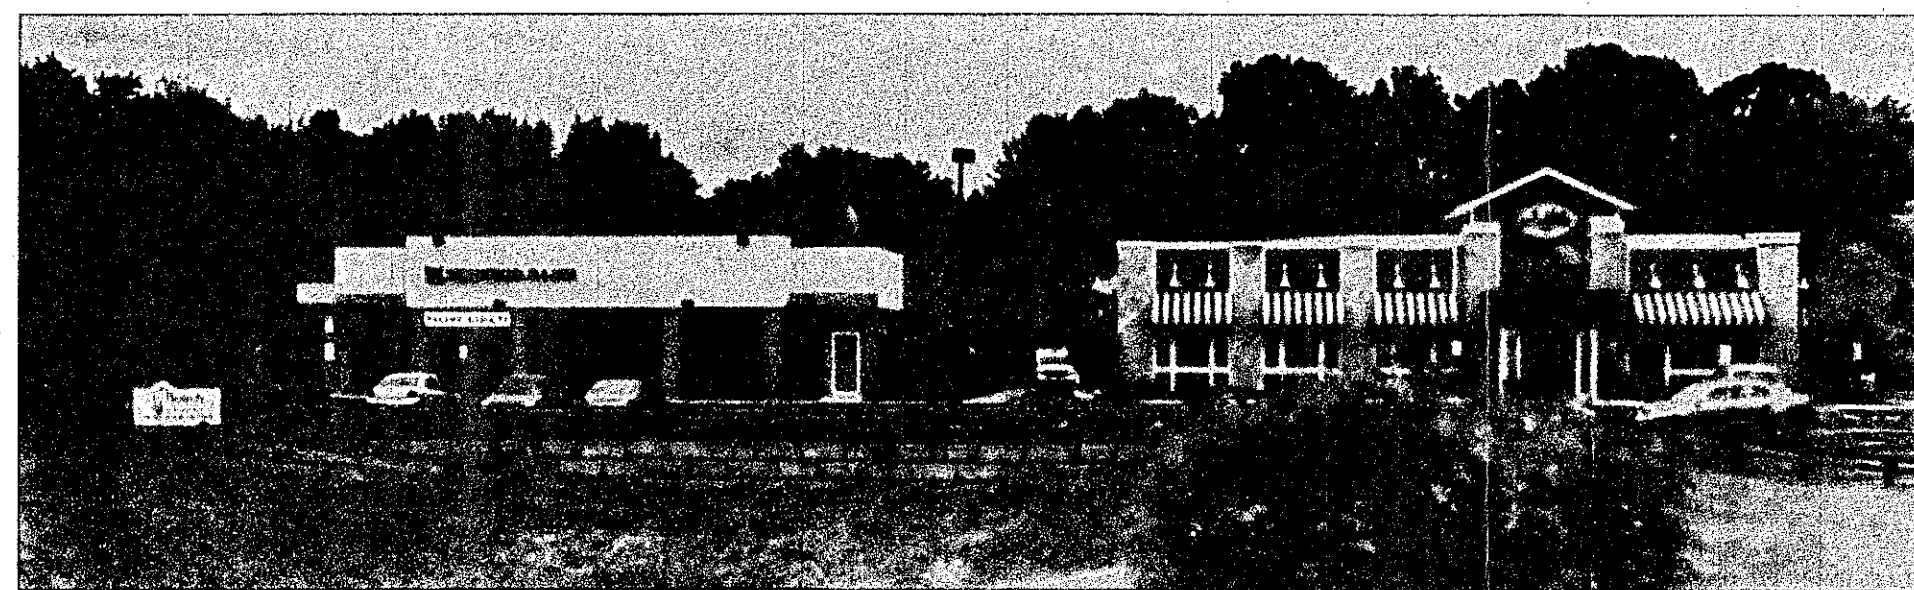


Town of Bethlehem Planning board Endorsement

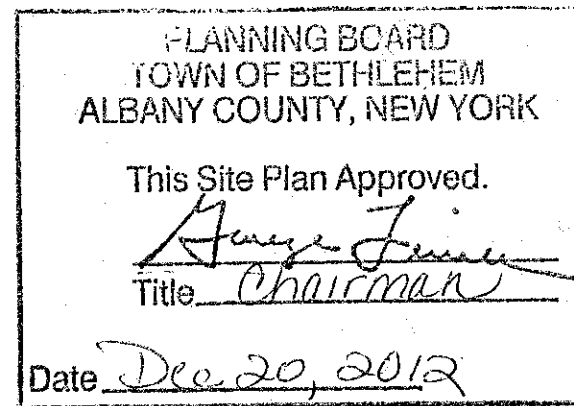

CAPITAL ARCHITECTURE
86 REMSEN STREET
COHUES, NEW YORK 12047
874-1320 OFFICE, 874-1321 FAX, 253 1442 CELL
capitalarchitecture@yahoo.com

THIS WORK WAS PREPARED BY ME
OR UNDER MY SUPERVISION AND
I AM A LICENSED PROFESSIONAL
ARCHITECT IN THE STATE OF NEW YORK.

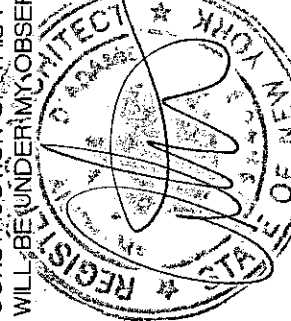

16 HANDLES
380-2nd Route 9W
GLENMONT, NY

SITE PLAN AMENDMENT
ELEVATIONS, SIGN DETAIL, LIGHTING DETAIL

SCALE:	AS NOTED	REVISIONS:
DATE:	16 SEPTEMBER 12	
DRAWN:	MAW	
SHEET#		

A1