




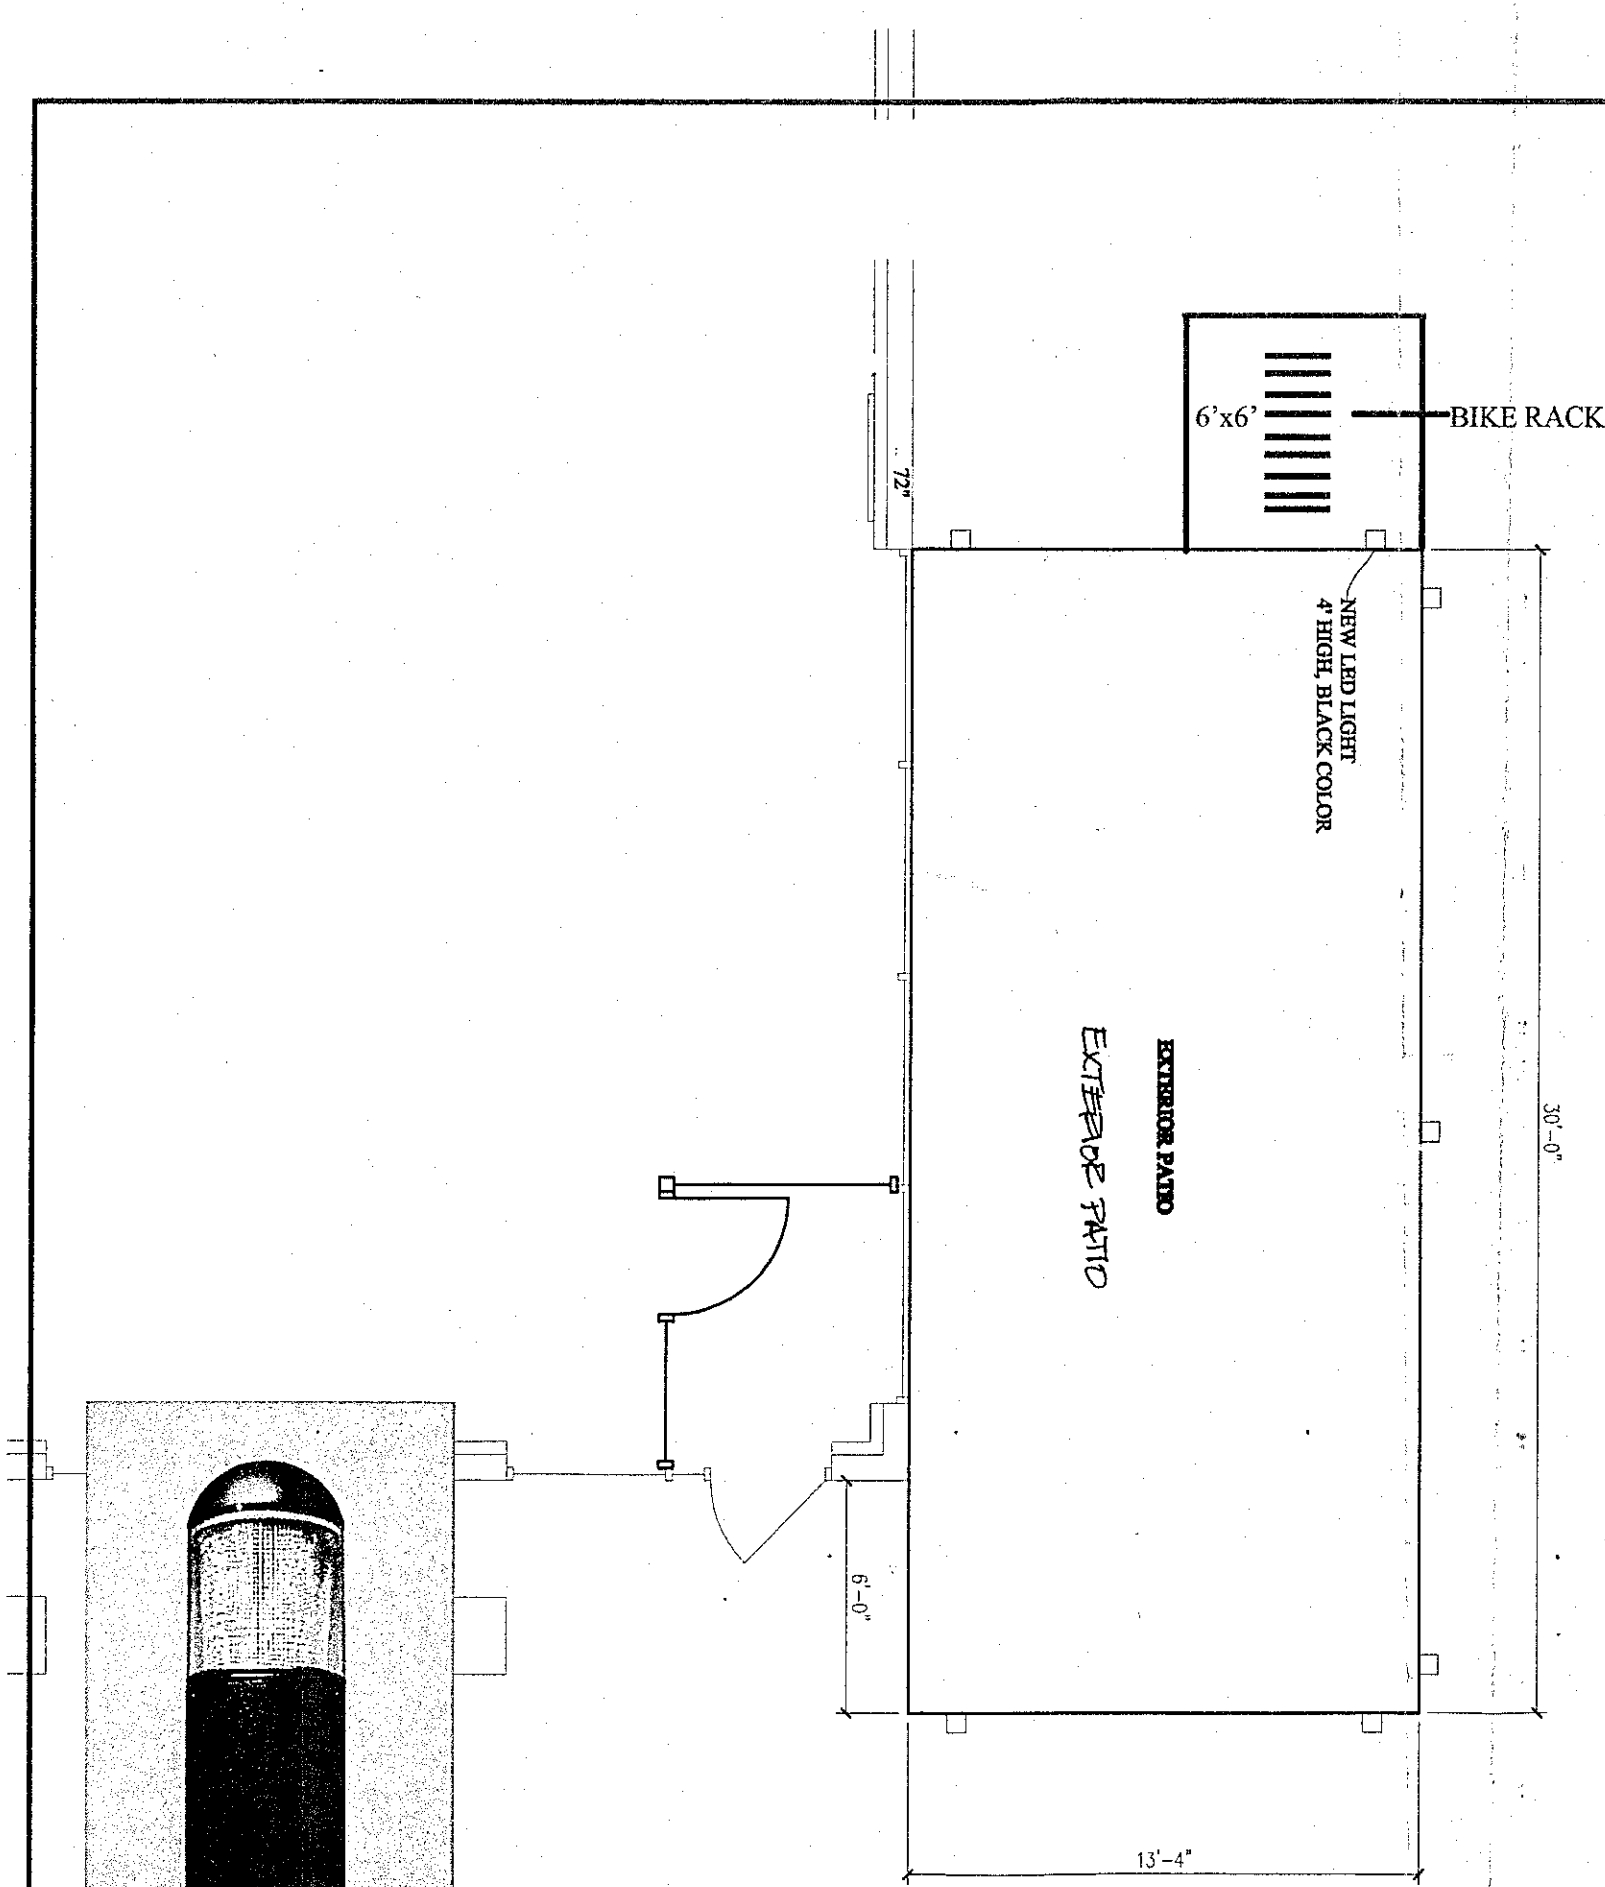

3 PATIO AND LIGHTING PLAN
1/4"=1'-0"

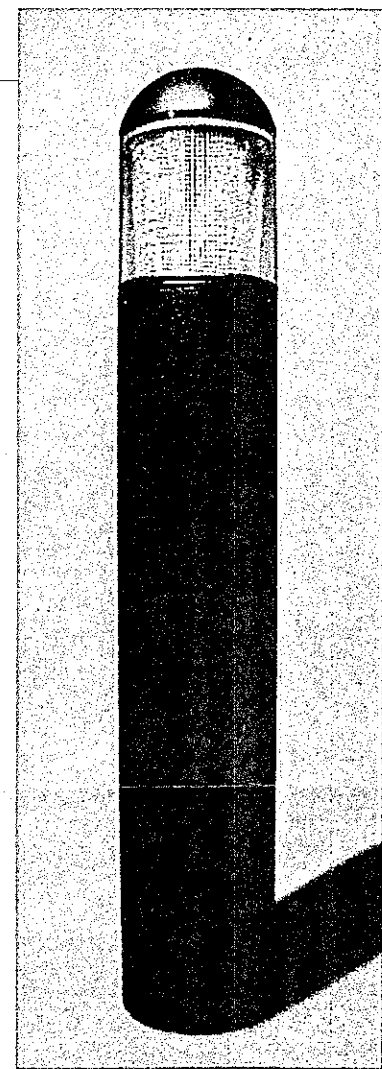


4 LIGHTING DETAIL
N.T.S.

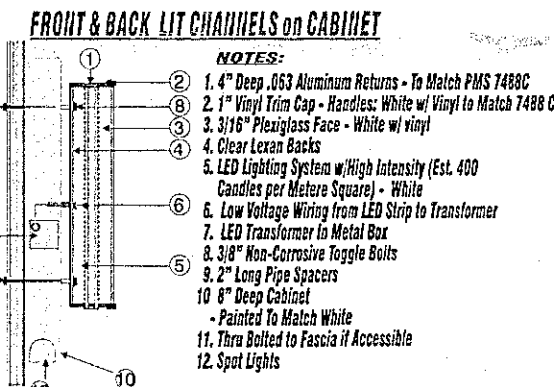


5 LIGHTING DETAIL
N.T.S.




7 LIGHTING DETAIL
N.T.S.

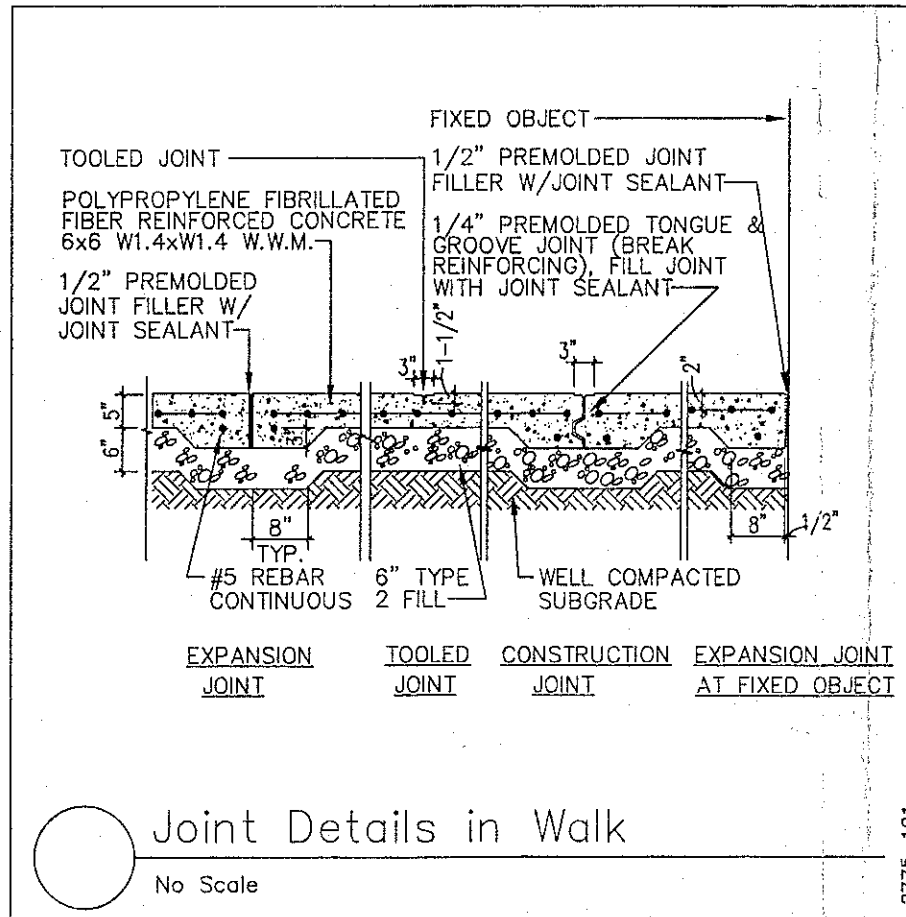


Joint Details in Walk
No Scale

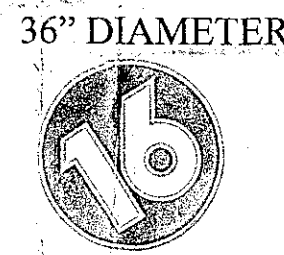


6 LIGHTING DETAIL
N.T.S.

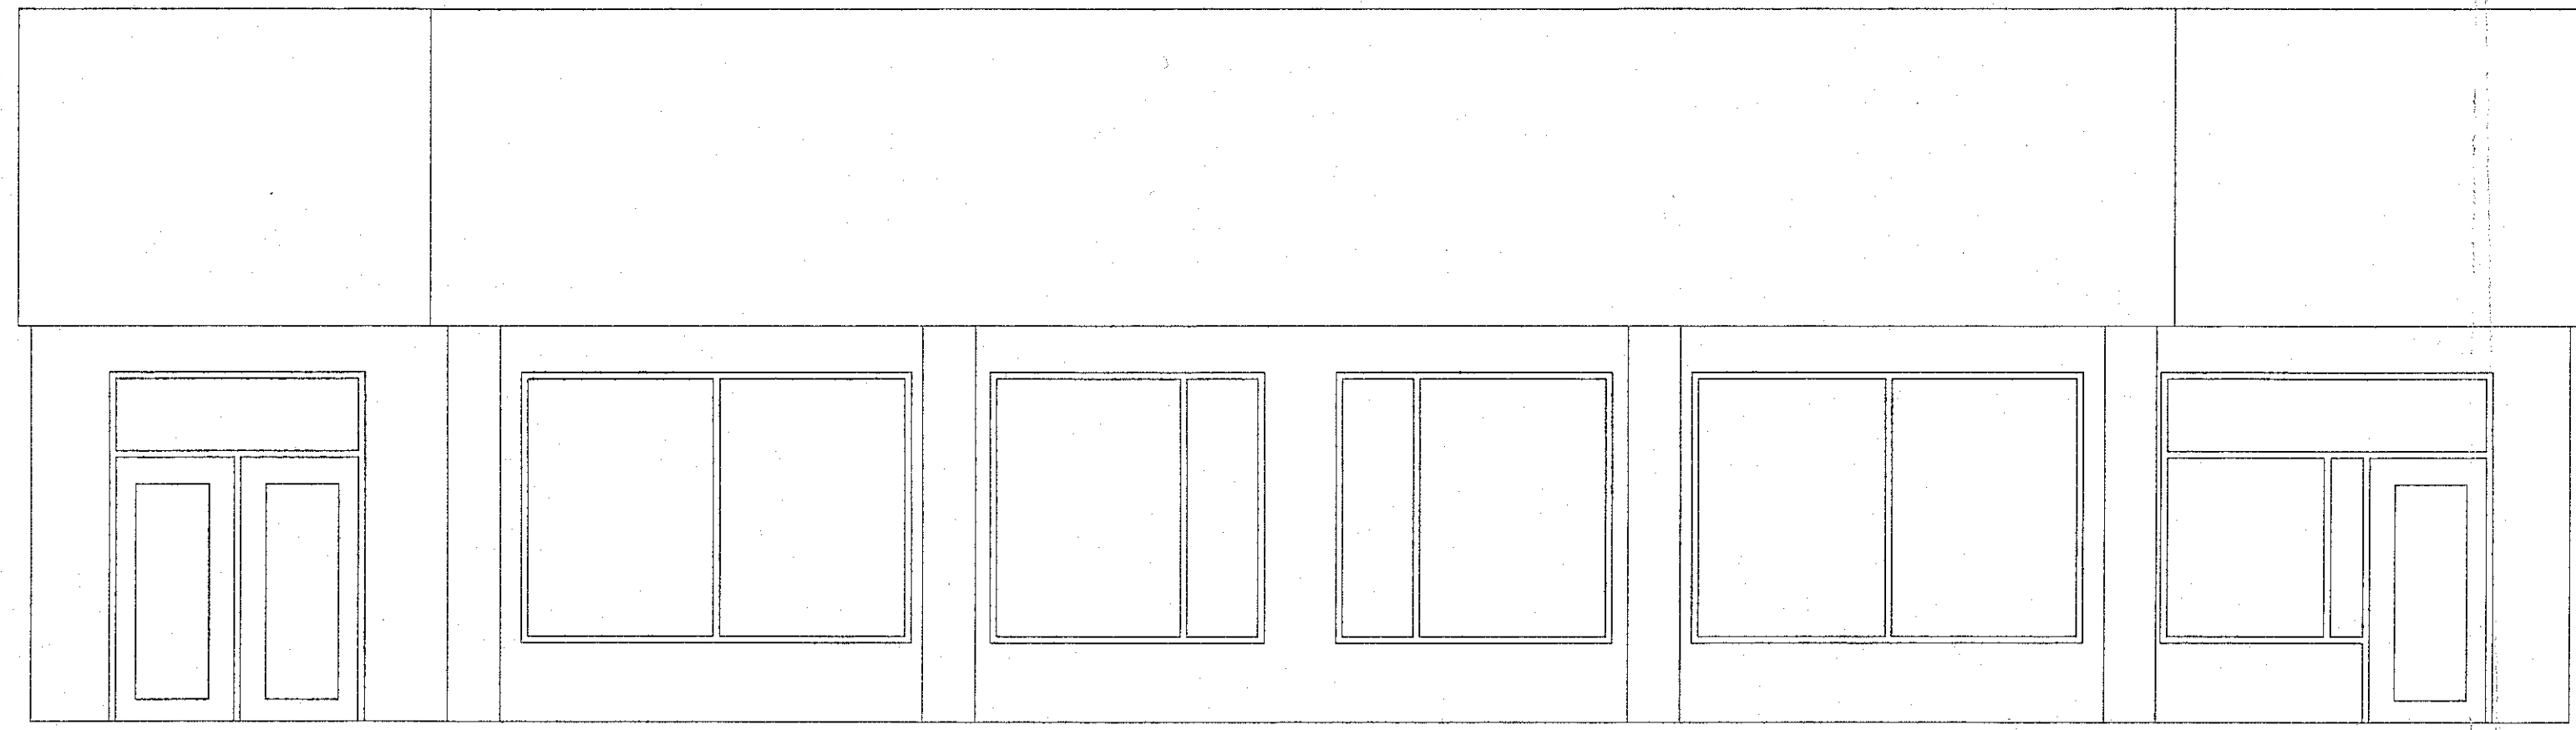



1 EXISTING ELEVATION
1/4"=1'-0"

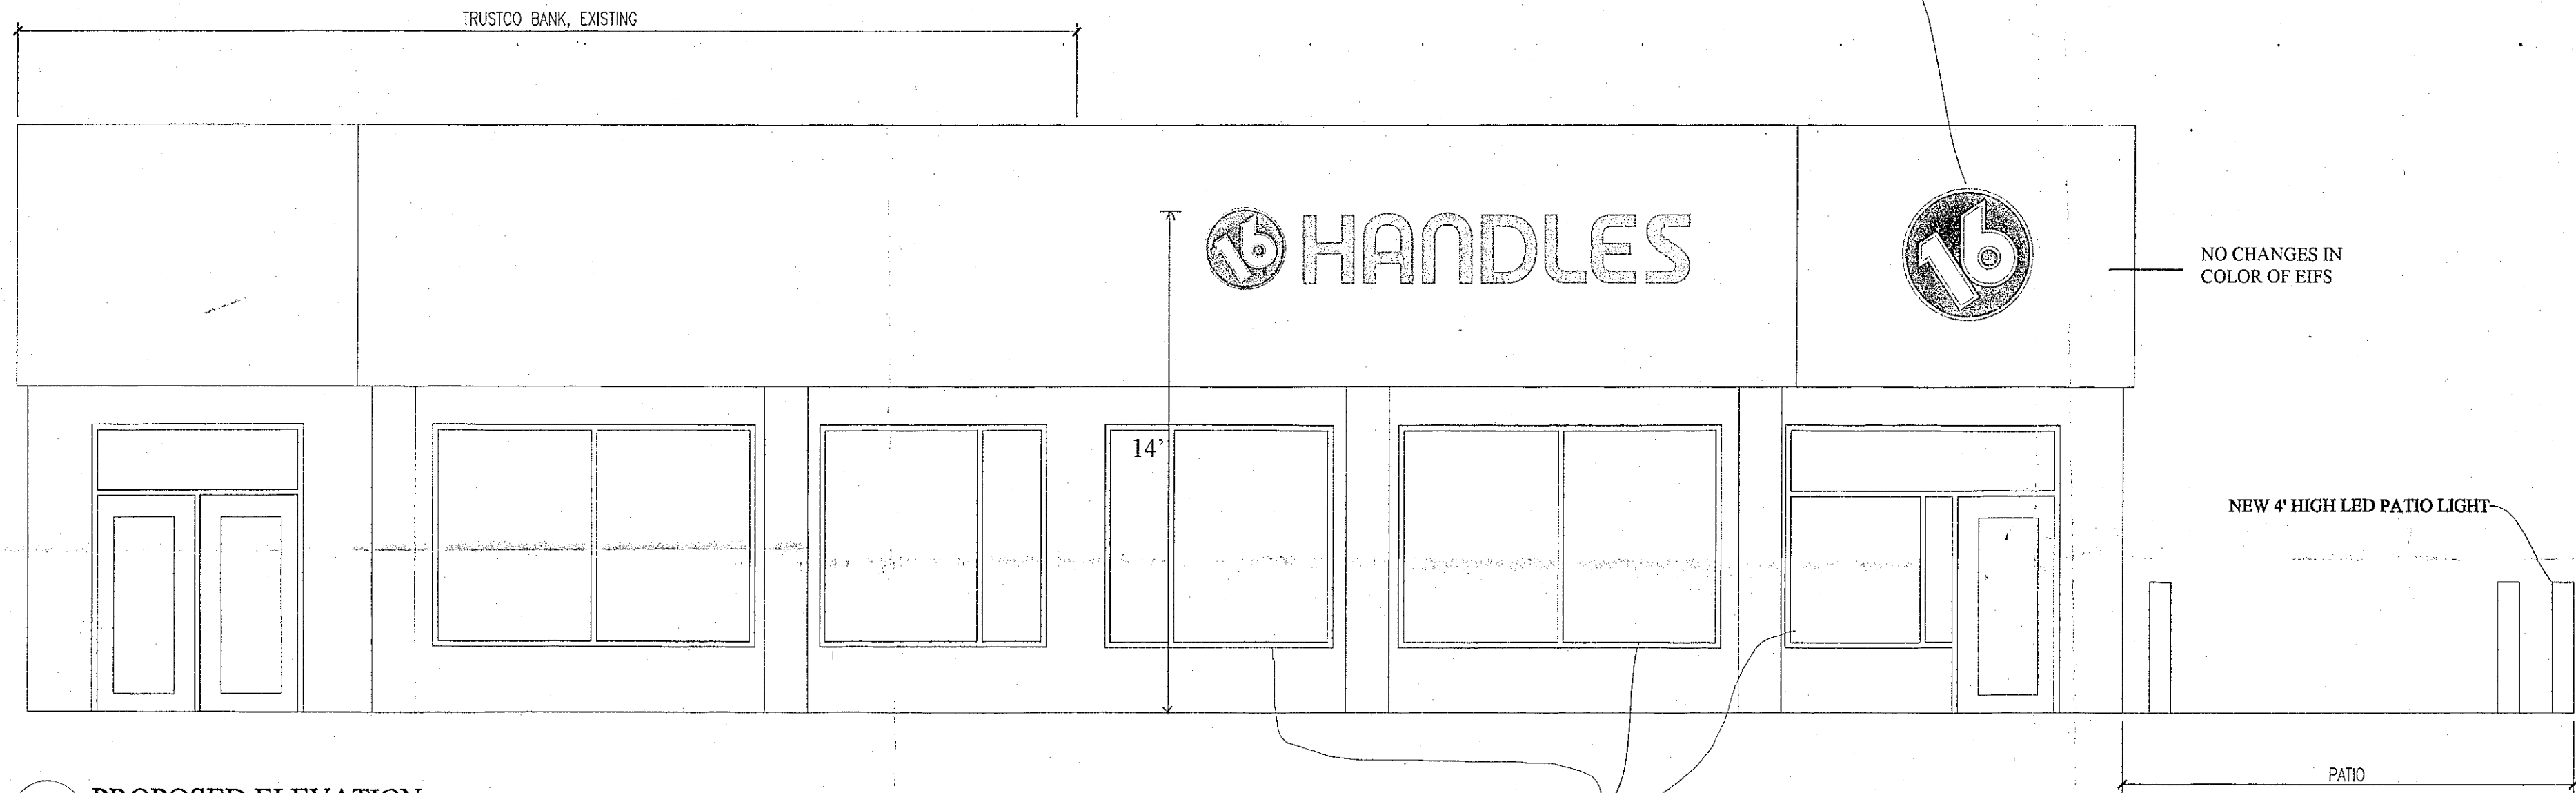

2 PROPOSED ELEVATION
1/4"=1'-0"

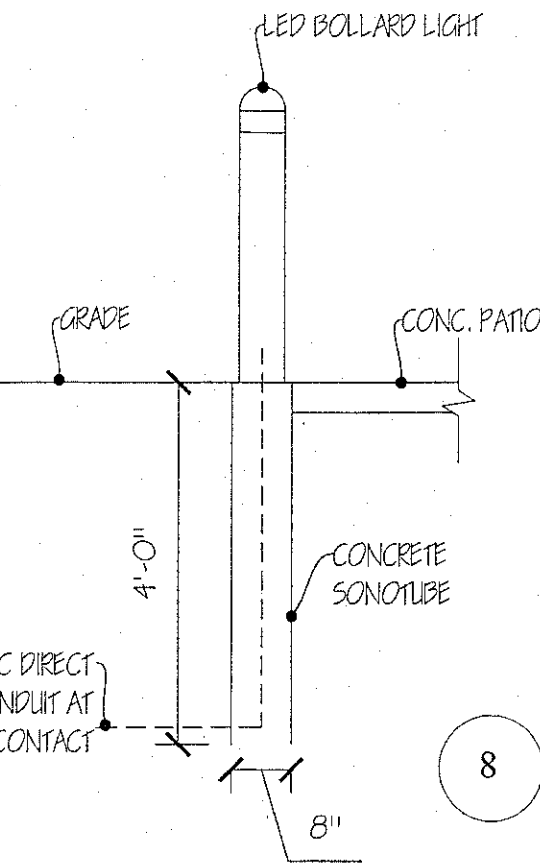


8 LIGHTING DETAIL
N.T.S.

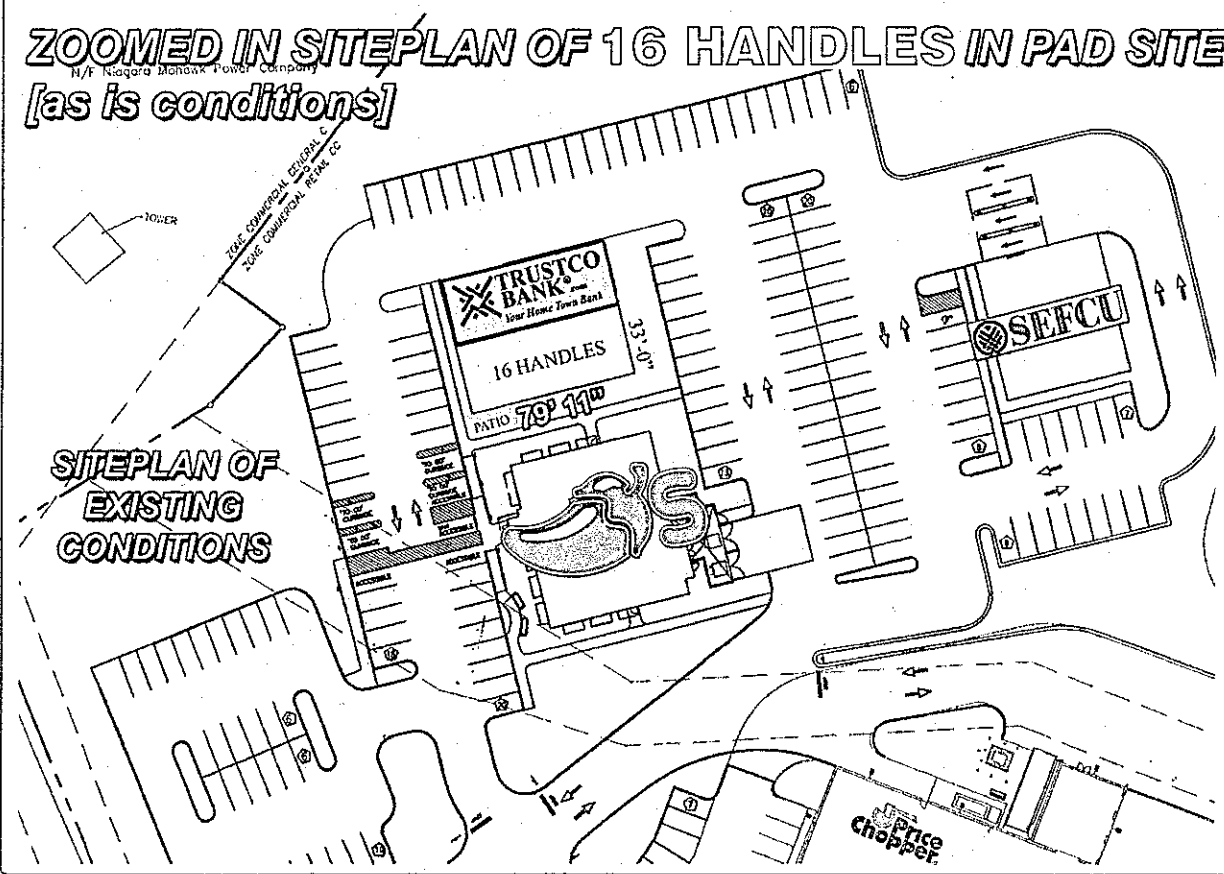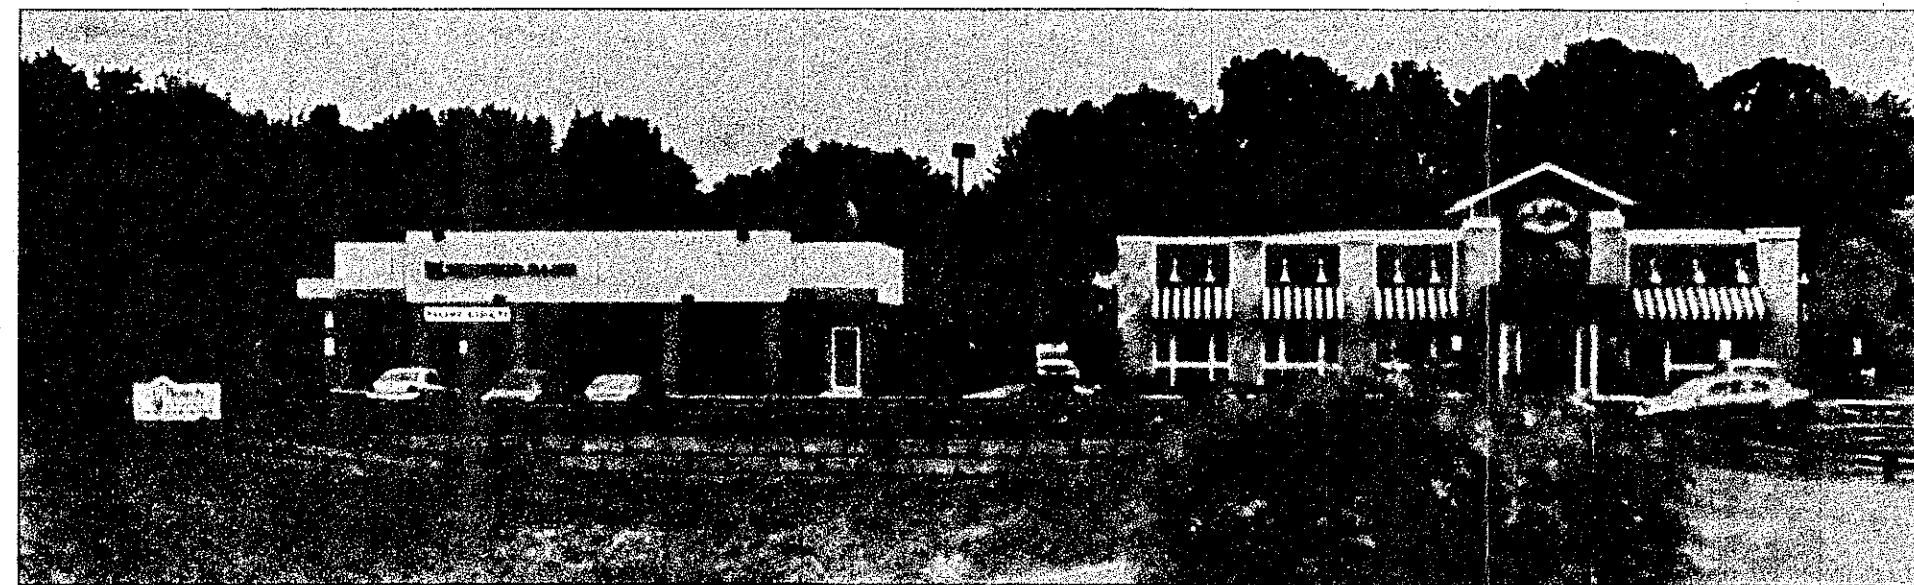


ZOOMED IN SITEPLAN OF 16 HANDLES IN PAD SITE
[as is conditions]

Town of Bethlehem Planning board Endorsement

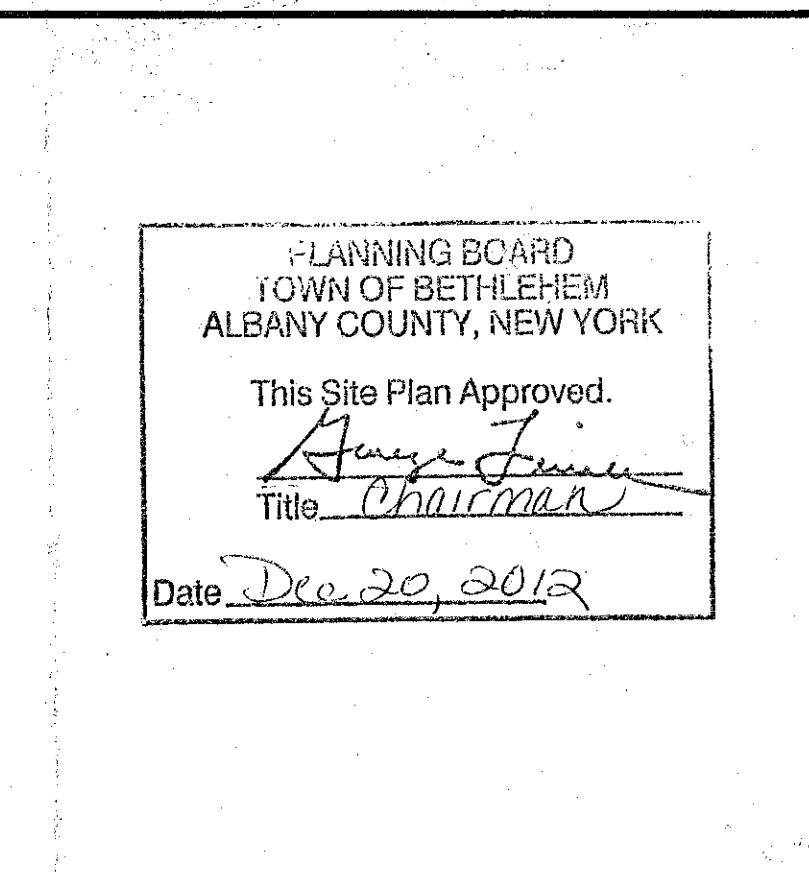

CAPITAL ARCHITECTURE
86 REMSEN STREET
COHUES, NEW YORK 12047
874-1320 OFFICE, 874-1321 FAX, 253 1442 CELL
capitalarchitecture@yahoo.com

THIS WORK WAS PREPARED BY ME
OR UNDER MY SUPERVISION AND
I AM A LICENSED PROFESSIONAL
ARCHITECT IN THE STATE OF NEW YORK.

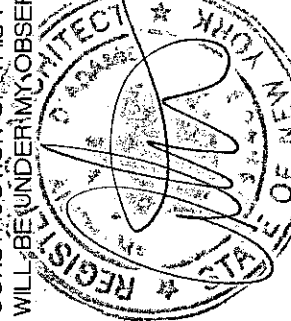


16 HANDLES
380-2nd Route 9W
GLENMONT, NY

SITE PLAN AMENDMENT
ELEVATIONS, SIGN DETAIL, LIGHTING DETAIL

SCALE:	AS NOTED	REVISIONS:
DATE:	16 SEPTEMBER 12	
DRAWN:	MAW	
SHEET#		

A1

1 SITE PLAN
1"=10'

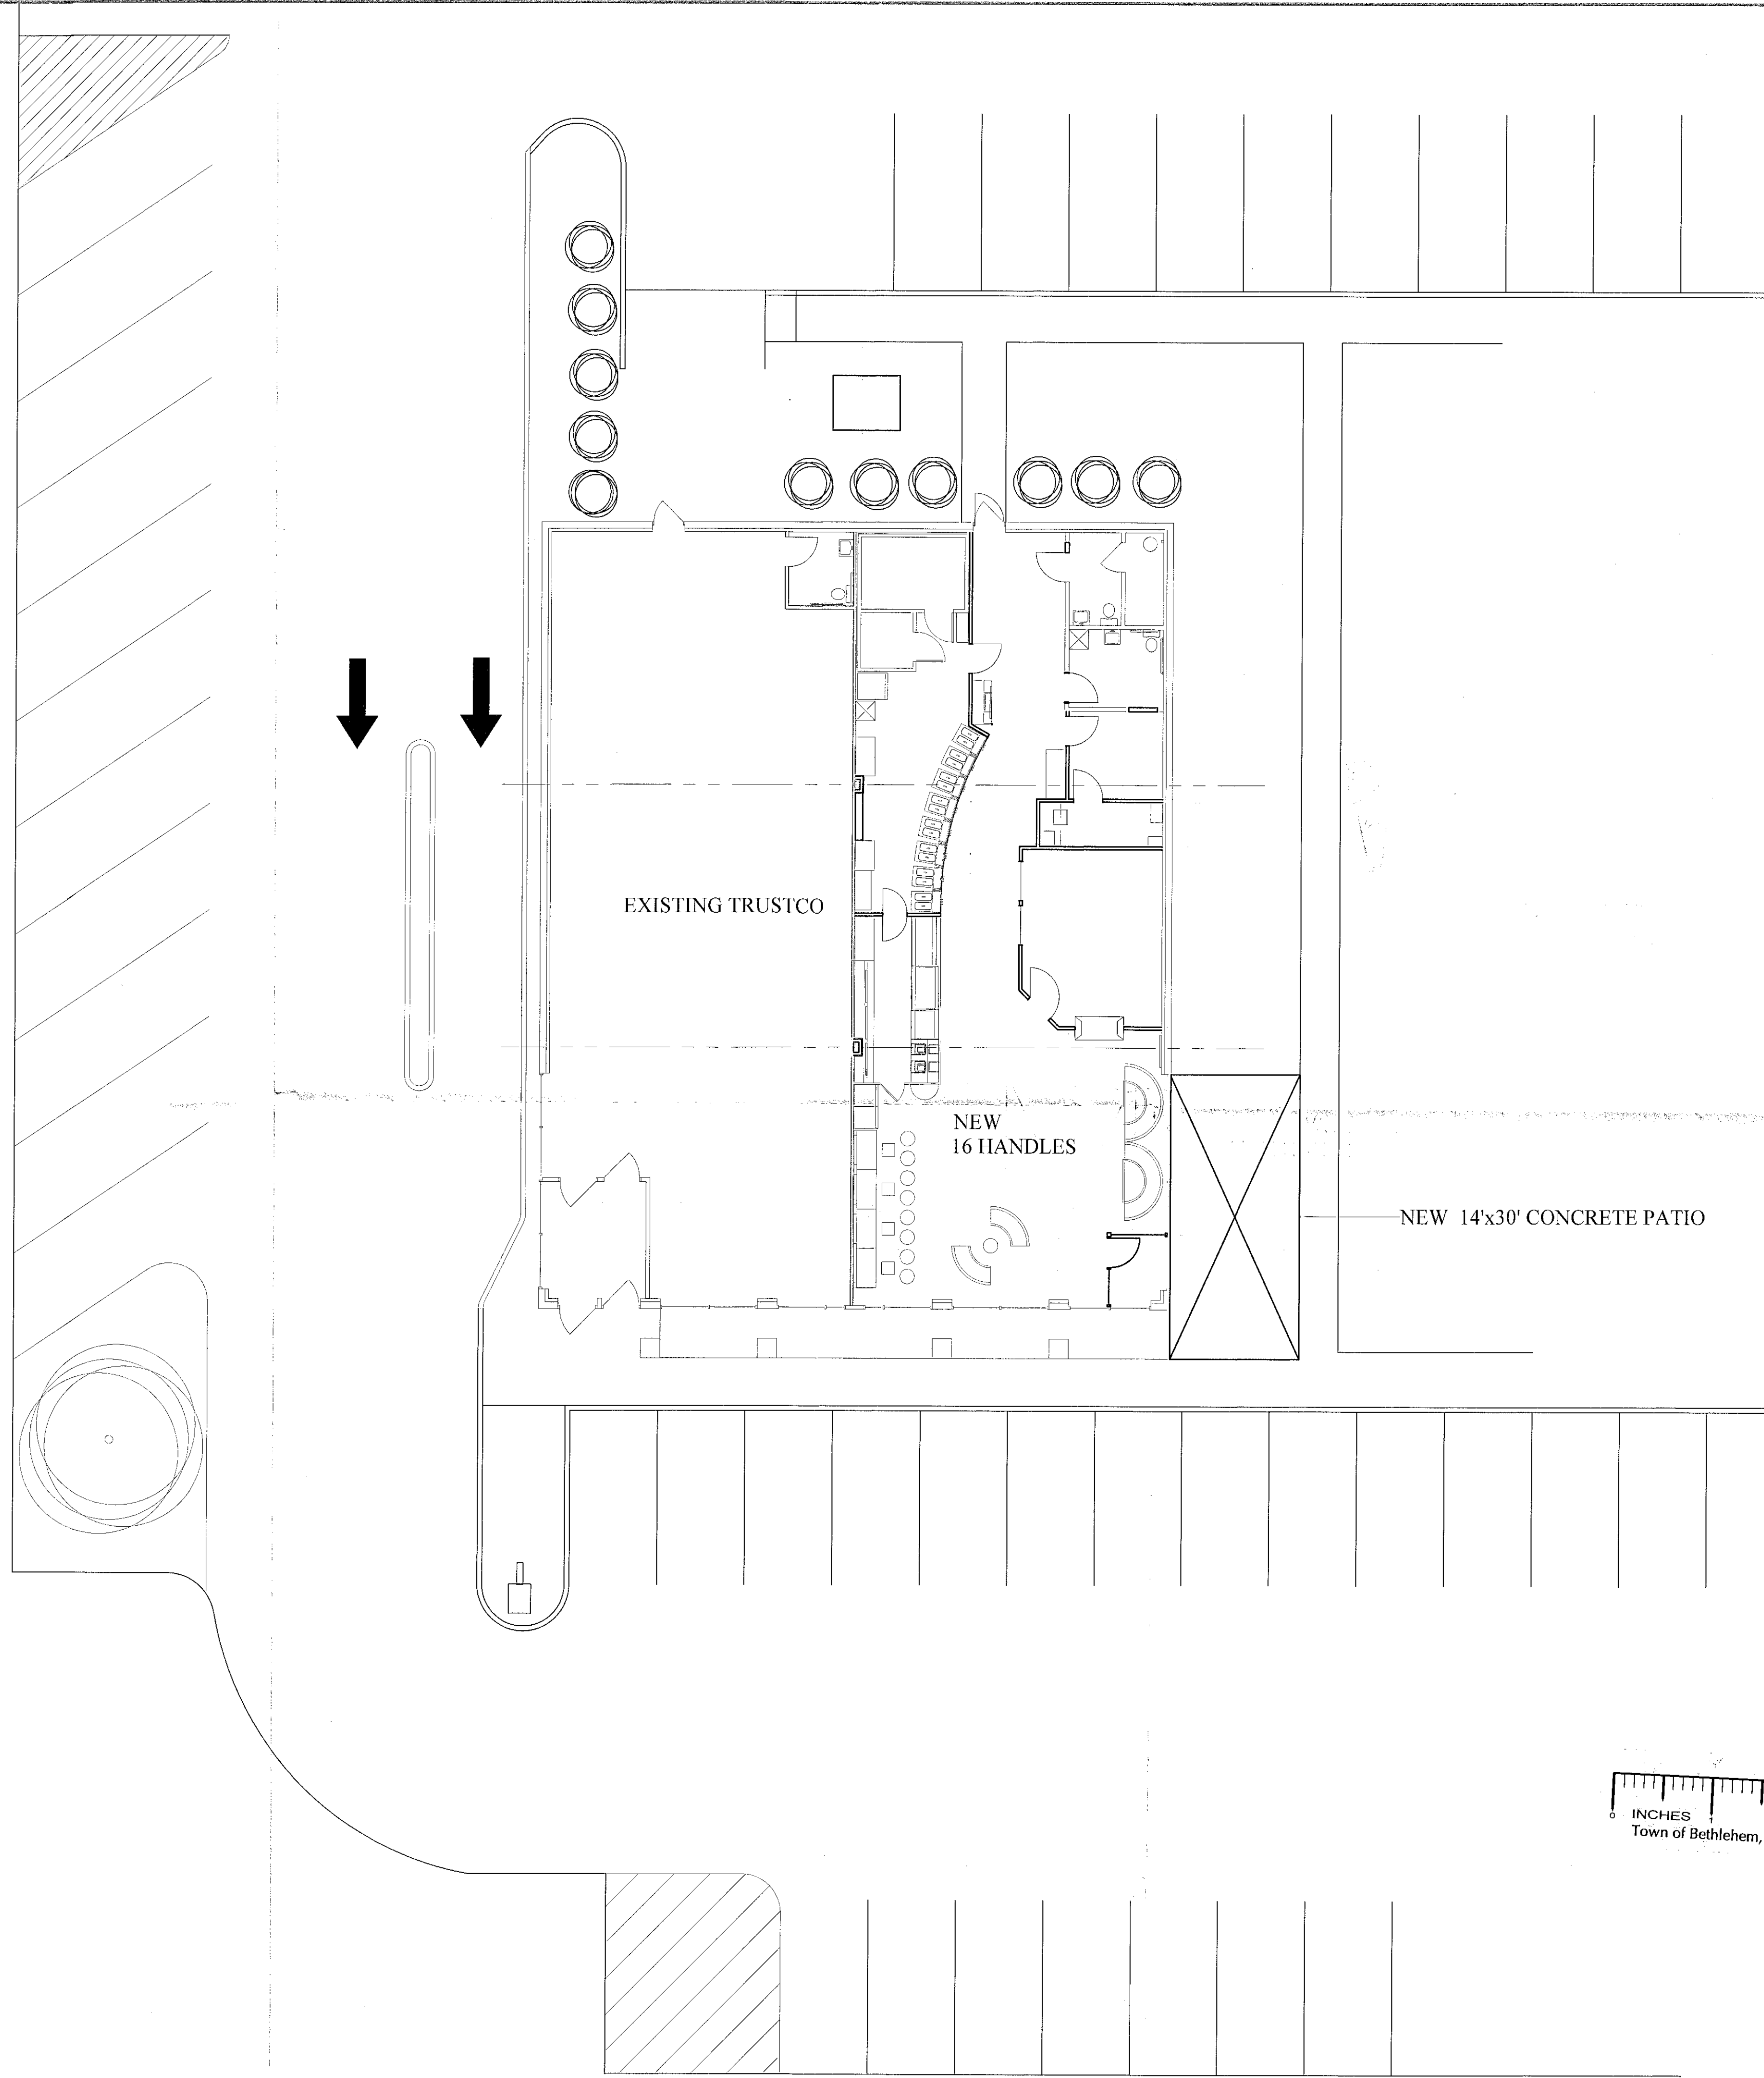

0 1 2
INCHES
Town of Bethlehem, NY

FILE

RECEIVED
OCT 8 8 2012
Town of Bethlehem
Planning Board

CAPITAL ARCHITECTURE
86 REMSEN STREET
COHOES, NEW YORK 12047
867-4247 OFFICE, 861 7040 FAX, 253 1442 CELL
capitalarchitecture@yahoo.com



16 HANDLES

380 ROUTE 9W
GLENMONT, NY

SITE PLAN

SCALE:	AS NOTED	REVISIONS:
DATE:	20 OCTOBER 12	Δ 27 MARCH 12
DRAWN:	AJD	Δ
SHEET#		Δ
		Δ
		Δ

A2

