

AHARONIAN
& ASSOCIATES INC.
ARCHITECTS

6 Blackstone Valley Place
Suite 100
Lincoln, Rhode Island
0 2 8 6 5

T 401-333-5010
F 401-334-4057
WWW.ARCH-ENG.COM

TOWN OF BETHLEHEM APPROVAL AREA

NOT FOR CONSTRUCTION - NOT FOR CONSTRUCTION - NOT FOR CONSTRUCTION

KEY PLAN

REVISIONS

NUMBER	REMARKS	DATE

PRELIMINARY
NOT FOR CONSTRUCTION

PRELIMINARY

PROJECT TITLE


Cumberland Farms
777 Dedham Street, Canton, Massachusetts 02021

68 ROUTE 9W
(NYS RTE 9W & NYS RTE 32)
RECEIVED
AUG 28 2006
BETHLEHEM, NY

DRAWING TITLE
PROPOSED EXTERIOR LIGHTING PLAN

DATE SEPT. 14, 2005	PROJ. NO. 0509
DRAWN BY WAC	CHECKED BY CDA

DRAWING NUMBER
L1.1
SHEET: 4 OF 4

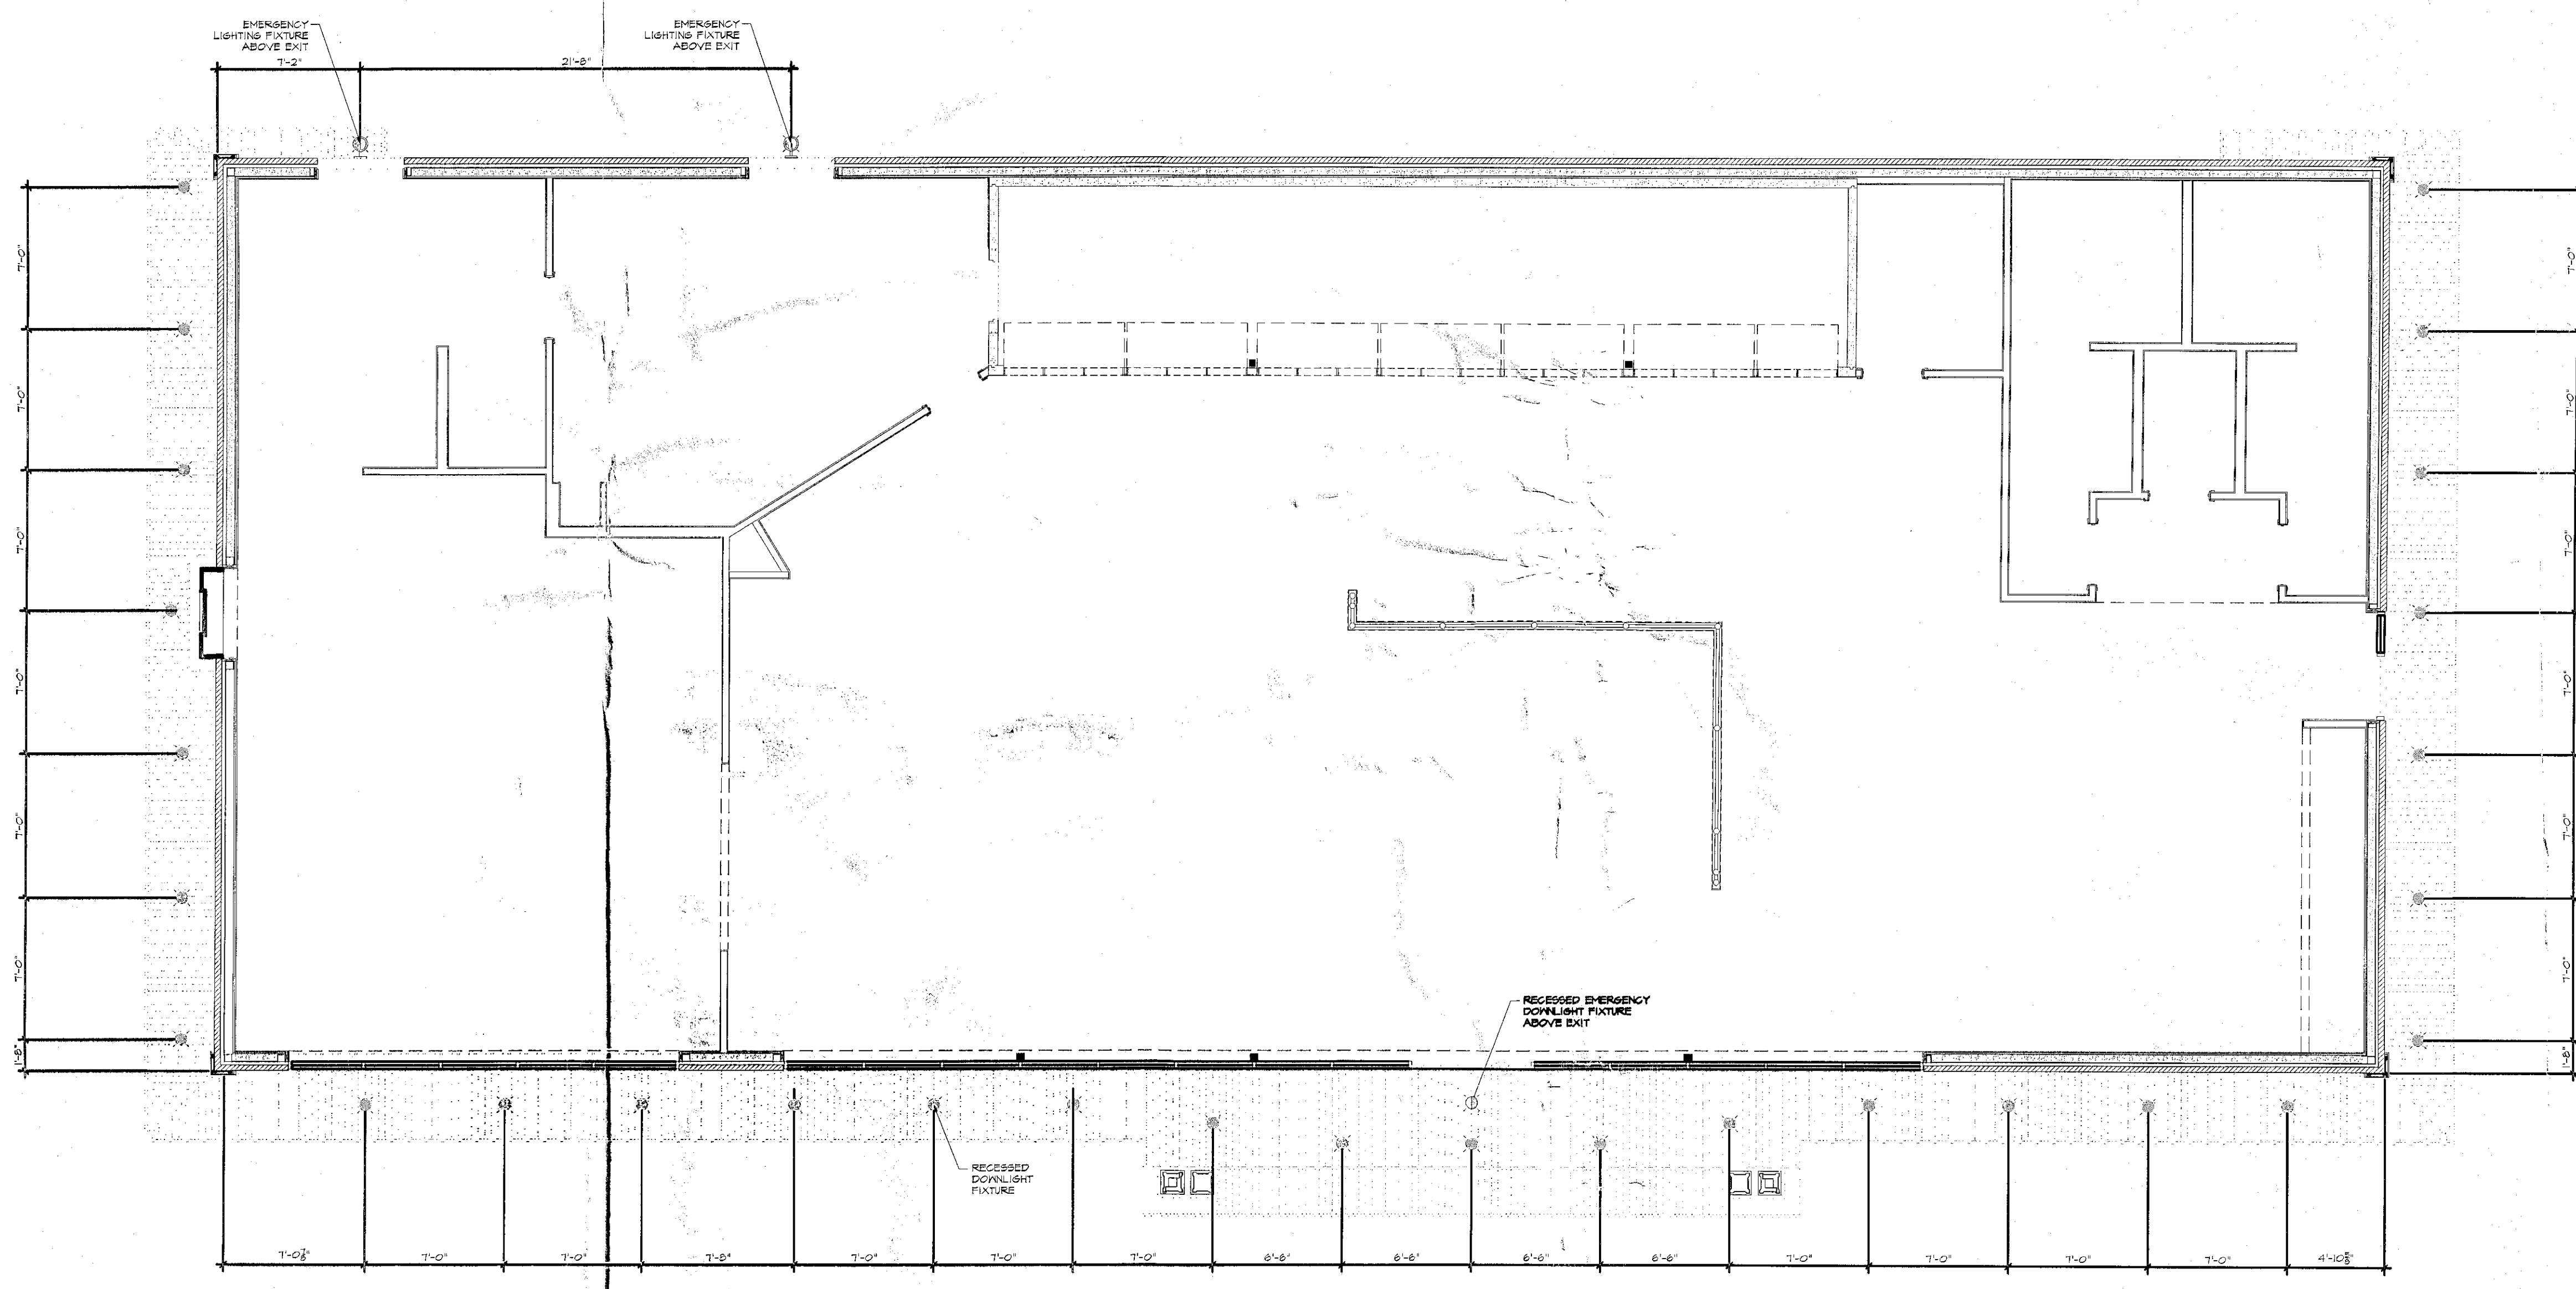

1 PROPOSED EXTERIOR LIGHTING PLAN
SCALE: 3/16"=1'-0"

INCHES
Town of Bethlehem, NY