



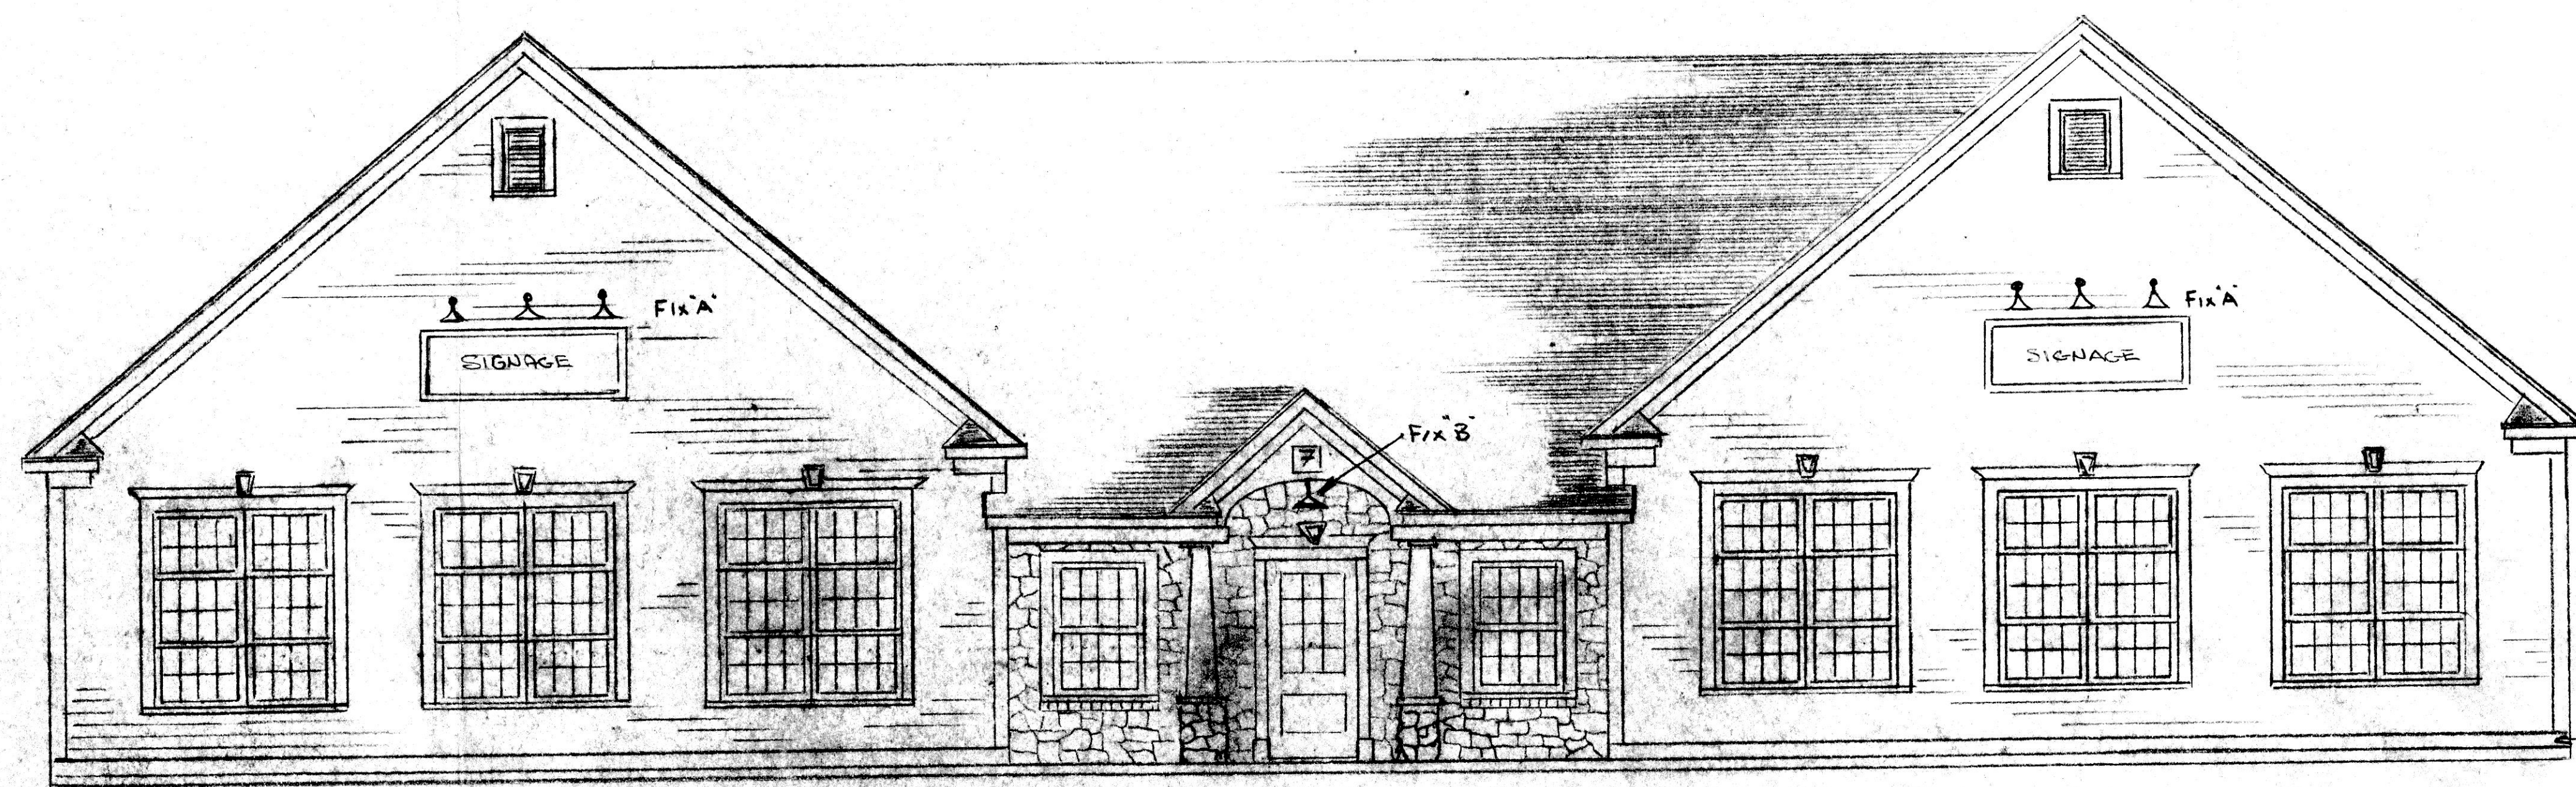


5/2 VINYL LINEAL
WATER TRIM BOARD

REAR ELEVATION (WEST)
1/4" = 1'-0"

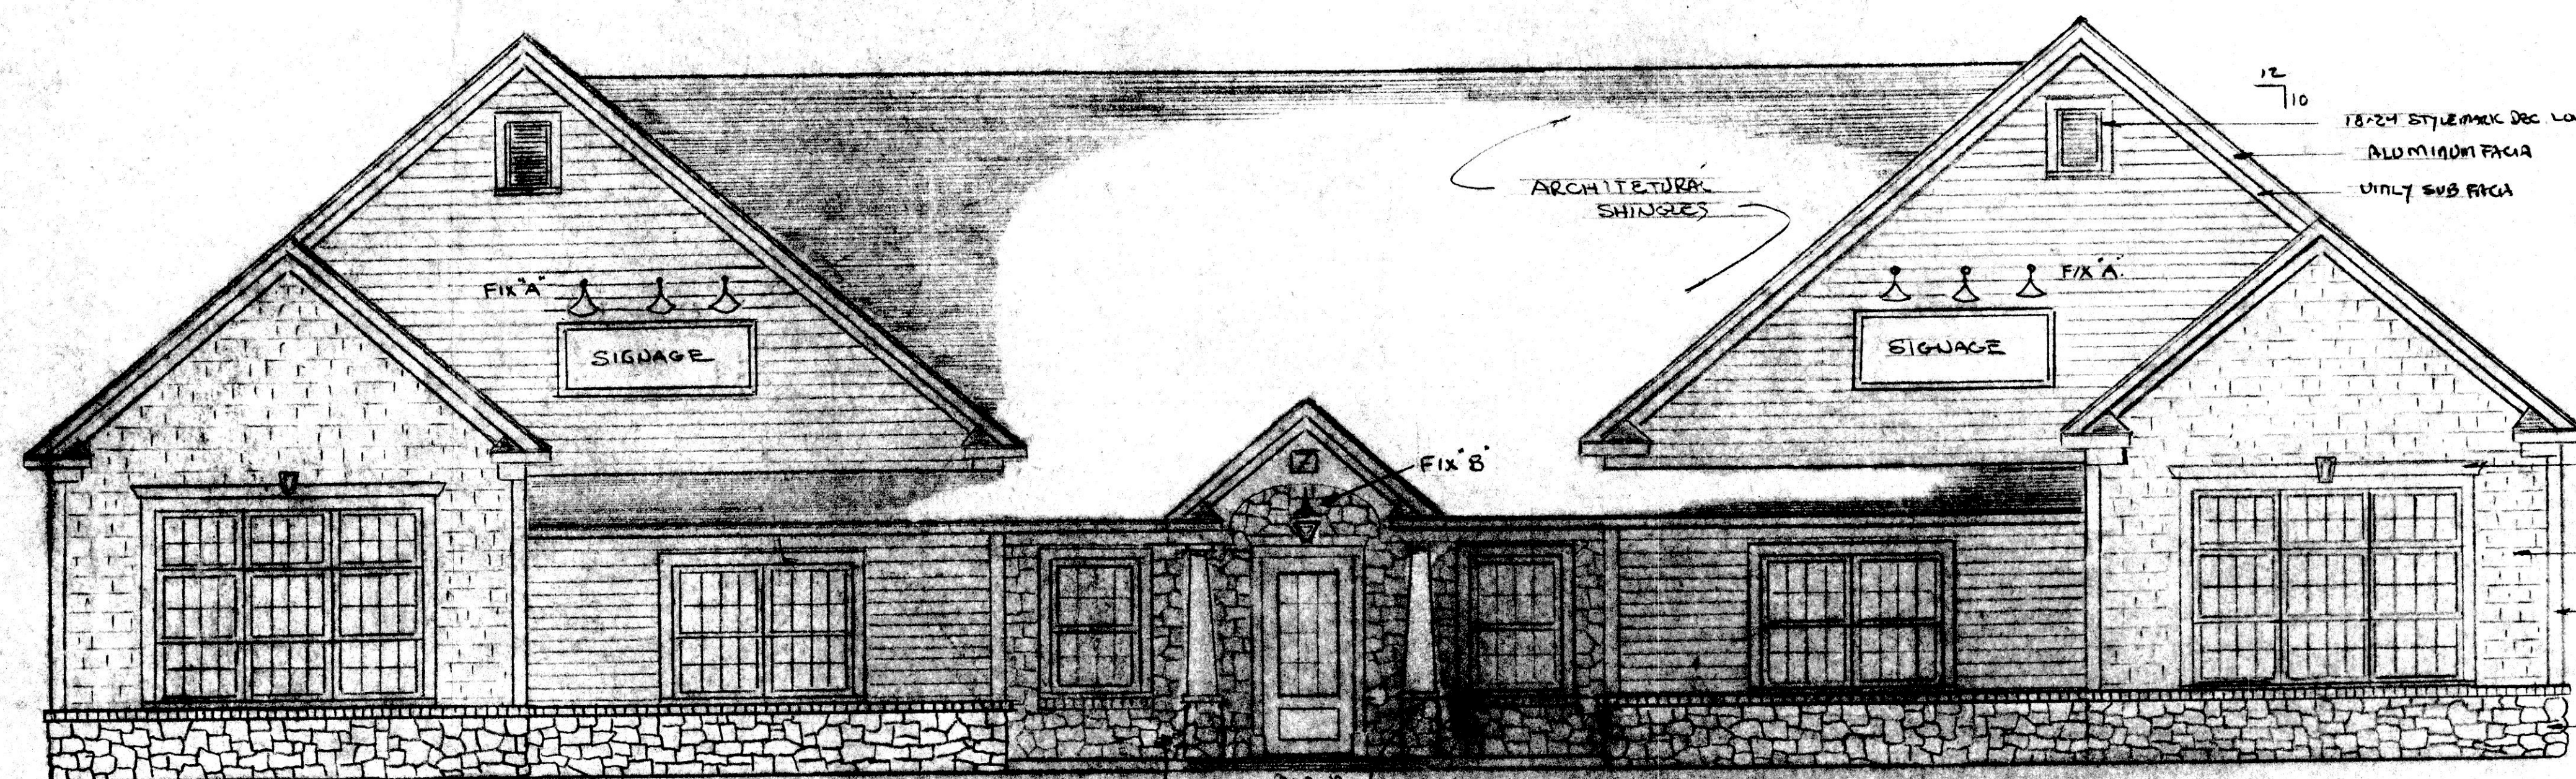

FRONT ELEVATION EAST
1/4" = 1'-0"

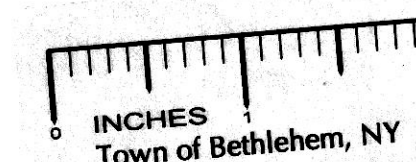

EXT. LIGHT FIXTURE SCHEDULE				
NO.	MANU.	MODEL	REMARKS	QTY
A	SITESCAPE	35241	VERDE COPPER	12
B	SITESCAPE	40241	VERDE COPPER	2
C	SITESCAPE	34041	VERDE COPPER	3

PLANNING BOARD
TOWN OF BETHLEHEM
ALBANY COUNTY, NEW YORK
This Site Plan Approved.
Paul A. Mott
Title: *Chairman*
SPA 130
Date: *6/1/07*

RECEIVED
JUN 18 2007
PLANNING BOARD
TOWN OF BETHLEHEM

KEYSTONE PROFESSIONAL CENTER 5 Elm Avenue DELMAR, NY	
SCALE: 1/4" = 1'-0"	APPROVED BY: <i>Paul A. Mott</i>
DATE: 5-26-06	REV: 11-20-06 REV: 3-10-07
KEYSTONE BUILDERS INC. 388 KENWOOD AVE DELMAR	
FRONT AND REAR ELEVATION	DRAWING NUMBER A-1 of 4