


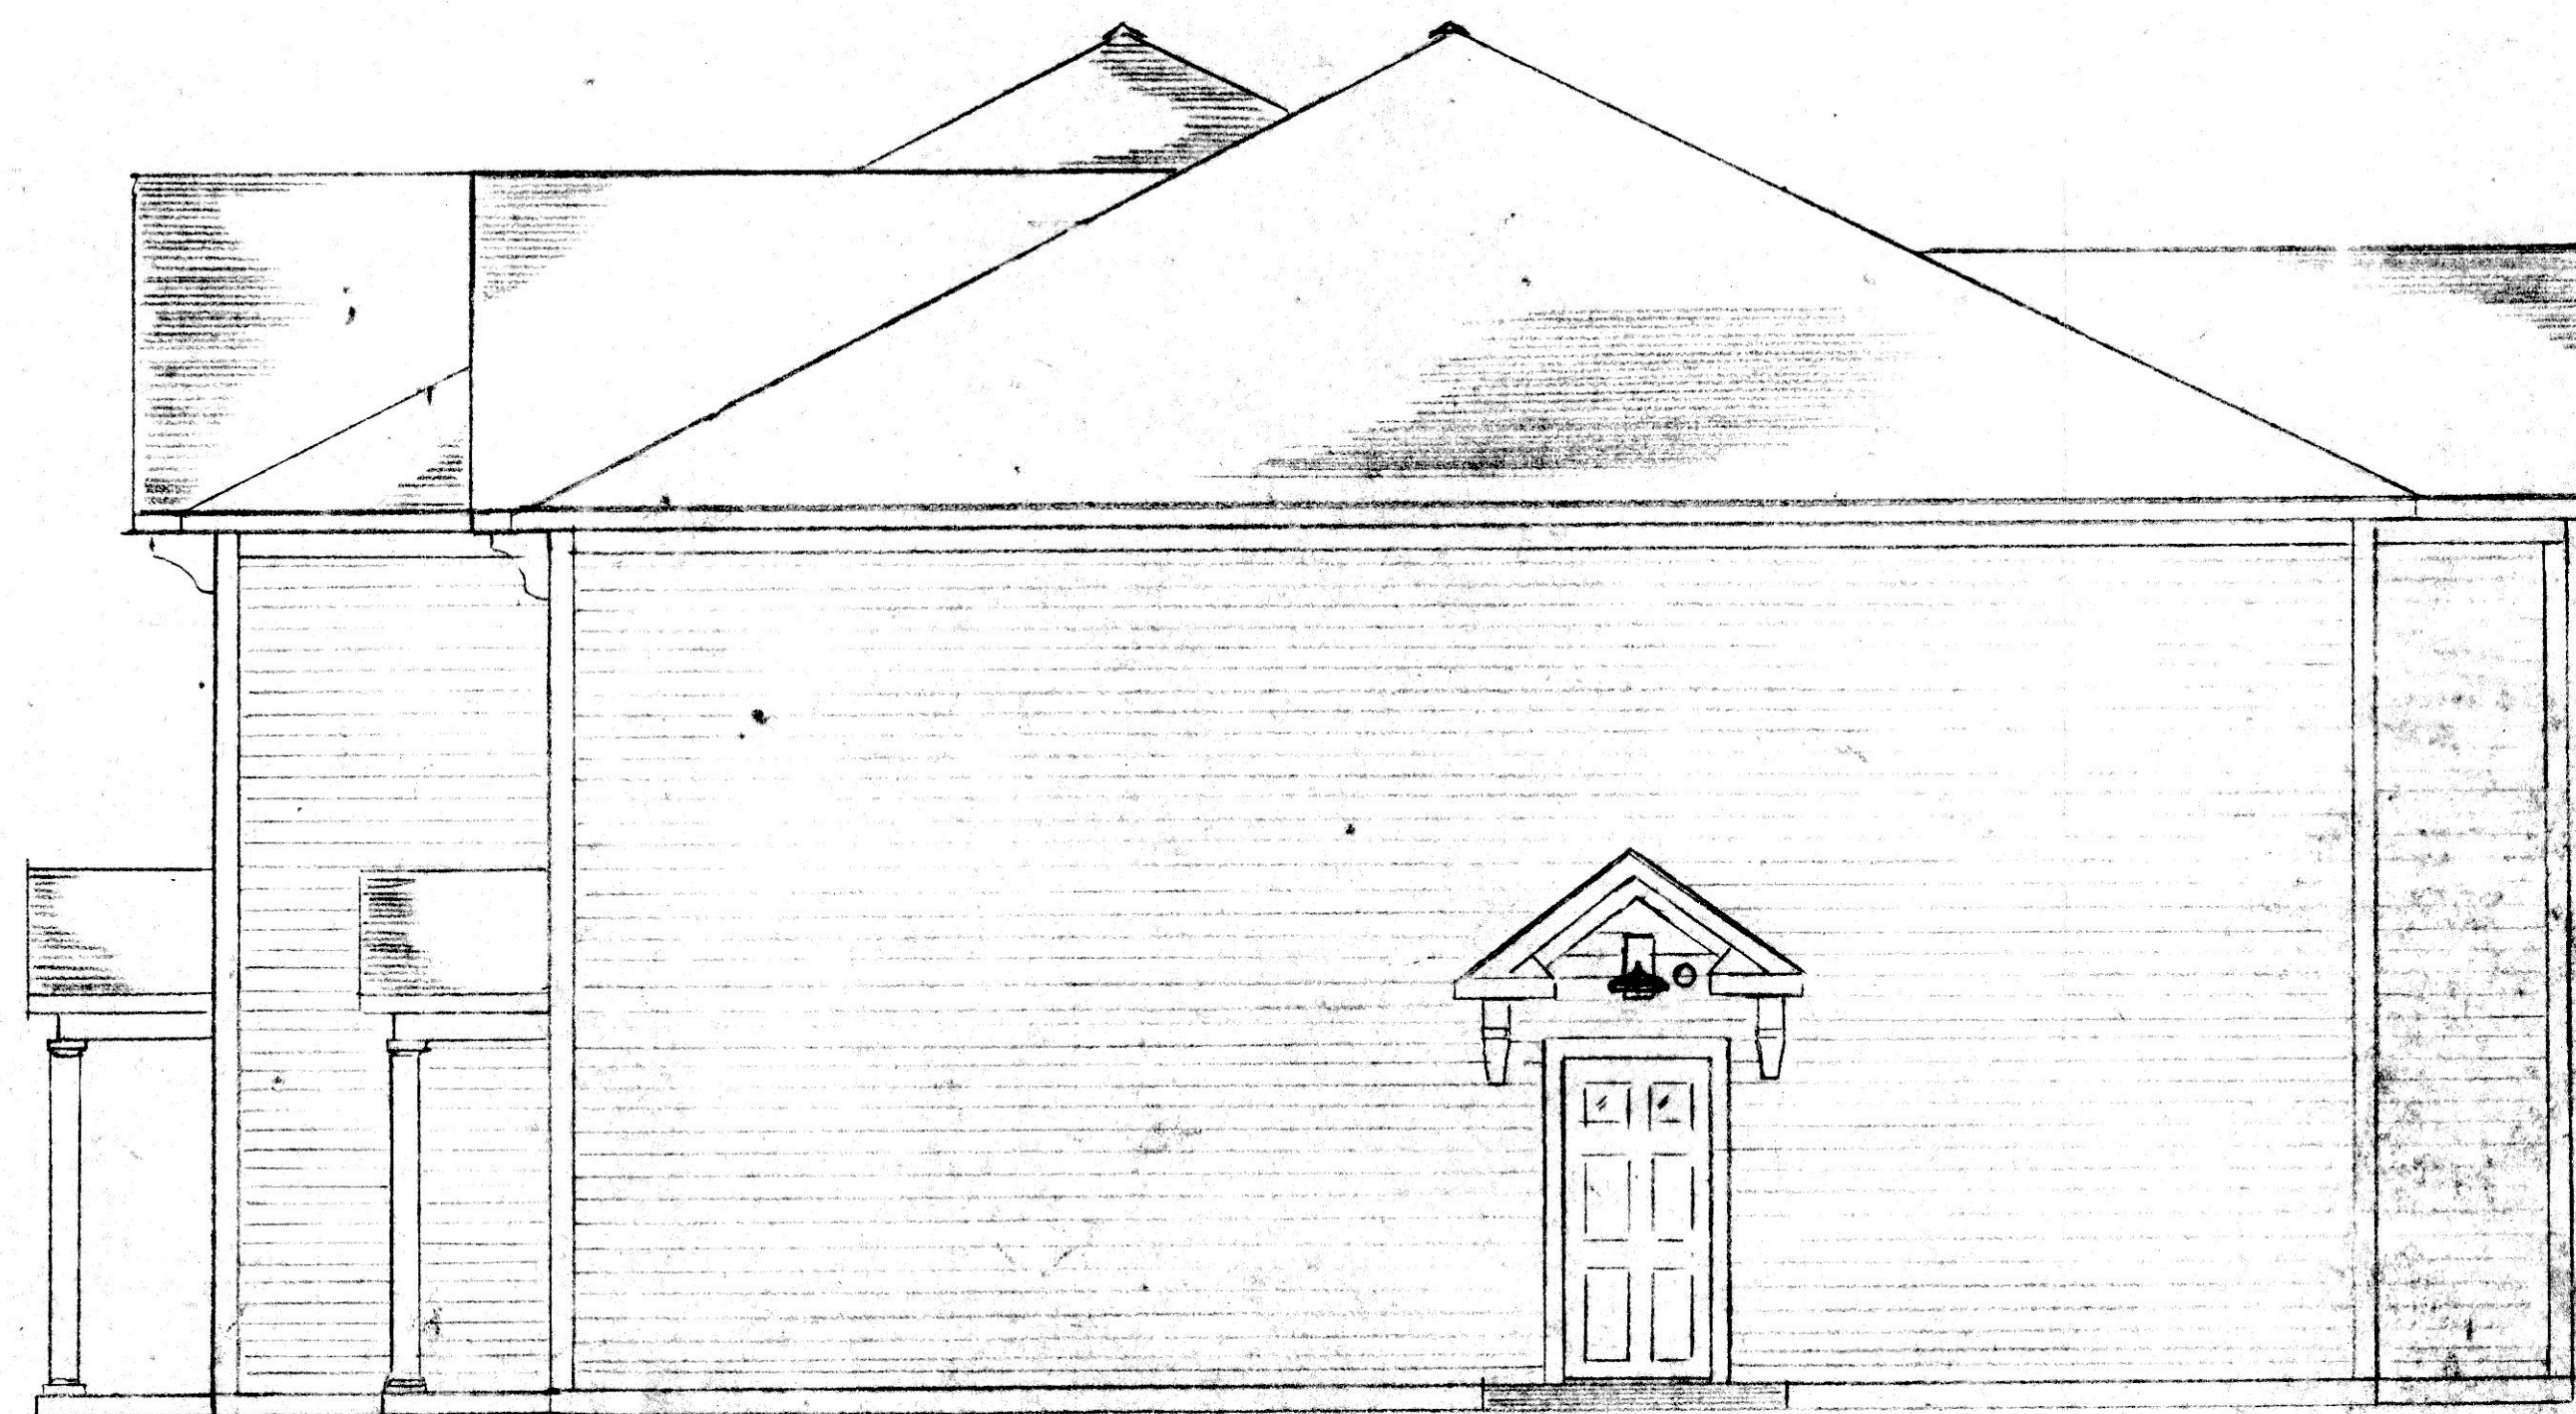

REAR ELEVATION (PARTIAL)
 1/4" = 1'-0"



NORTH SIDE ELEVATION (SOUTH MIRROR IMAGE)
 1/4" = 1'-0"



FRONT ELEVATION (EAST)
 1/4" = 1'-0"



INCHES
 Town of Bethlehem, NY

PLANNING BOARD
 TOWN OF BETHLEHEM
 ALBANY COUNTY, NEW YORK
 This Site-Plan Approved.
 Title *Champion*
 Date *6/18/07*

EXTERIOR LIGHT FIXTURE SCHEDULE			
MT.	MAKE	MODEL	REMARKS
X	STRESCAPE	no. 241	JADE COPPER 4
O	SITESCACE	no. 34241	JADE COPPER 4

RECEIVED
 JUN 18 2007
 PLANNING BOARD
 TOWN OF BETHLEHEM

KEYSTONE APARTMENTS 7-9 ELM AVE DELMAR NY			
SCALE: 1/4" = 1'-0"	APPROVED BY	DRAWN BY	
DATE: 5-24-06	REV: 11-30-06	REV: 3-10-07	SWB
KEYSTONE BUILDERS INC 388 KENWOOD AVE DELMAR NY			
ELEVATIONS			DRAWING NUMBER A-144