


1

TREE PLANTING DETAIL


SCALE: N.T.S.

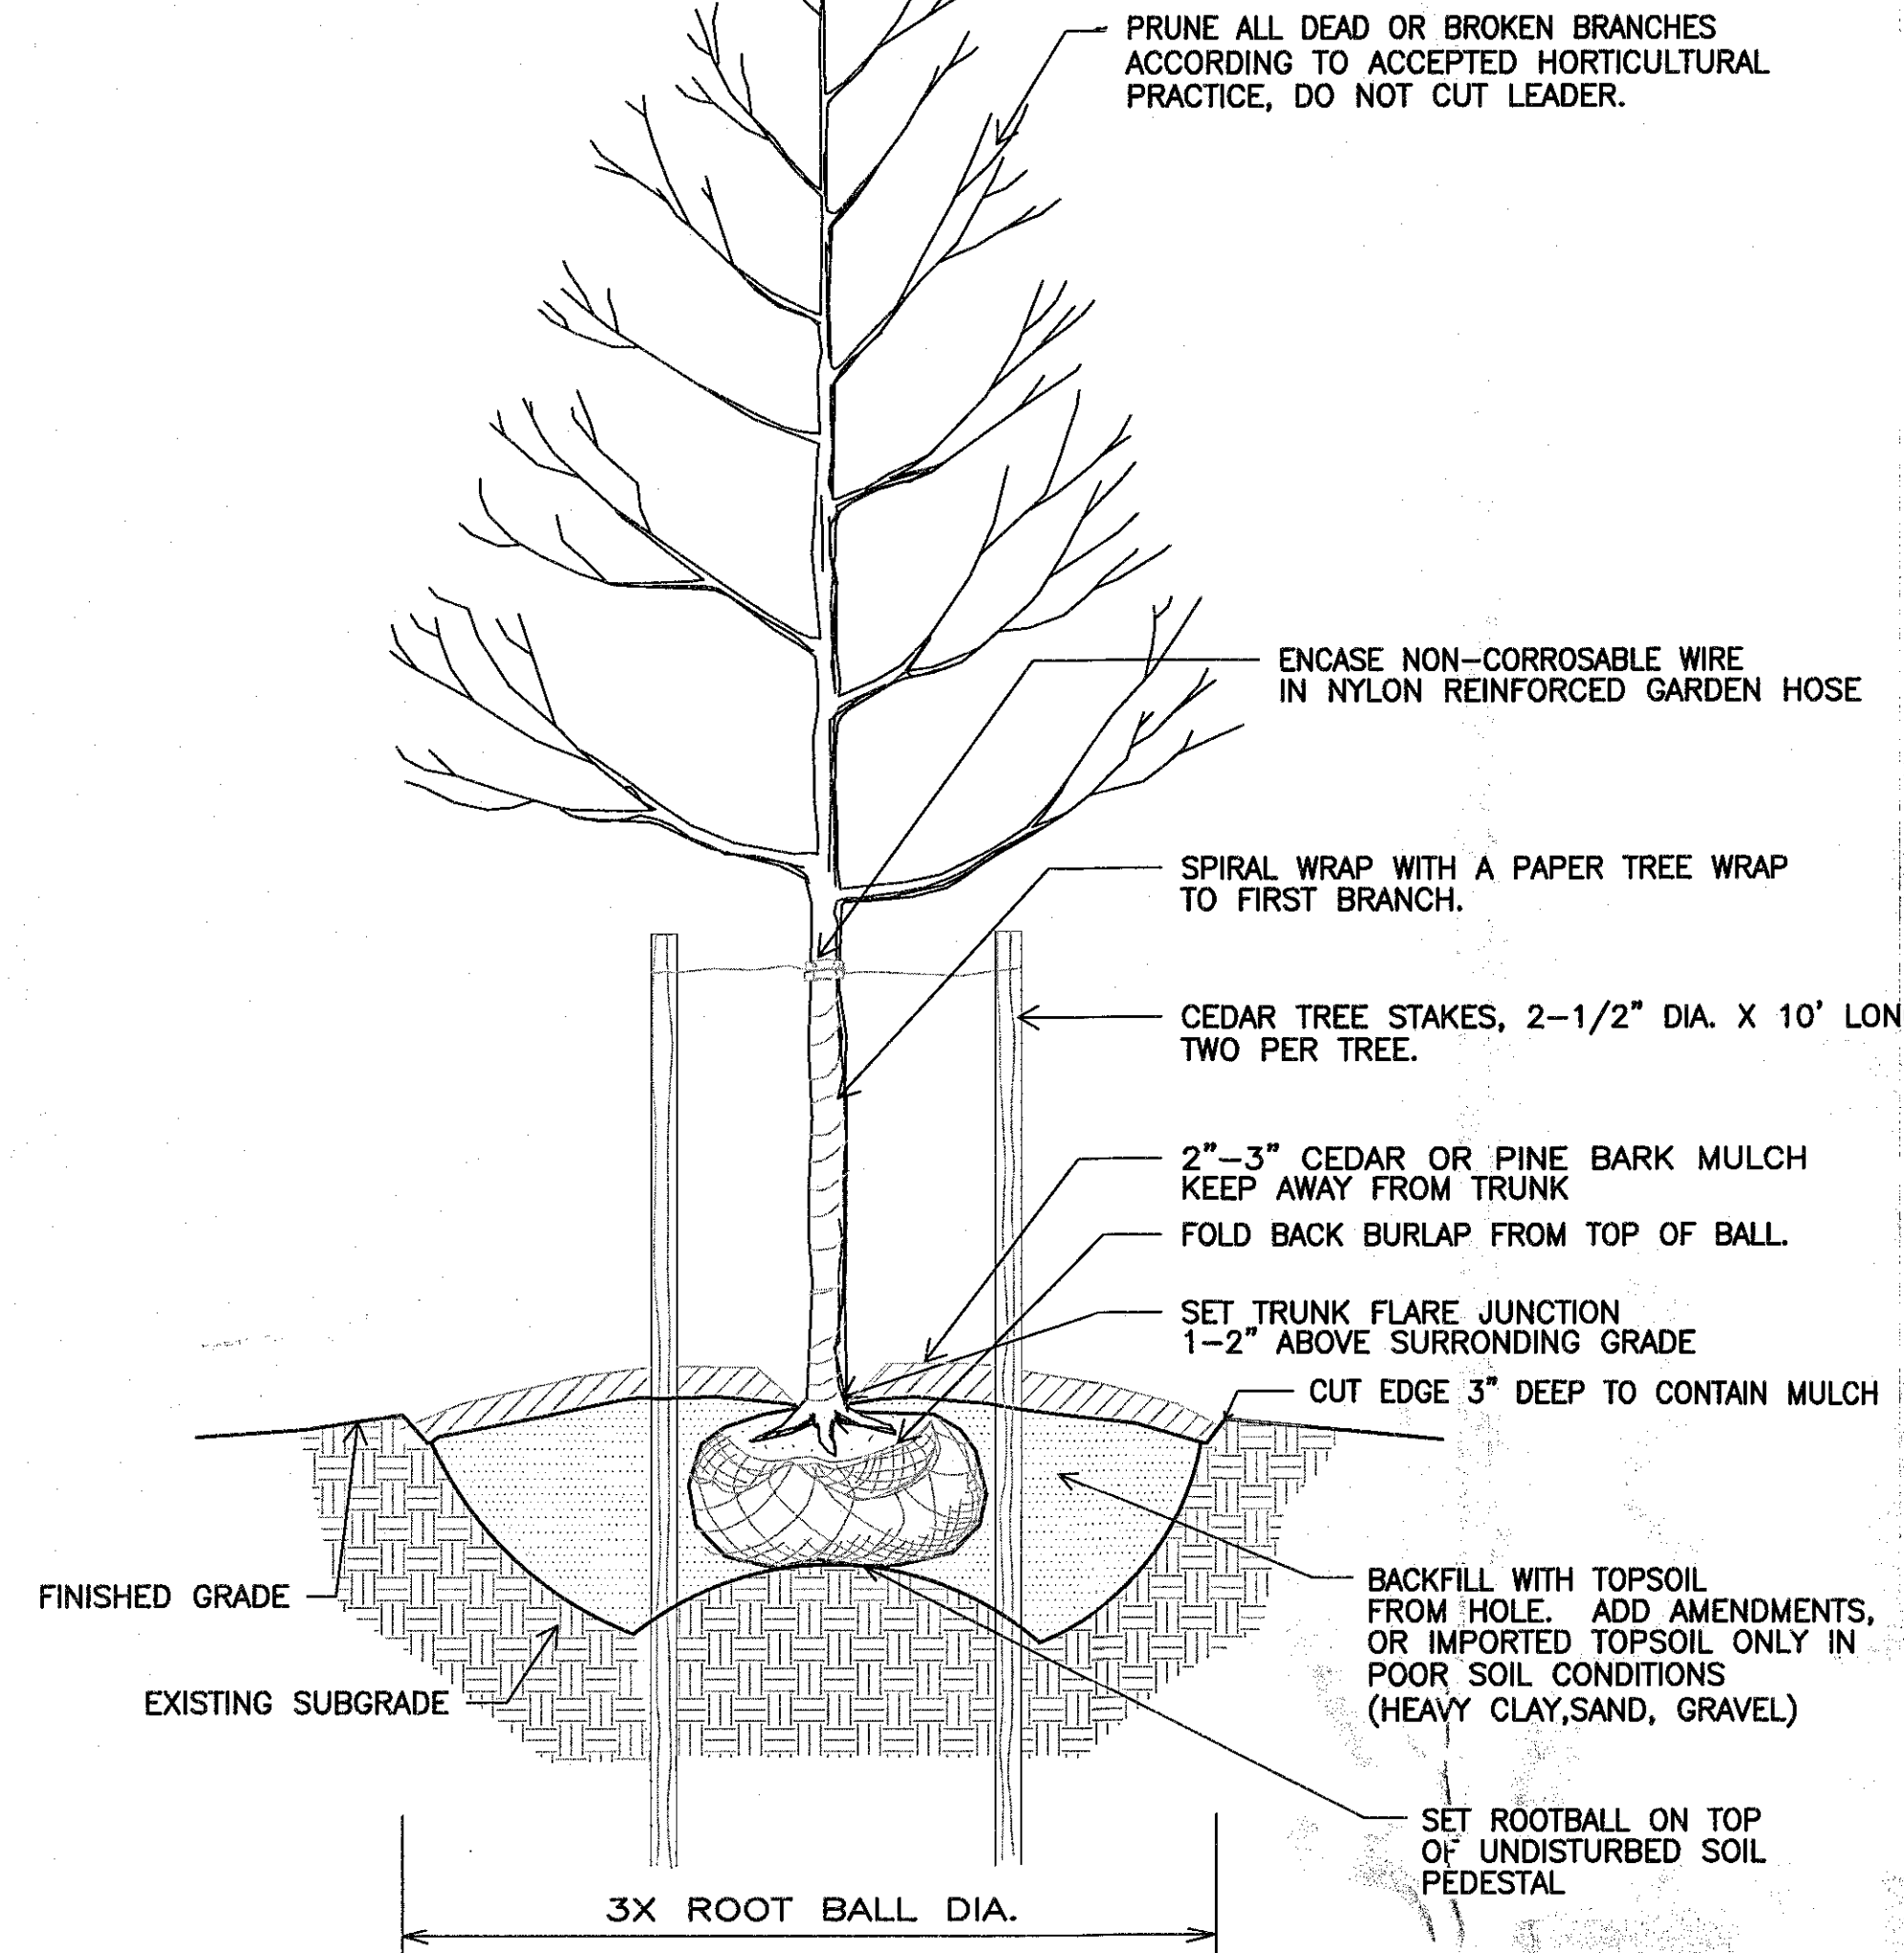

2

SHRUB PLANTING DETAIL


SCALE: N.T.S.

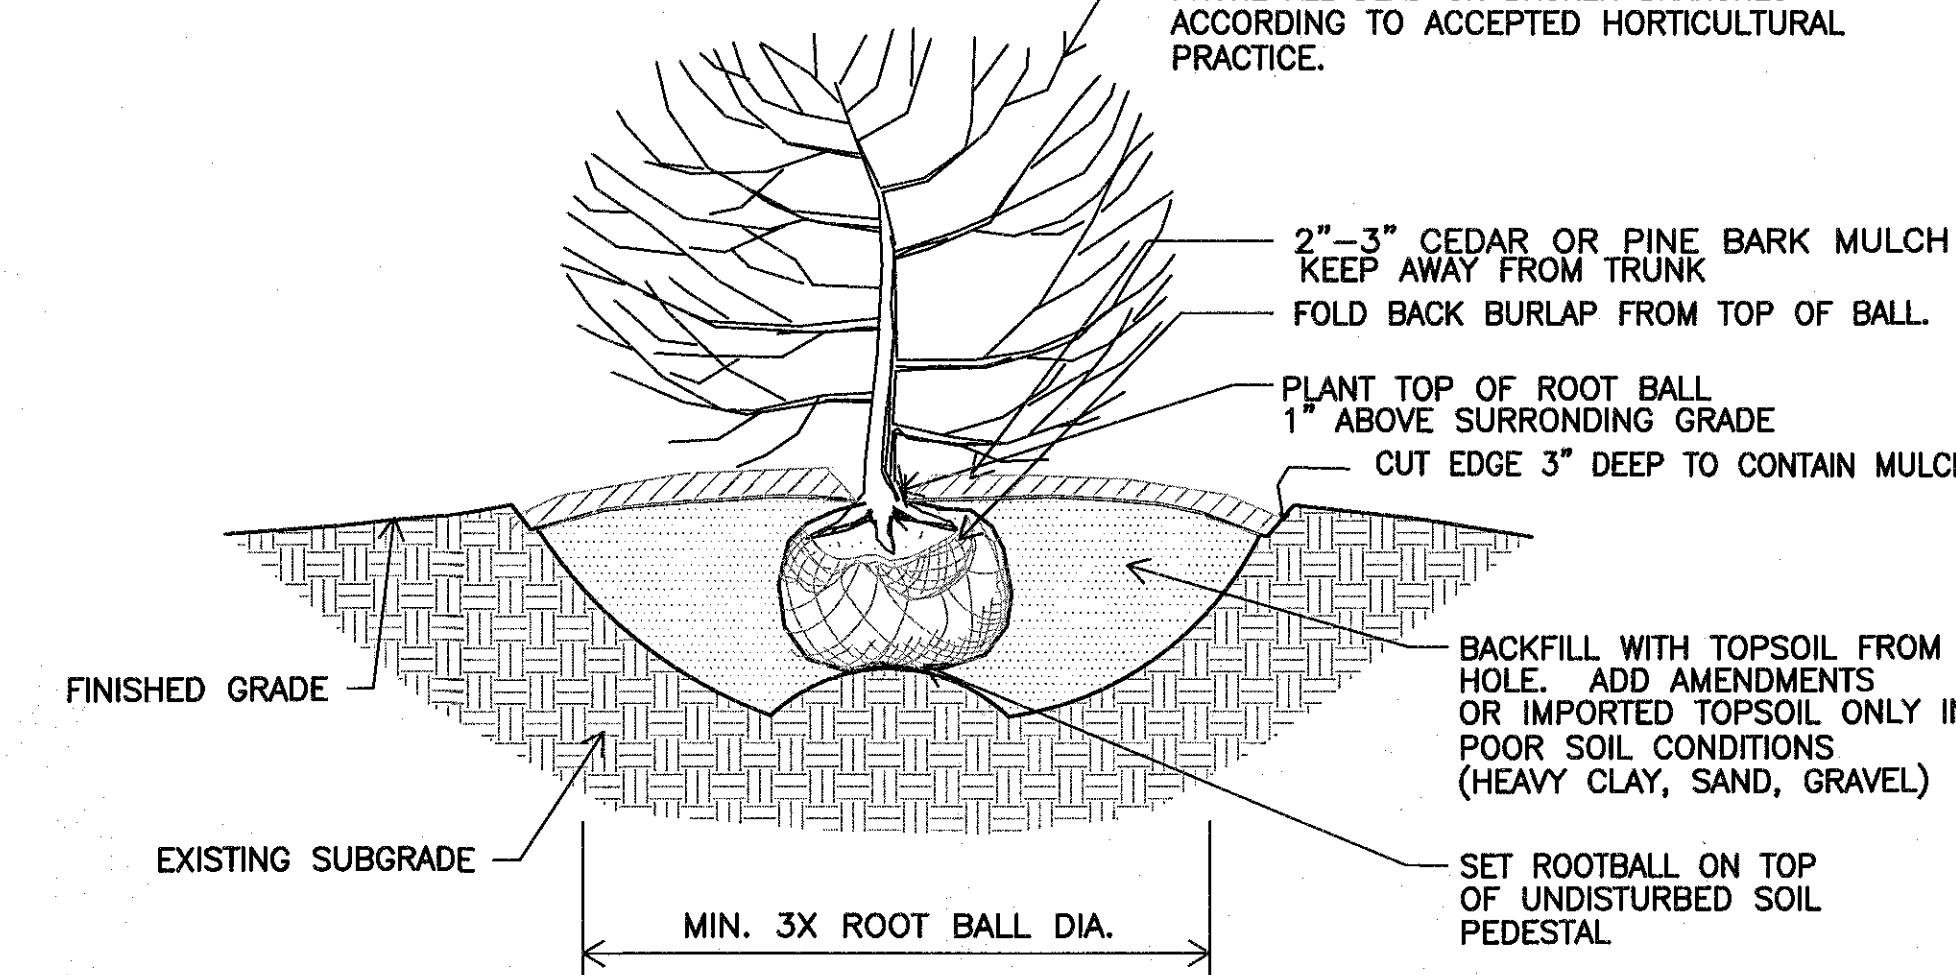

3

PERENNIAL PLANTING DETAIL


SCALE: N.T.S.

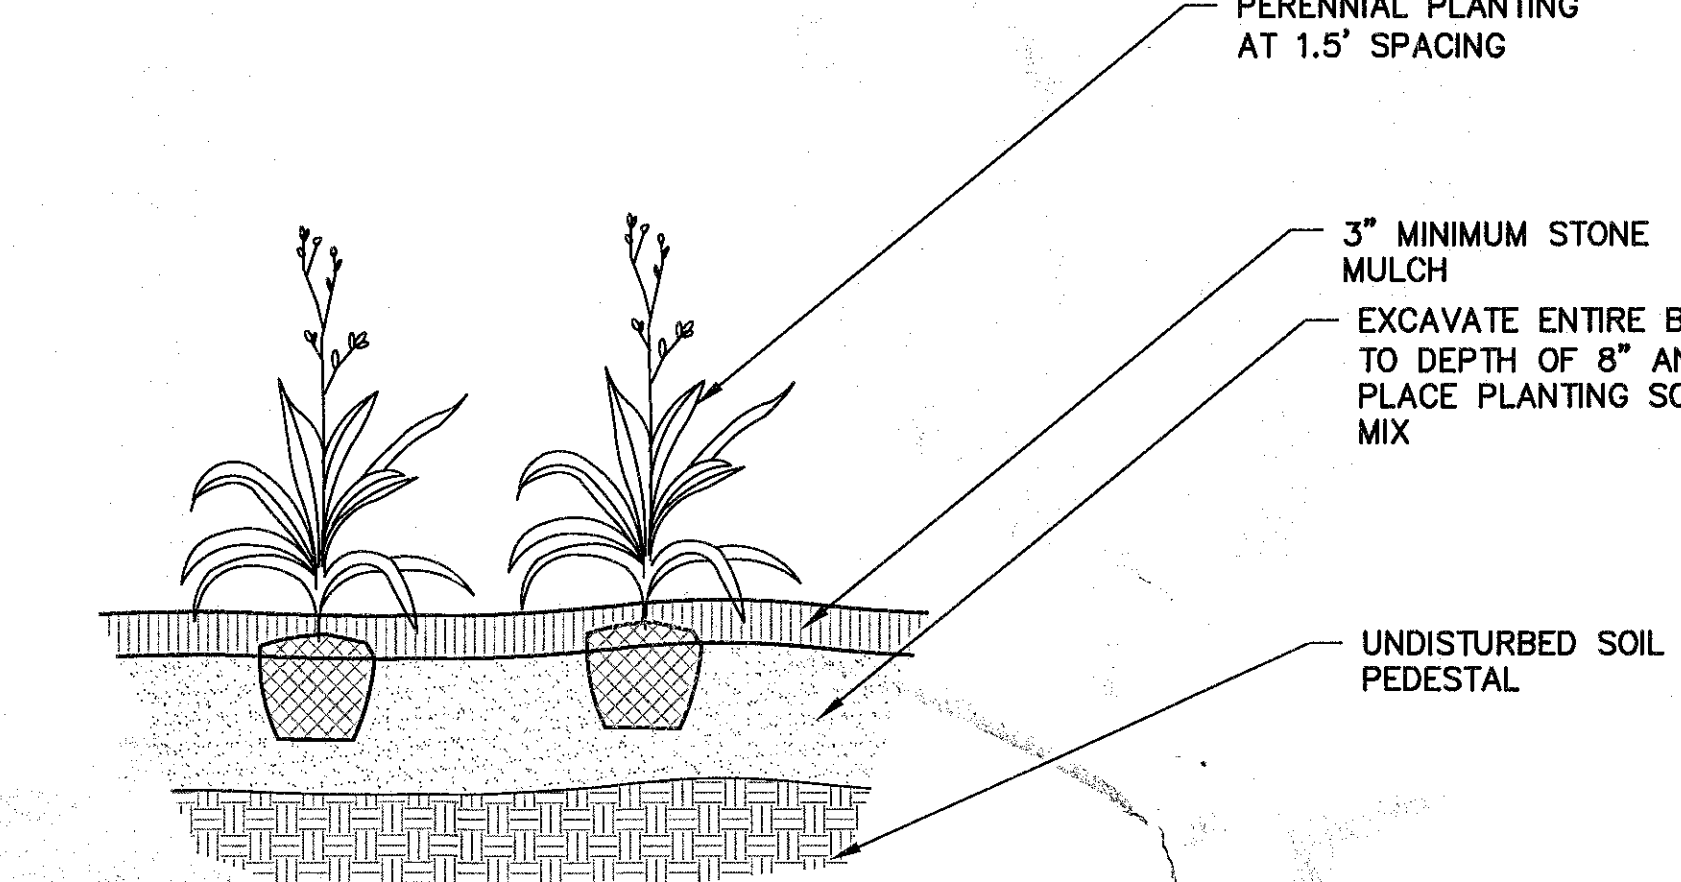

4

MULTI-STEMMED TREE PLANTING DETAIL


SCALE: N.T.S.

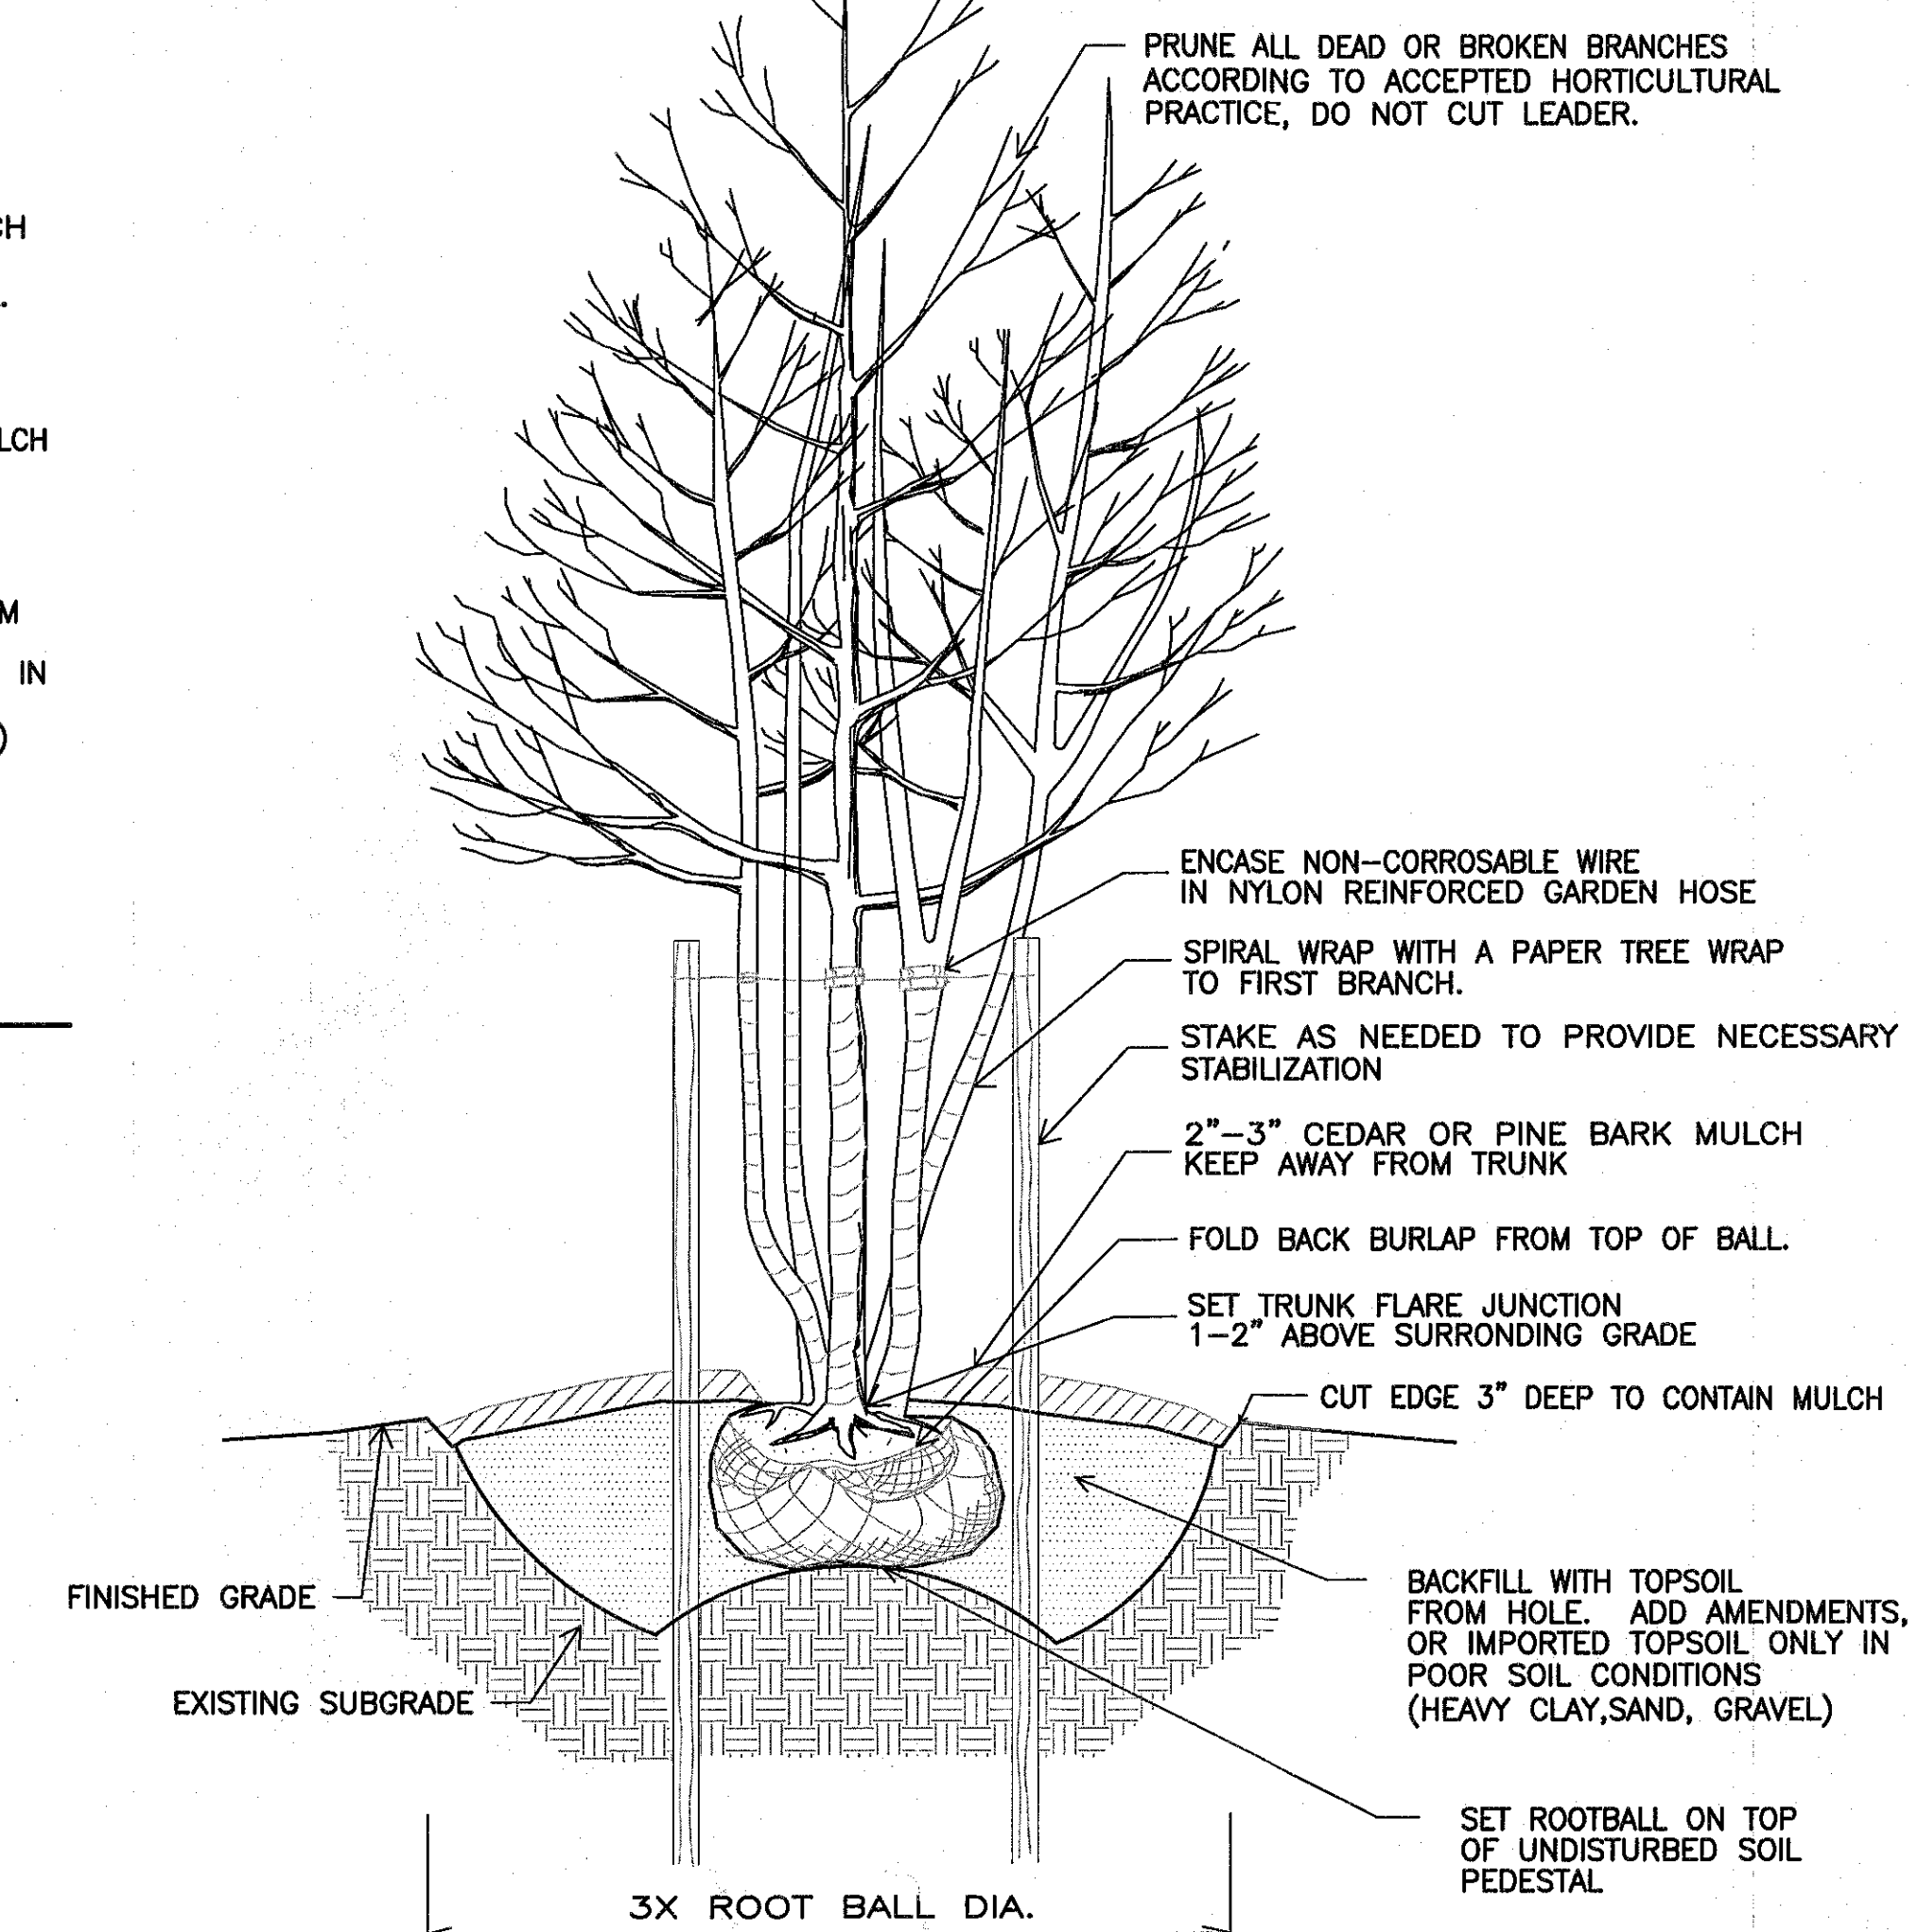

5

LIGHT POLE LUMINAIRE DETAIL

SCALE: N.T.S.

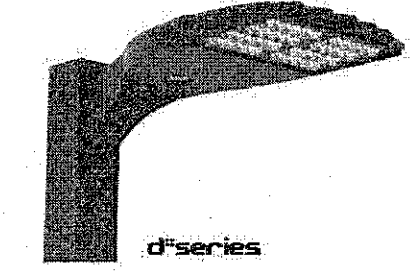

**D-Series
Size 0
LED Area Luminaire**

Specifications

EPA: 0.75 W/ft
Length: 26" (660mm)
Width: 9.5" (241mm)
Height: 9" (229mm)
Weight (max): 15 lbs (6.8kg)

Introduction

The modern styling of the D-Series featuring yet another innovative - making a bold, progressive statement even as it blends seamlessly with its environment.

The D-Series challenges the benefits of the latest in LED technology into a high performance, high efficacy, long-life luminaire. The outstanding photometric performance results in sites with excellent uniformity, greater pole spacing and lower power density. It is ideal for replacing up to 400W metal halide with typical energy savings of 65% and expected service life of over 100,000 hours.

Ordering Information

EXAMPLE: DSX0 LED 40C 1000 40K T3M MVOLT SPA DOBXD

DSX0 LED	DSX0 LED	DSX0 LED	DSX0 LED	DSX0 LED	DSX0 LED	DSX0 LED	DSX0 LED	DSX0 LED	DSX0 LED
DSX0 LED	DSX0 LED	DSX0 LED	DSX0 LED	DSX0 LED	DSX0 LED	DSX0 LED	DSX0 LED	DSX0 LED	DSX0 LED


Controls & Shields

DSX0 LED	DSX0 LED	DSX0 LED	DSX0 LED	DSX0 LED	DSX0 LED	DSX0 LED	DSX0 LED	DSX0 LED	DSX0 LED
DSX0 LED	DSX0 LED	DSX0 LED	DSX0 LED	DSX0 LED	DSX0 LED	DSX0 LED	DSX0 LED	DSX0 LED	DSX0 LED

6

PARKING LAYOUT DETAIL


SCALE: N.T.S.

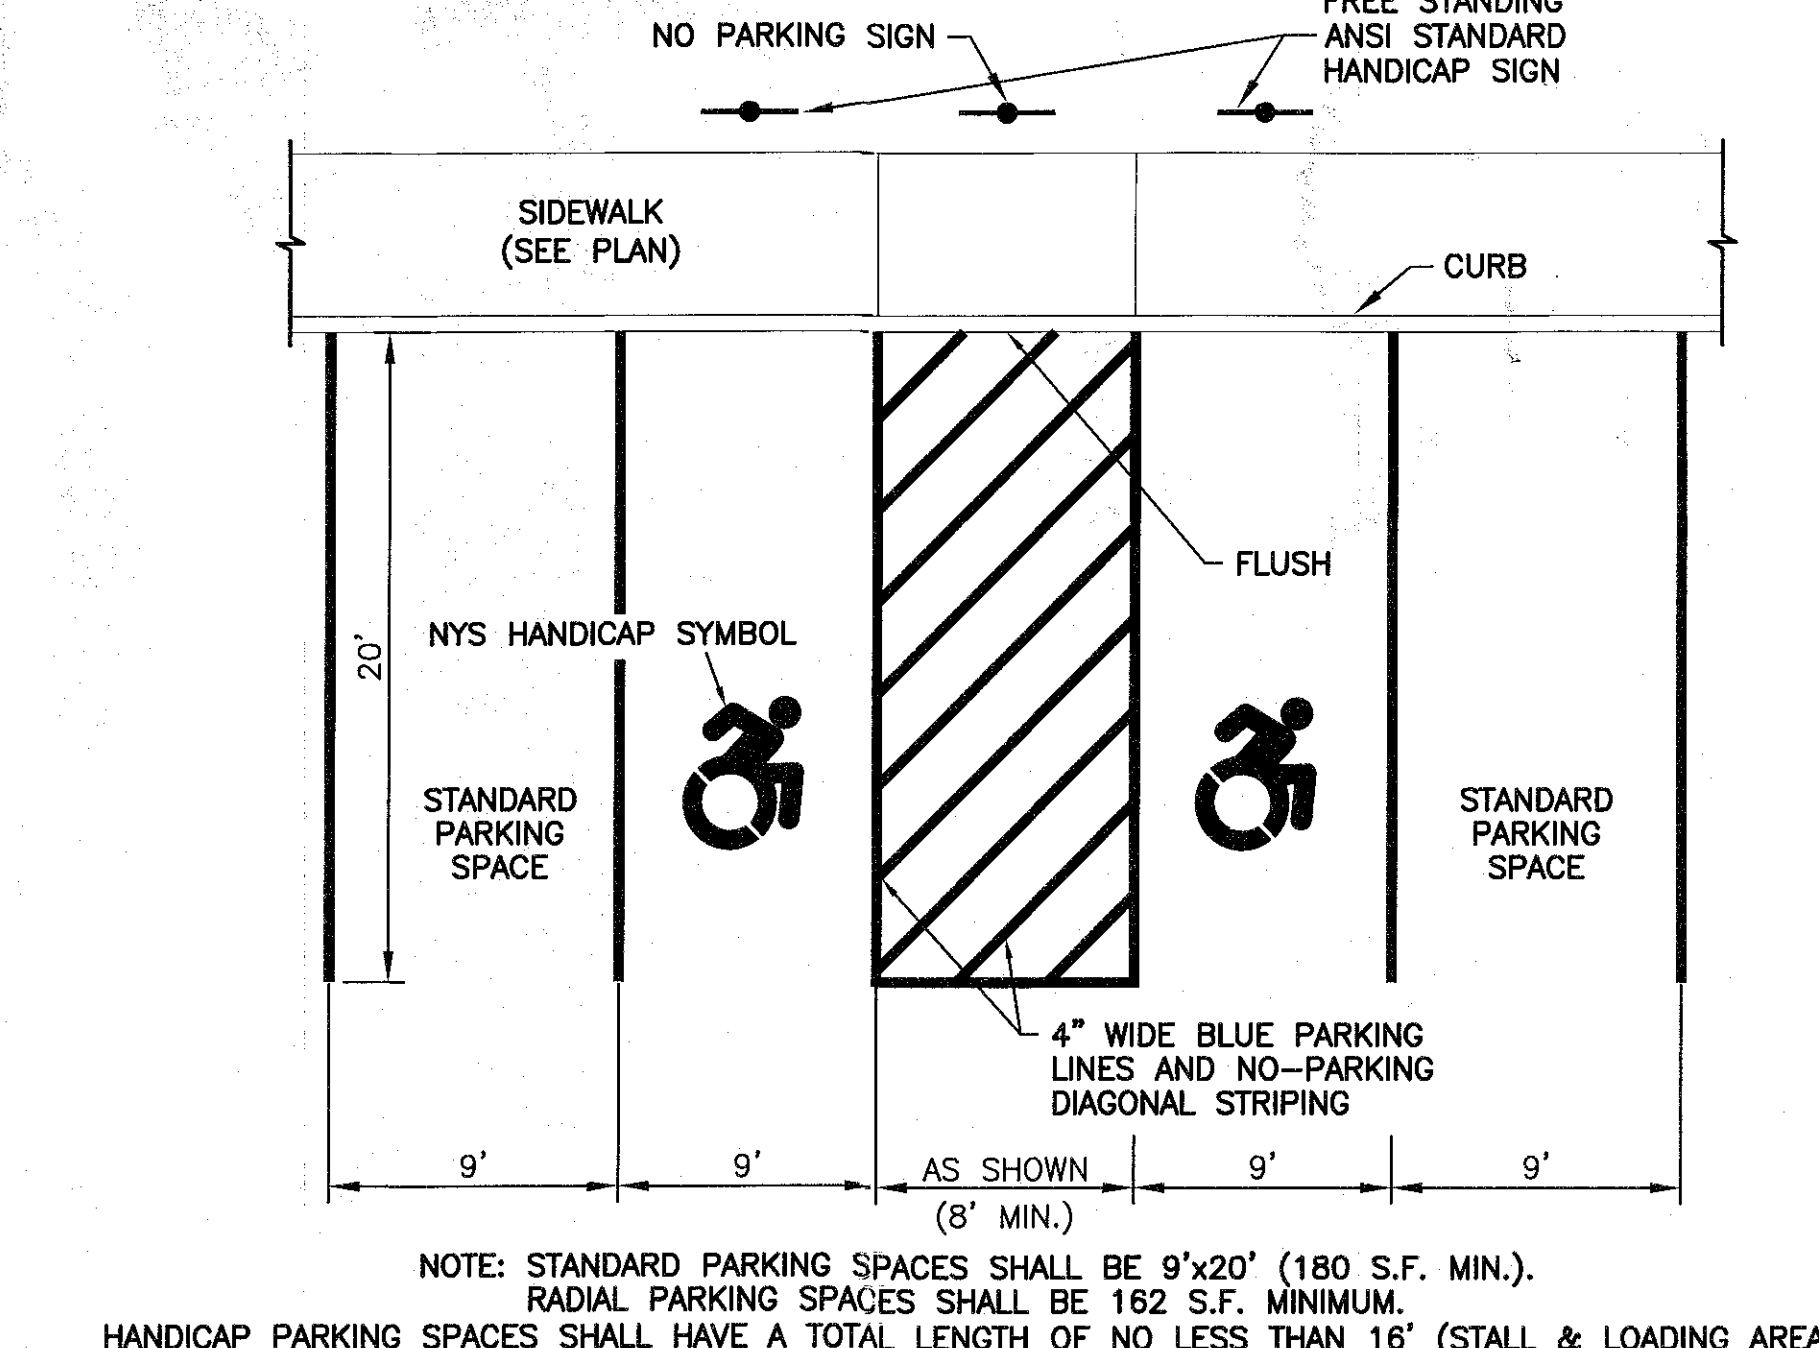

7

LIGHT POLE BASE


SCALE: N.T.S.

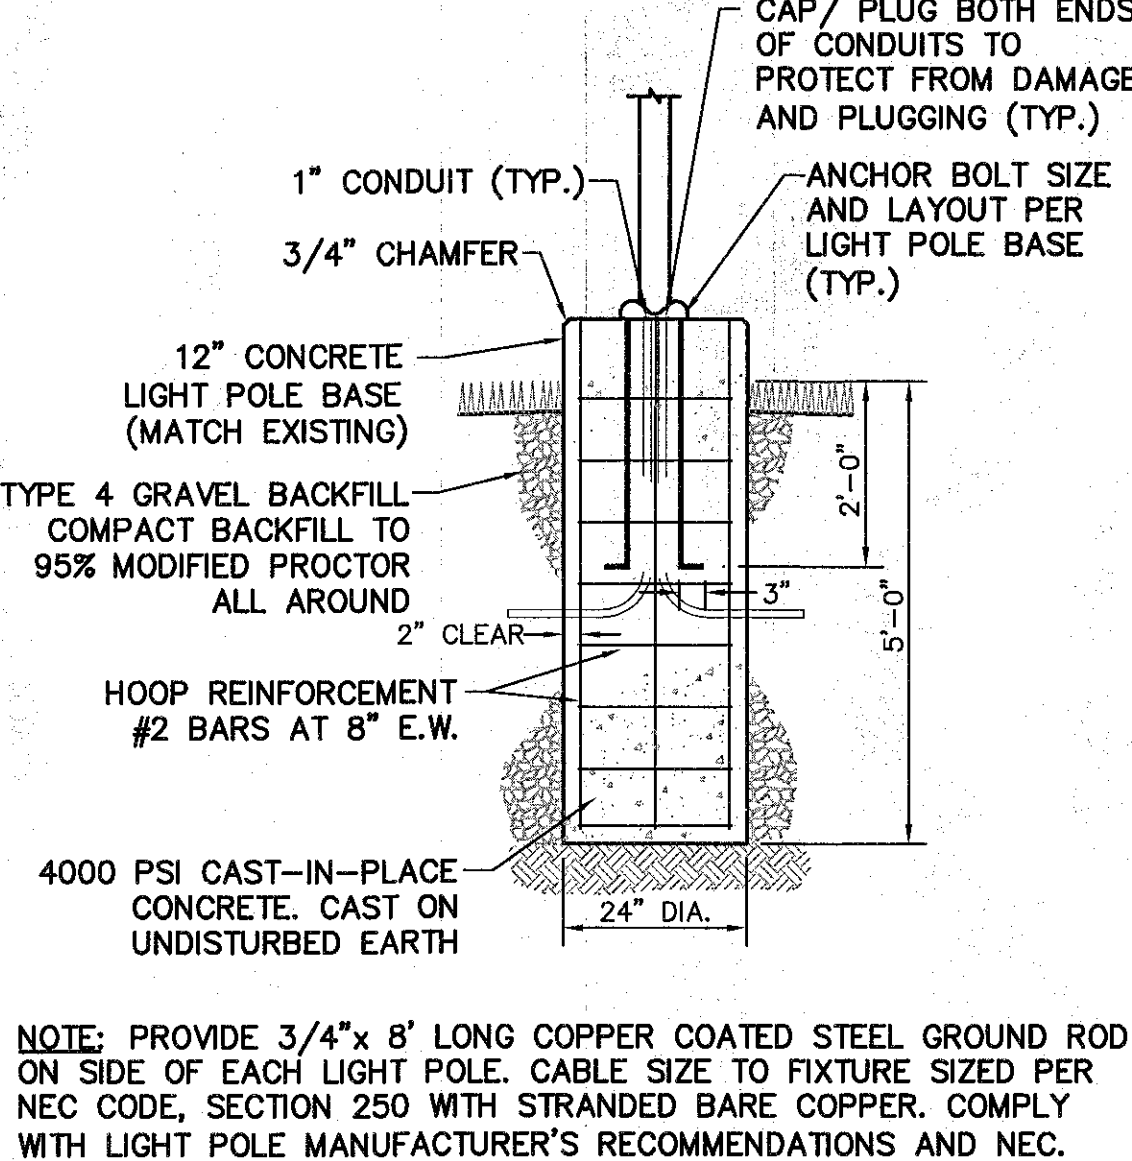

8

CURB RAMP DETAIL

SCALE: N.T.S.

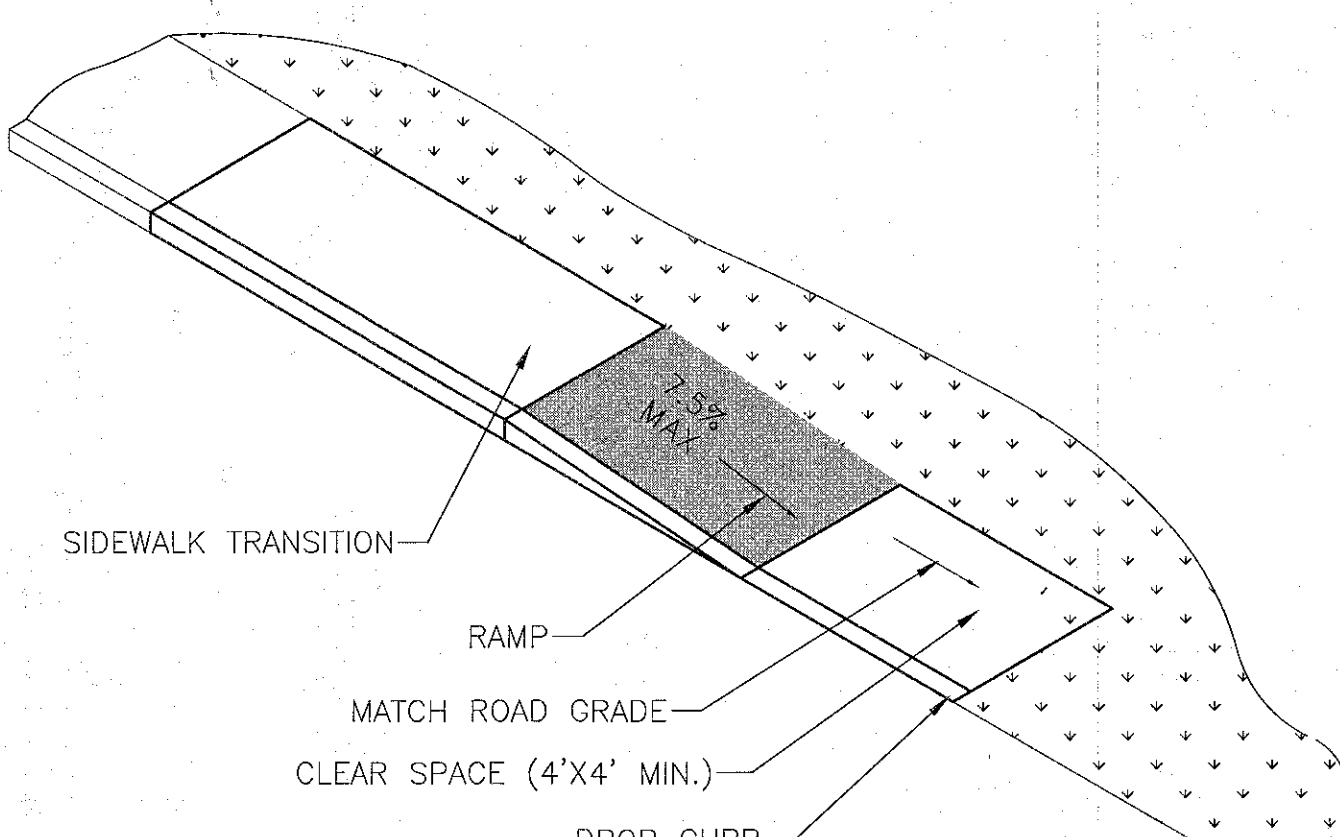

PLANNING BOARD APPROVAL

PLANNING BOARD
TOWN OF BETHELEHEM
ALBANY COUNTY, NEW YORK
By direction of the Chairman.
These drawings are hereby approved.
See sheet(s) 2 of 10
for date and signature.

TOWN OF BETHELEHEM, NEW YORK
PLANNING DEPT. ORIGINAL
- SCANNED -
0 1 2
INCHES

Weston & Sampson

1 Winner's Circle, S 130, Albany, NY
518.483.4400
www.westonandsampson.com

REVISIONS PER PLANNING BOARD / TDE COMMENTS

No.	Date	Description	App. By	Rev.	By	Date
1	02/09/17	JWG	DPB	DPB	DPB	DPB
2	03/30/17	JWG	DPB	DPB	DPB	DPB
3	04/05/17	RAM	DPB	DPB	DPB	DPB

REGISTERED PROFESSIONAL

Daniel P. Biggs

DATE: DECEMBER 1, 2016

CONSTRUCTION DETAILS

SITE PLAN AMENDMENT - CAPCOM FCU - PARKING LOT EXPANSION
384 BENDER LANE, GLENMONT, TOWN OF BETHELEHEM, COUNTY OF ALBANY, STATE OF NEW YORK

SCALE: AS NOTED

CONTRACT: N2160071

JOB NO. N2160071

DR BY JWG

CHK BY DPB

APP BY DPB

C503

SHEET 9 OF 10