




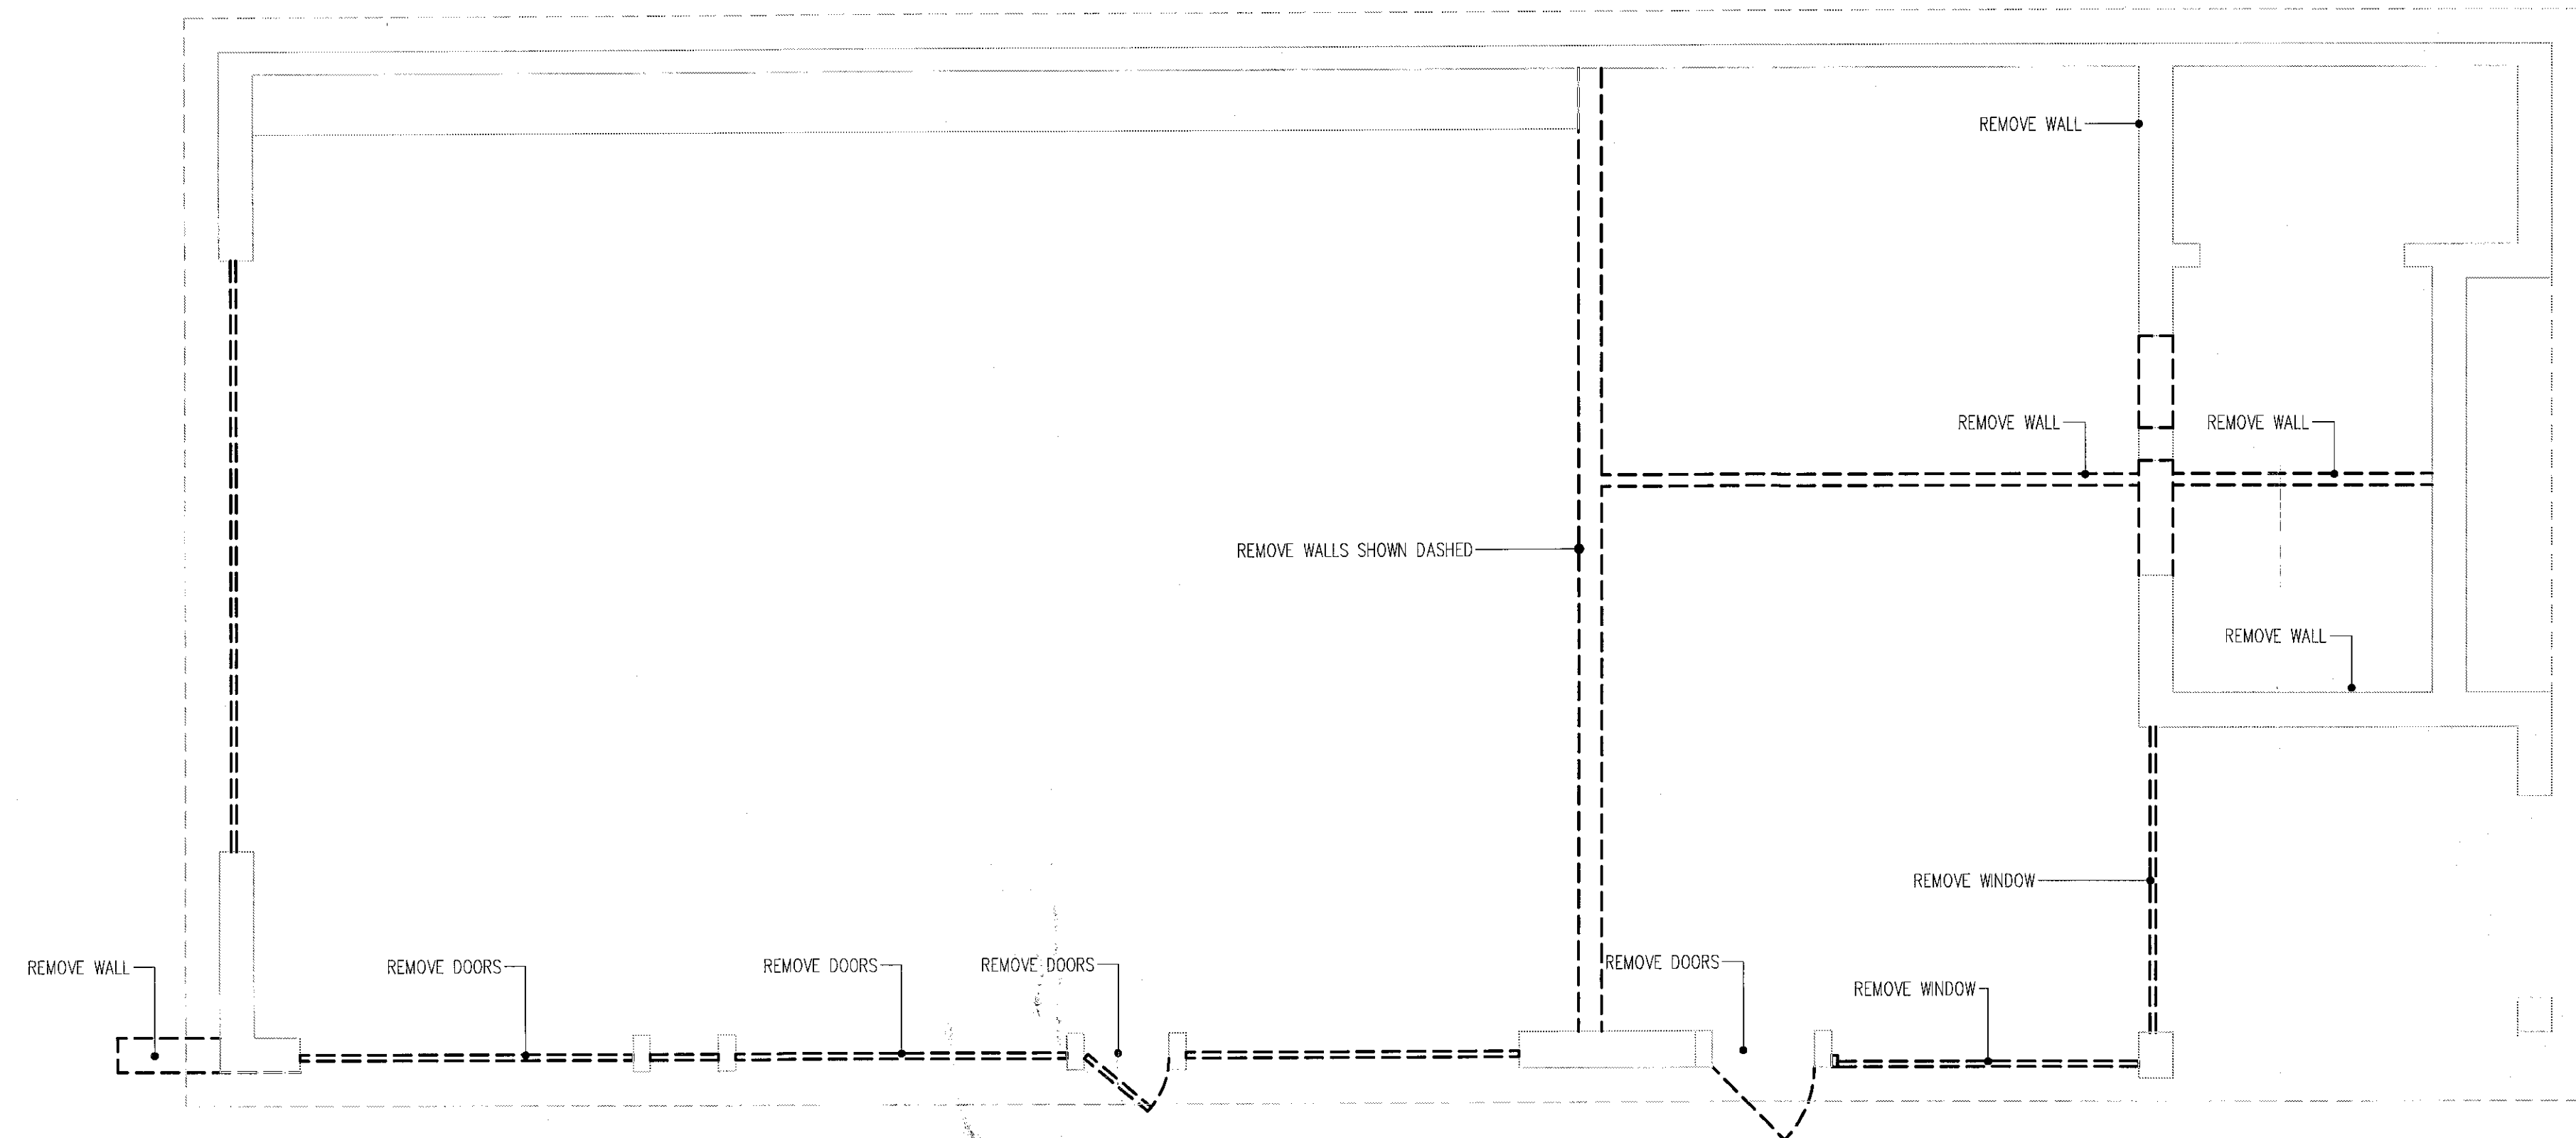

1 REMOVAL PLAN
1/4" = 1'-0"

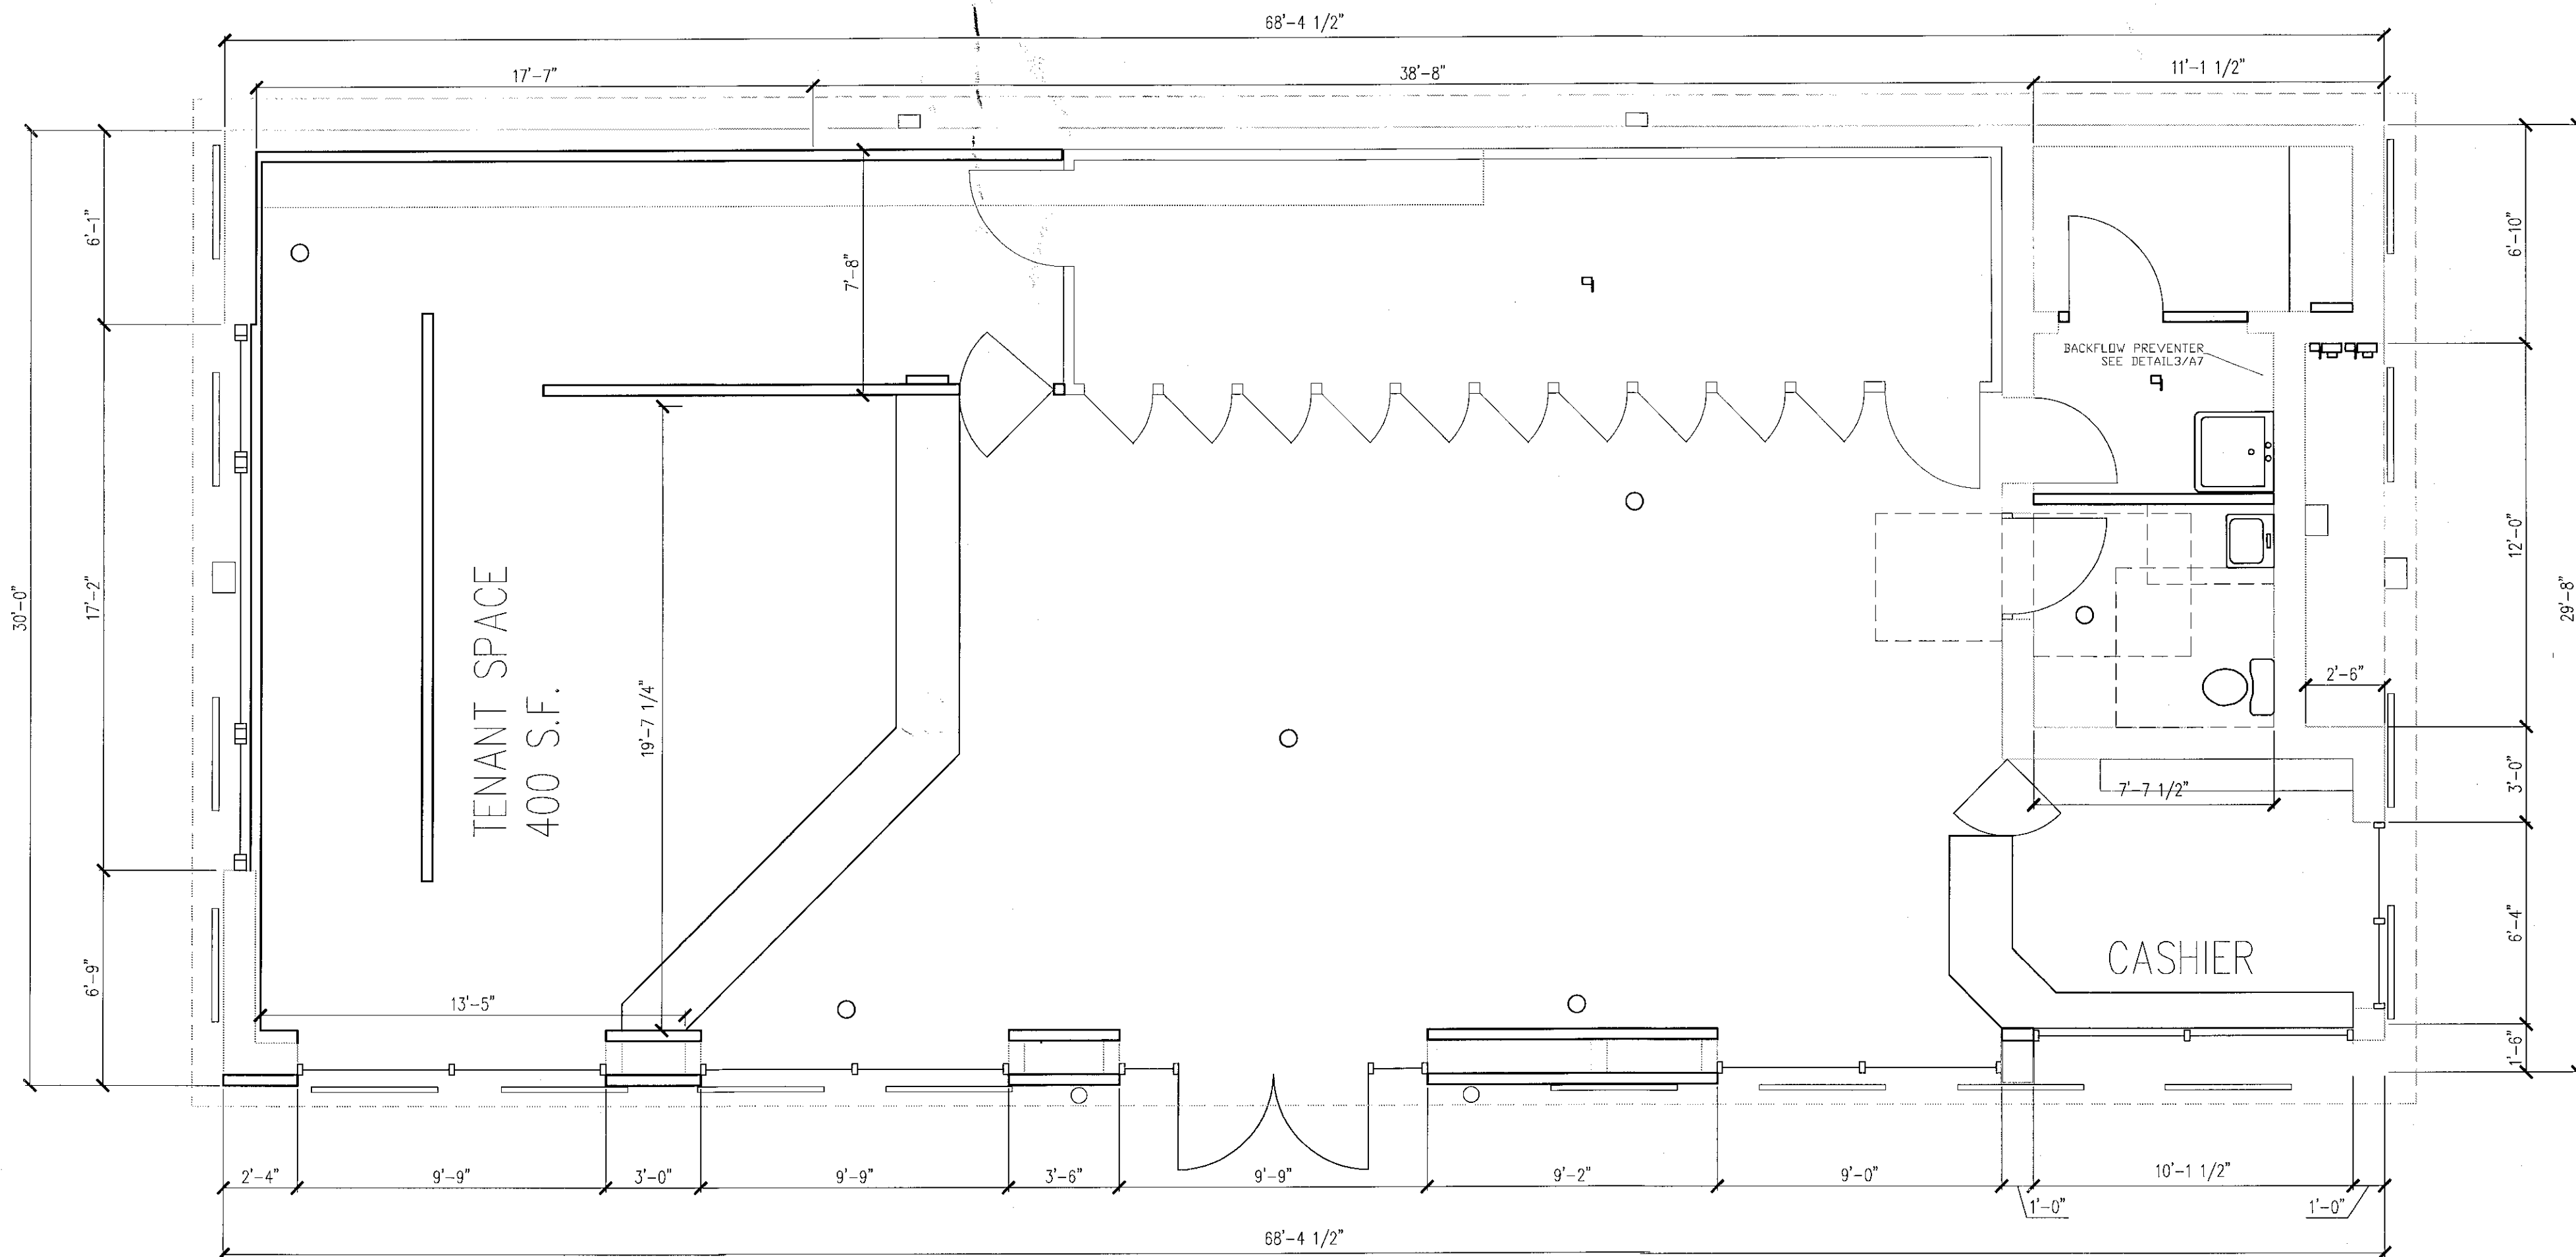


2 FLOOR PLAN
1/4" = 1'-0"

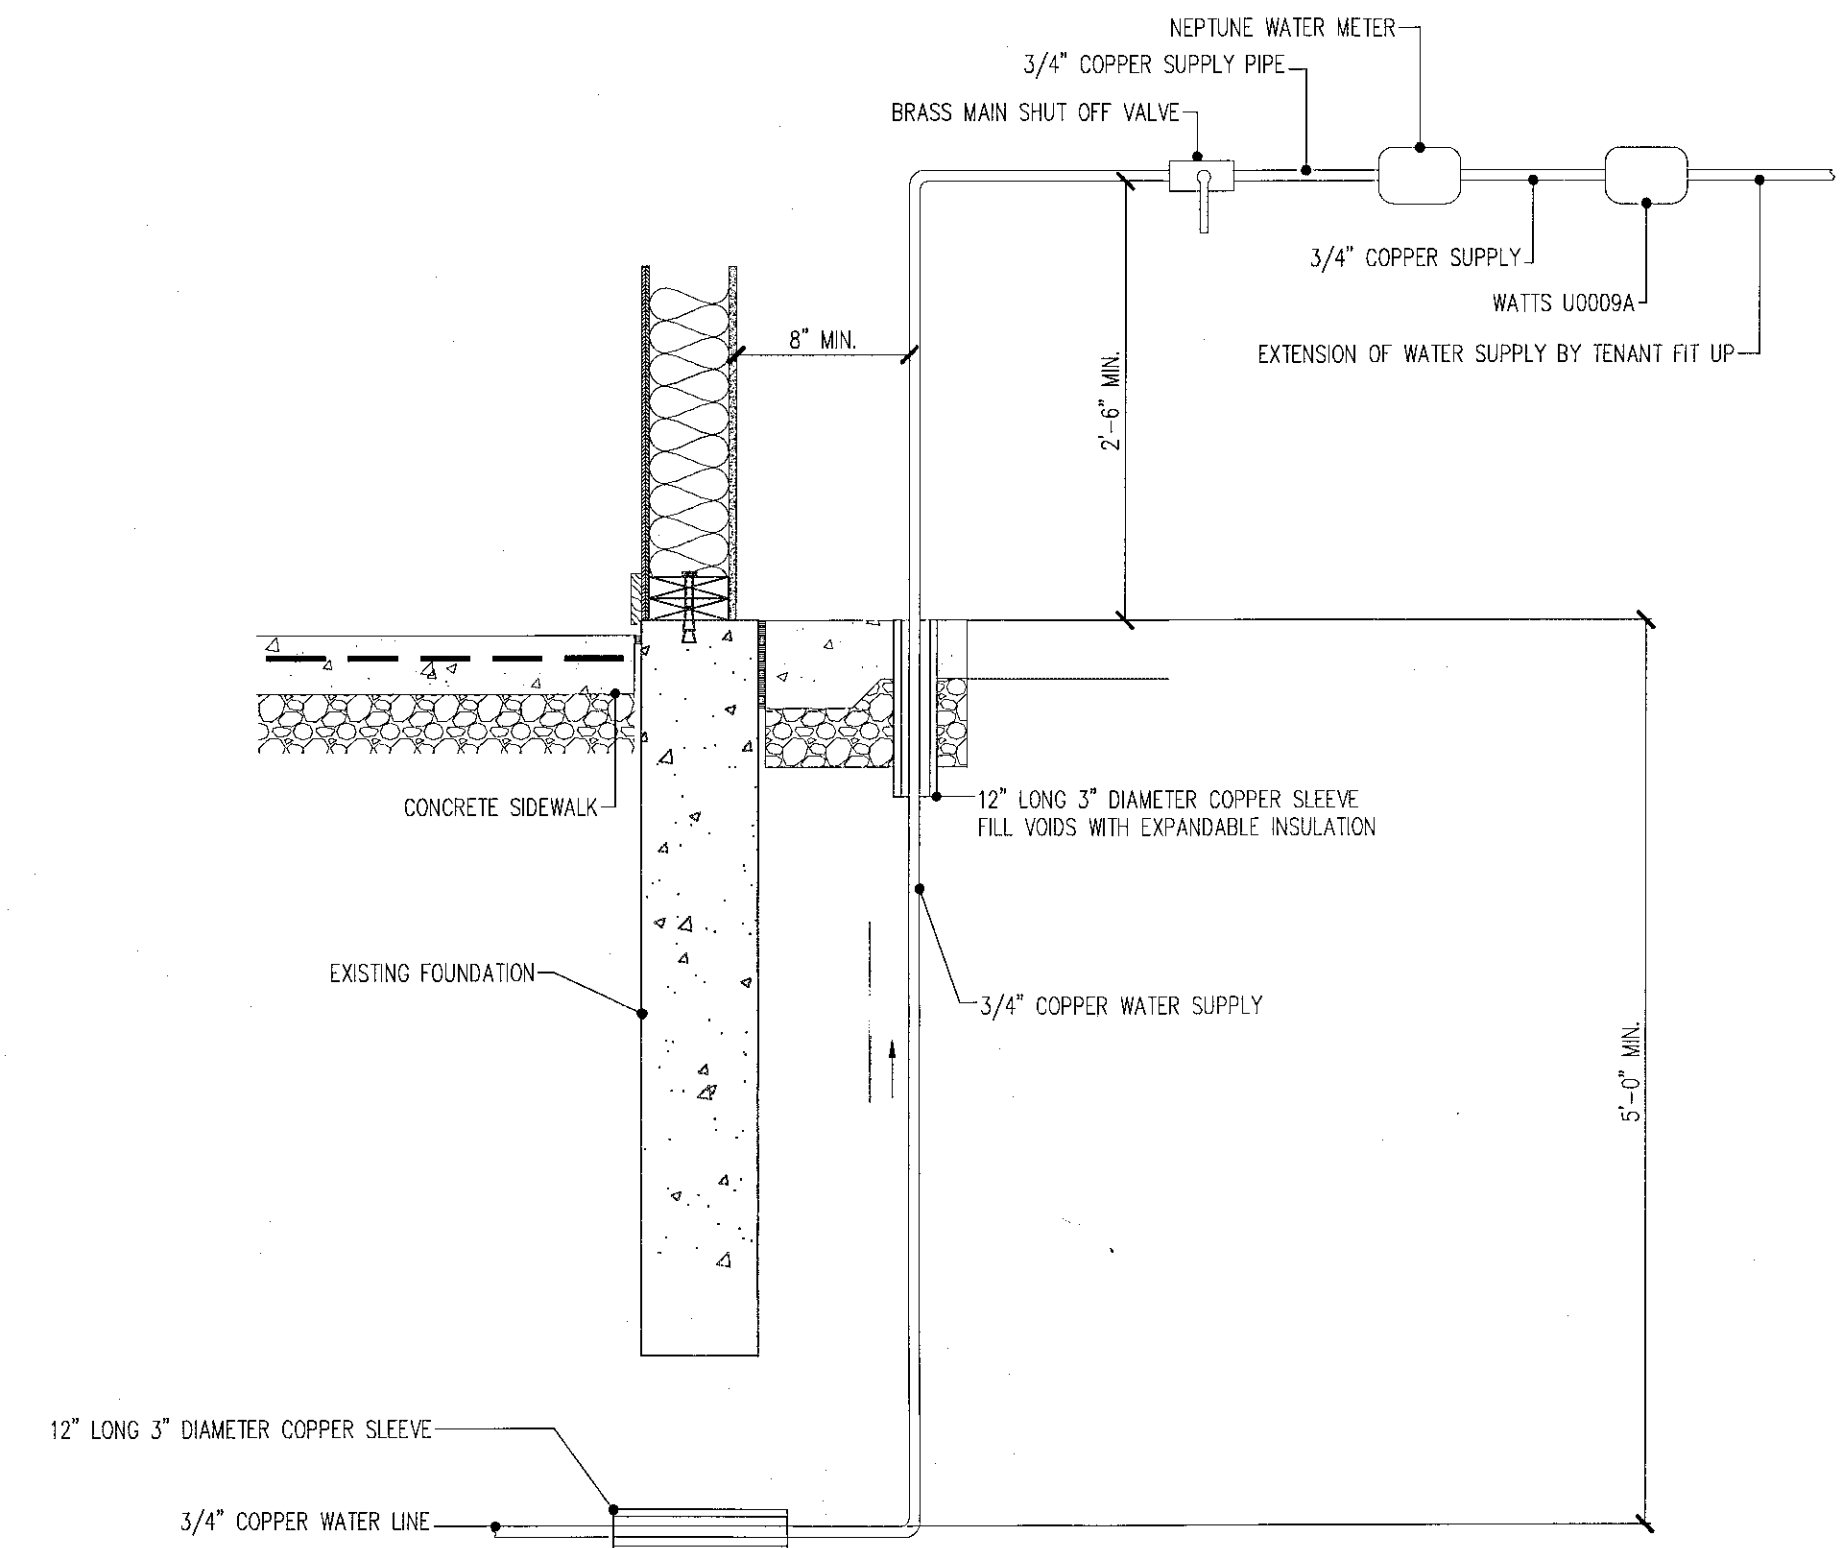

3 BACKFLOW PREVENTER DETAIL
NTS.

ELECTRICAL LEGEND


- SINGLE TUBE FLOURESCENT LIGHT
- WALL PACK LIGHT
- WALL SCONCE

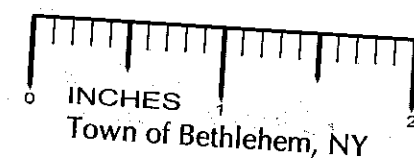

PLANNING BOARD APPROVAL
TOWN OF BETHLEHEM
ALBANY COUNTY, NEW YORK
This Site Plan Approved.
Robert Miller
Title *Chairman*
Date *4/1/08*
SPA 136

CAPITAL ARCHITECTURE
37 DAYS AVENUE
ALBANY, NEW YORK 12203
253-1442

THIS WORK WAS PREPARED BY ME
OR UNDER MY SUPERVISION AND
CONSTRUCTION OF THE PROJECT
WILL BE UNDER MY OBSERVATION

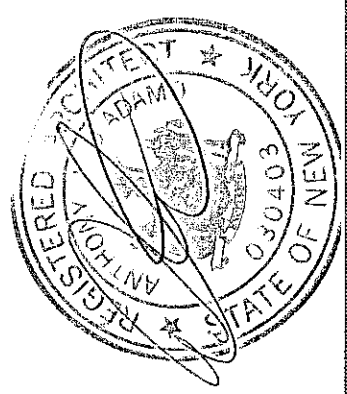

GLENMONT MOBIL

415 ROUTE 9W
GLENMONT, NY

REMOVAL AND FLOOR PLAN

REVISIONS:

SCALE: AS NOTED

DATE: 22 SEPTEMBER 07

DRAWN: A.D.

SHEET #

SHEET 5
OF 11