

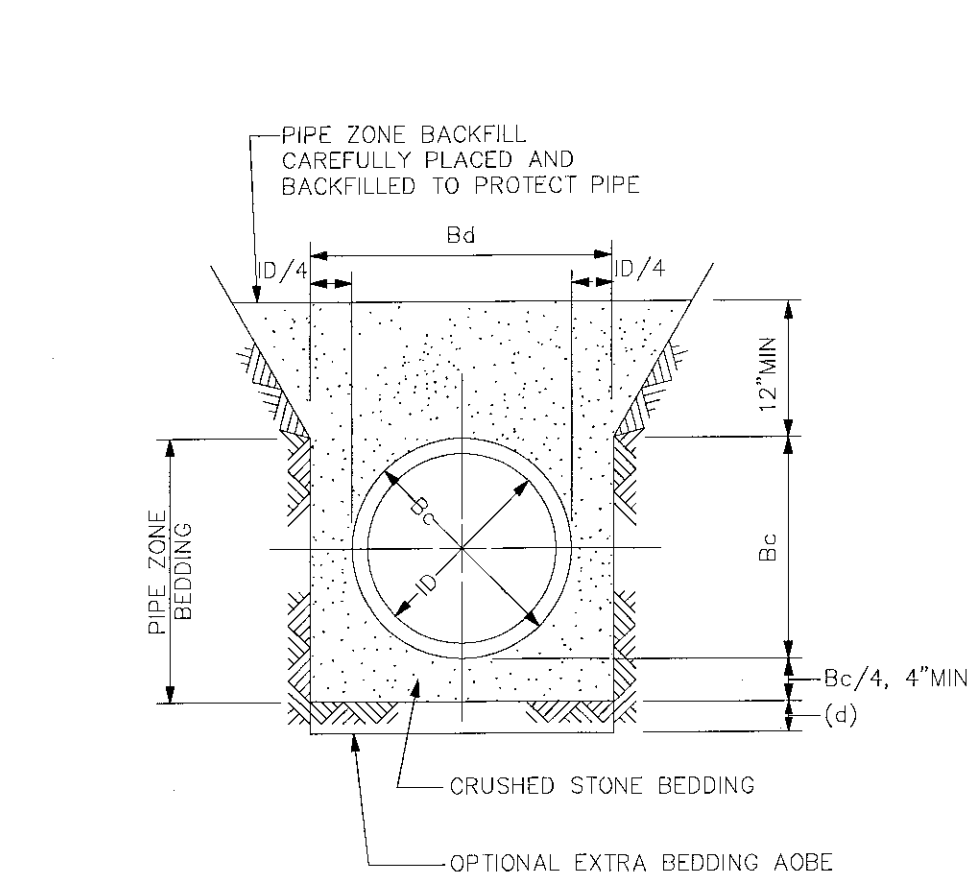
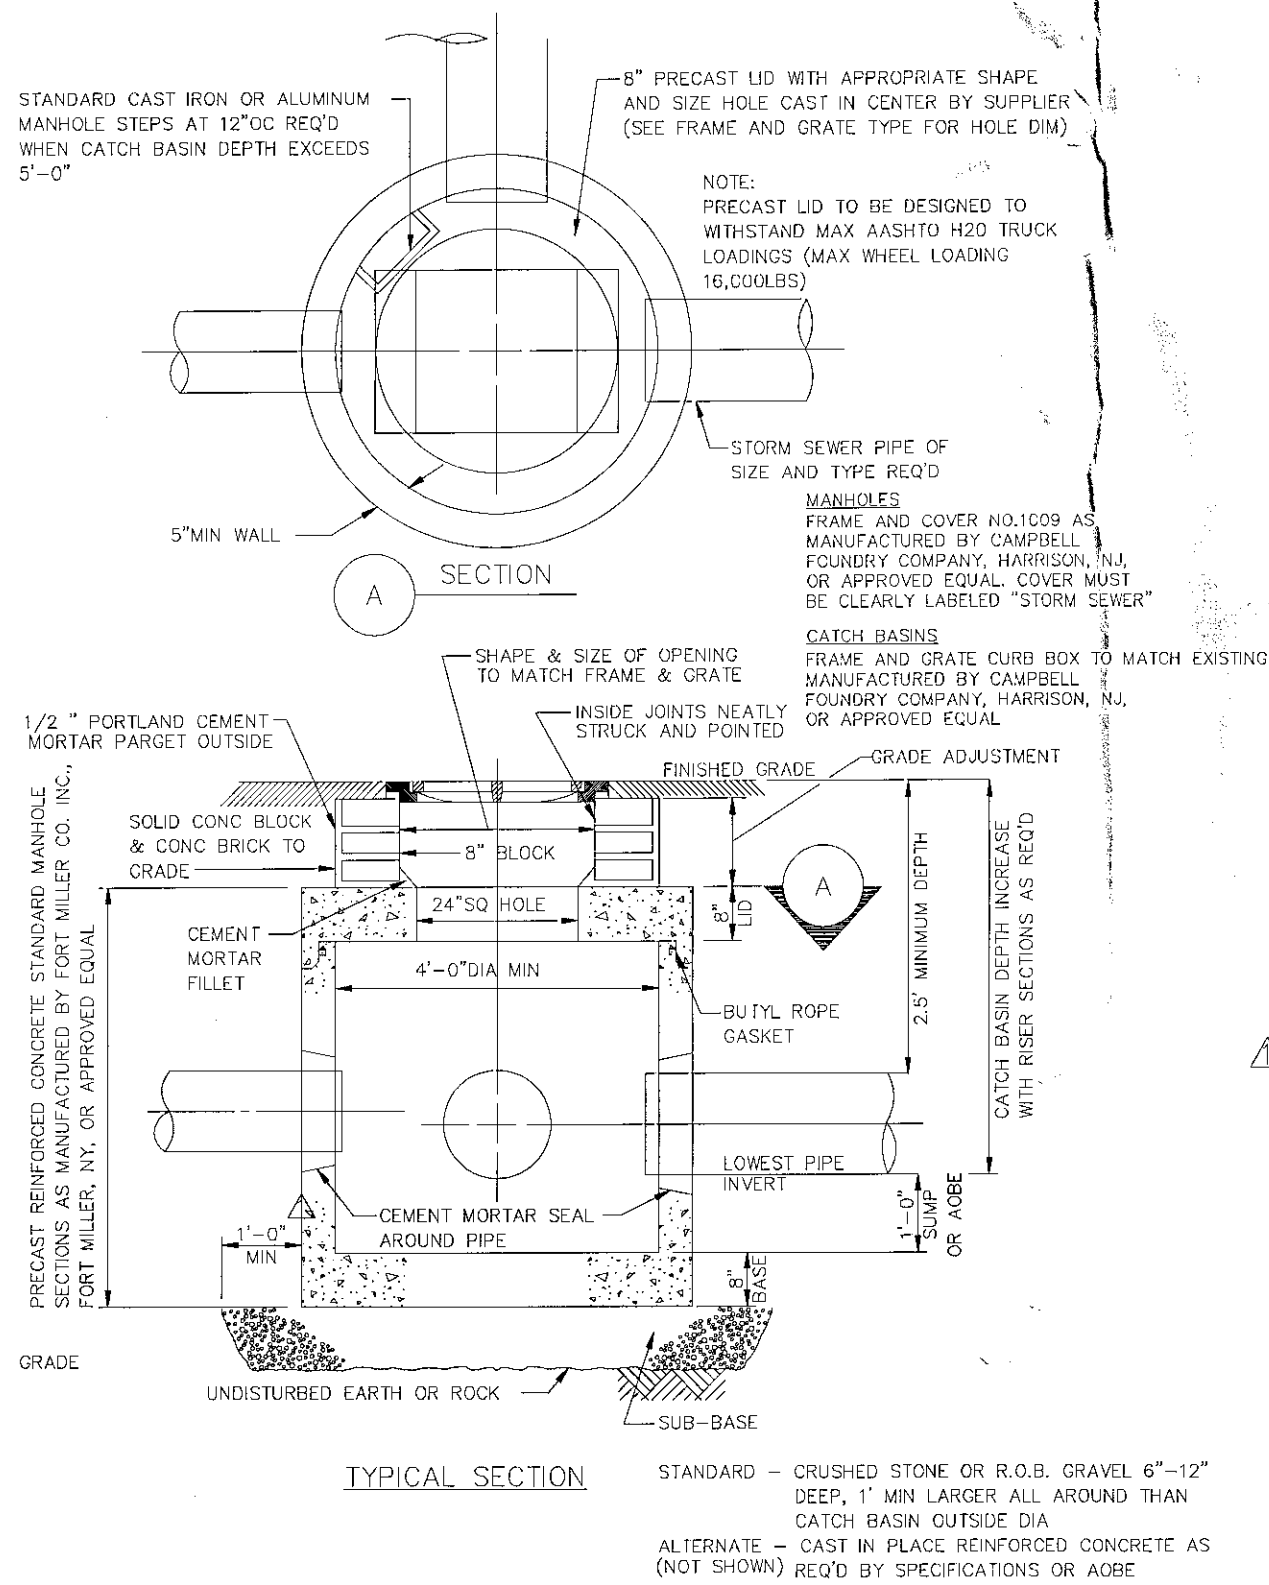
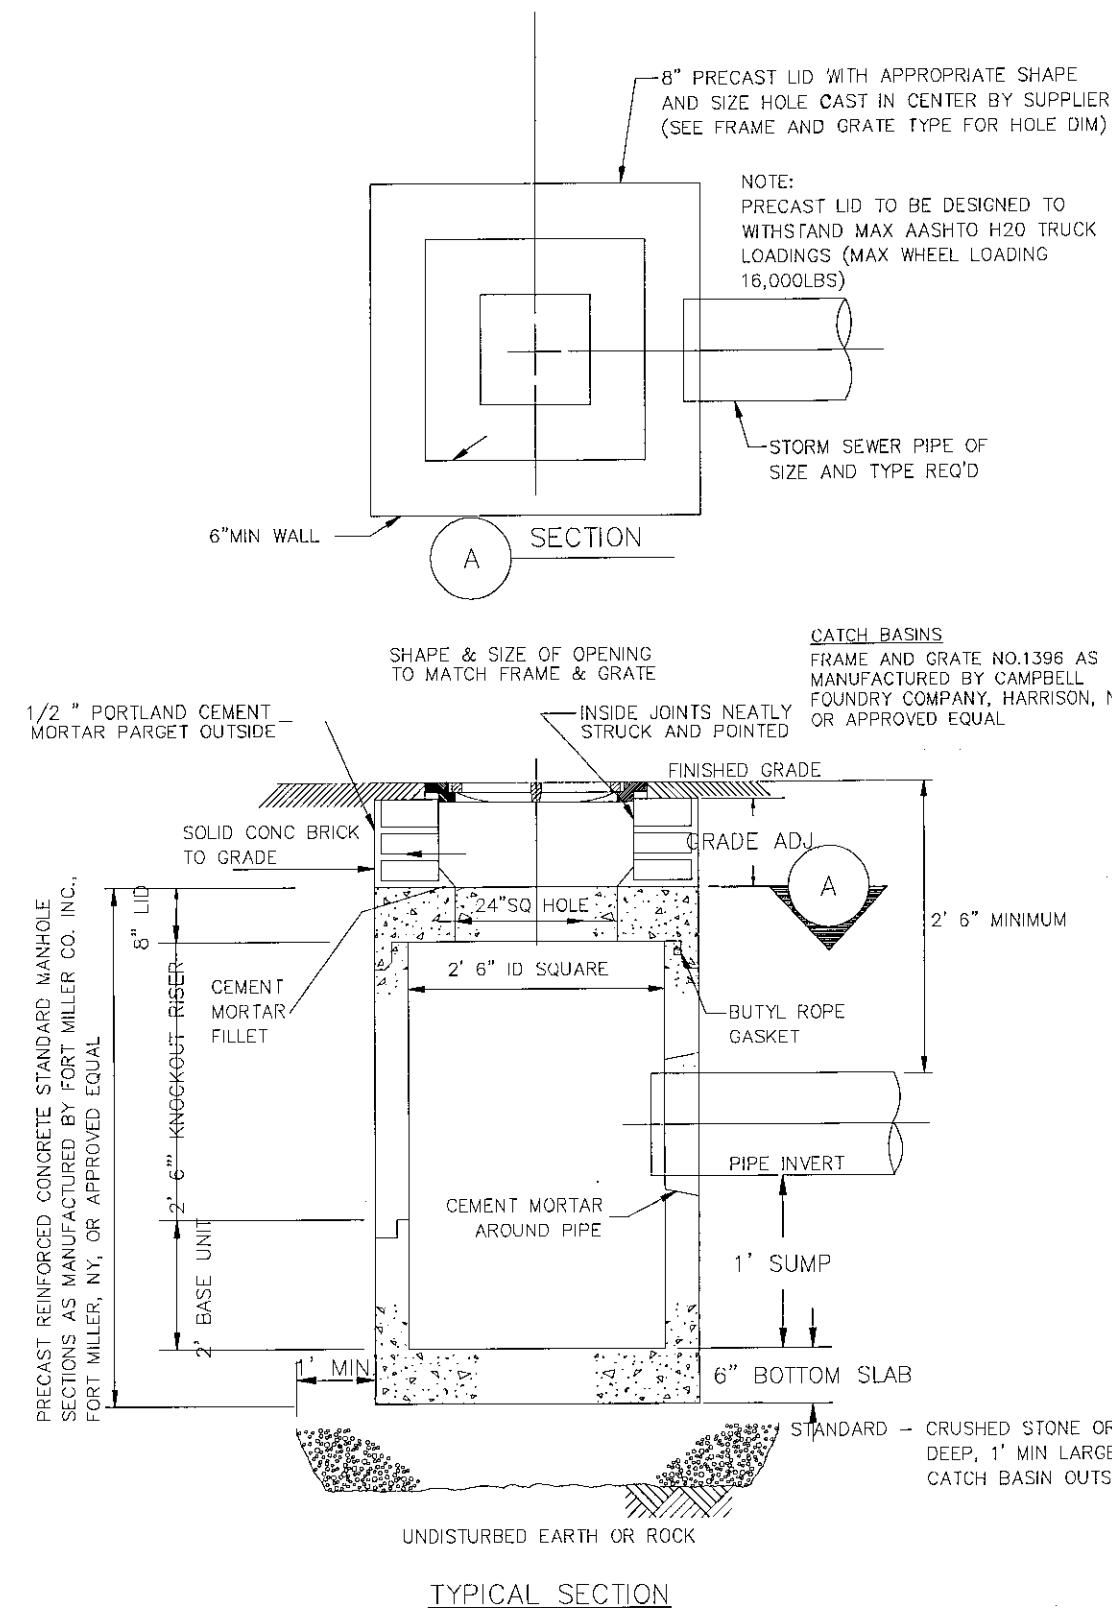
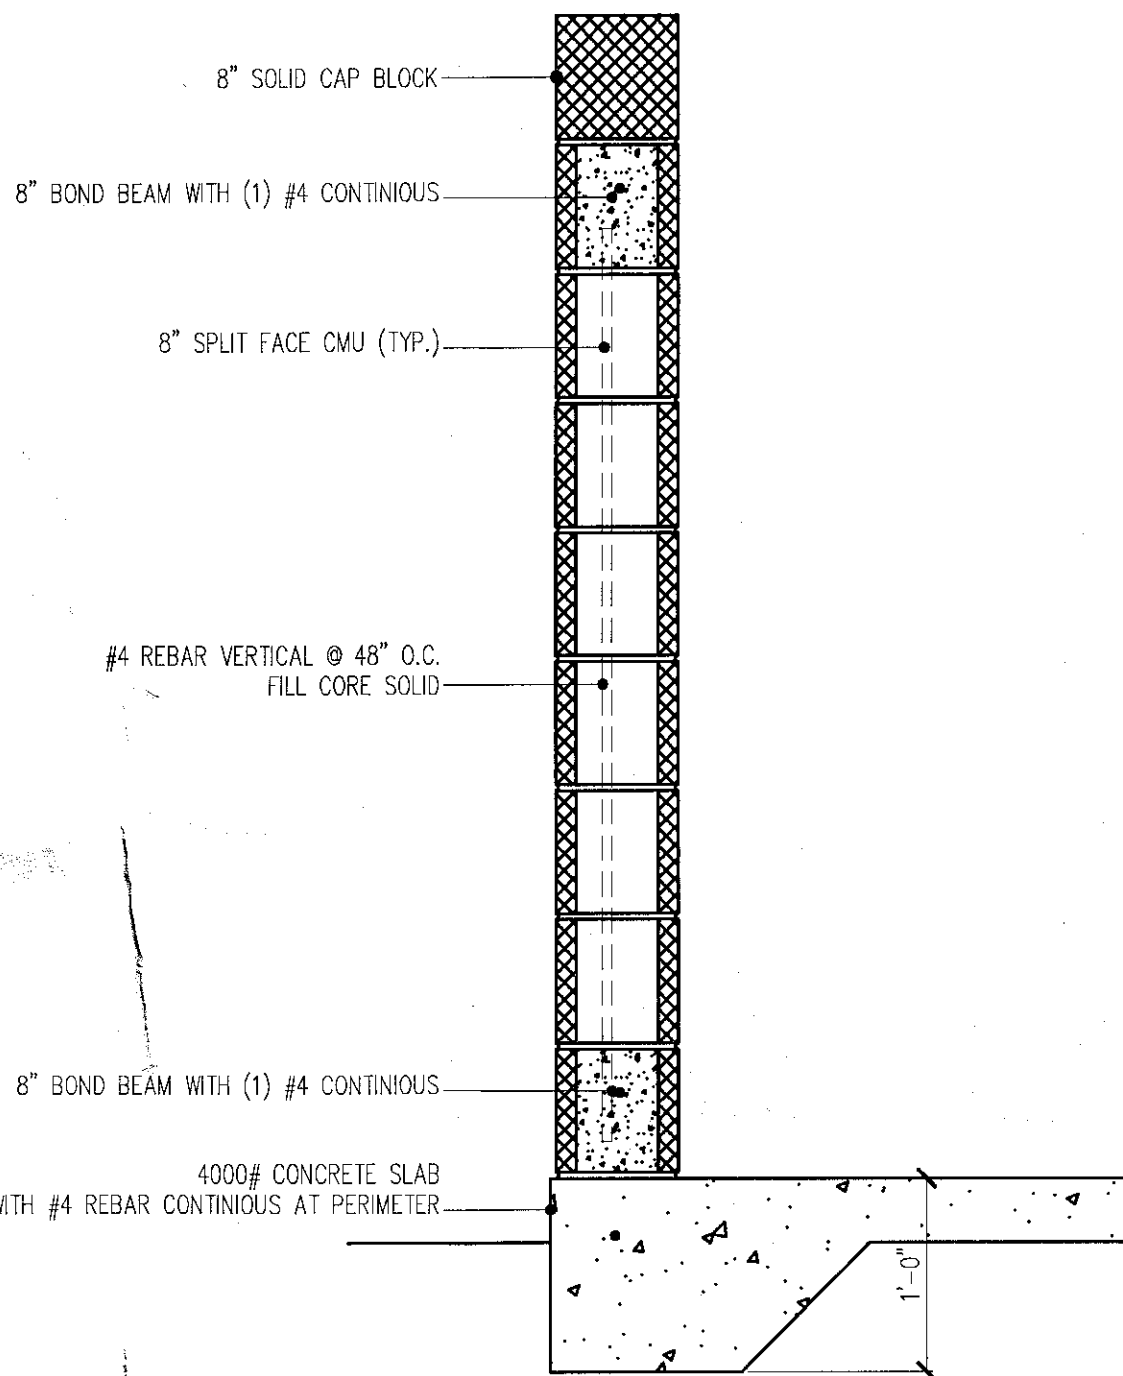
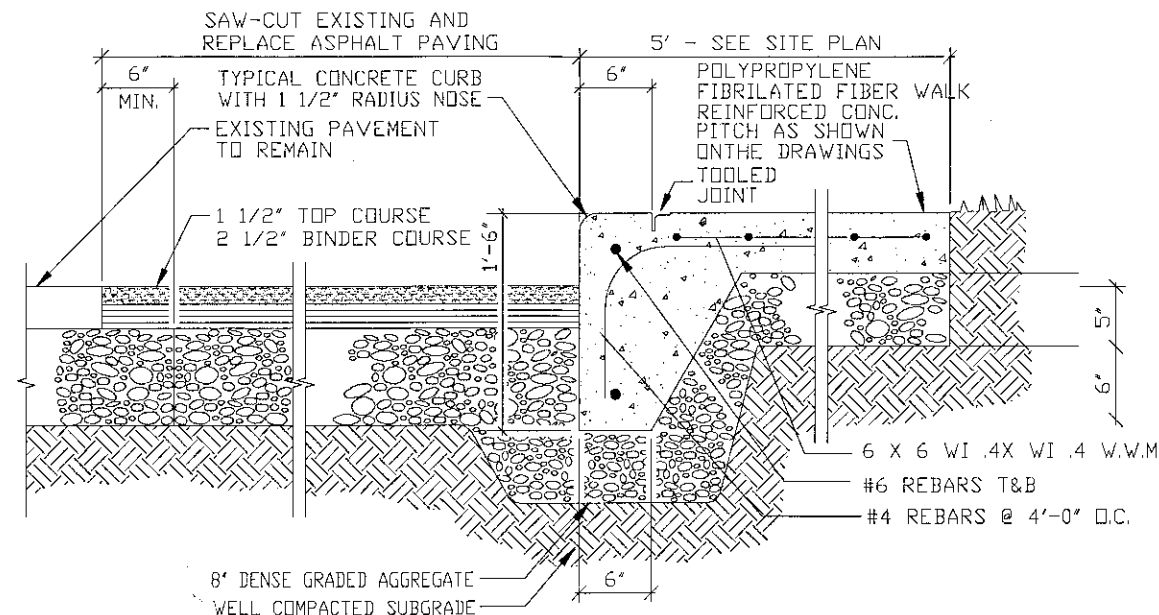
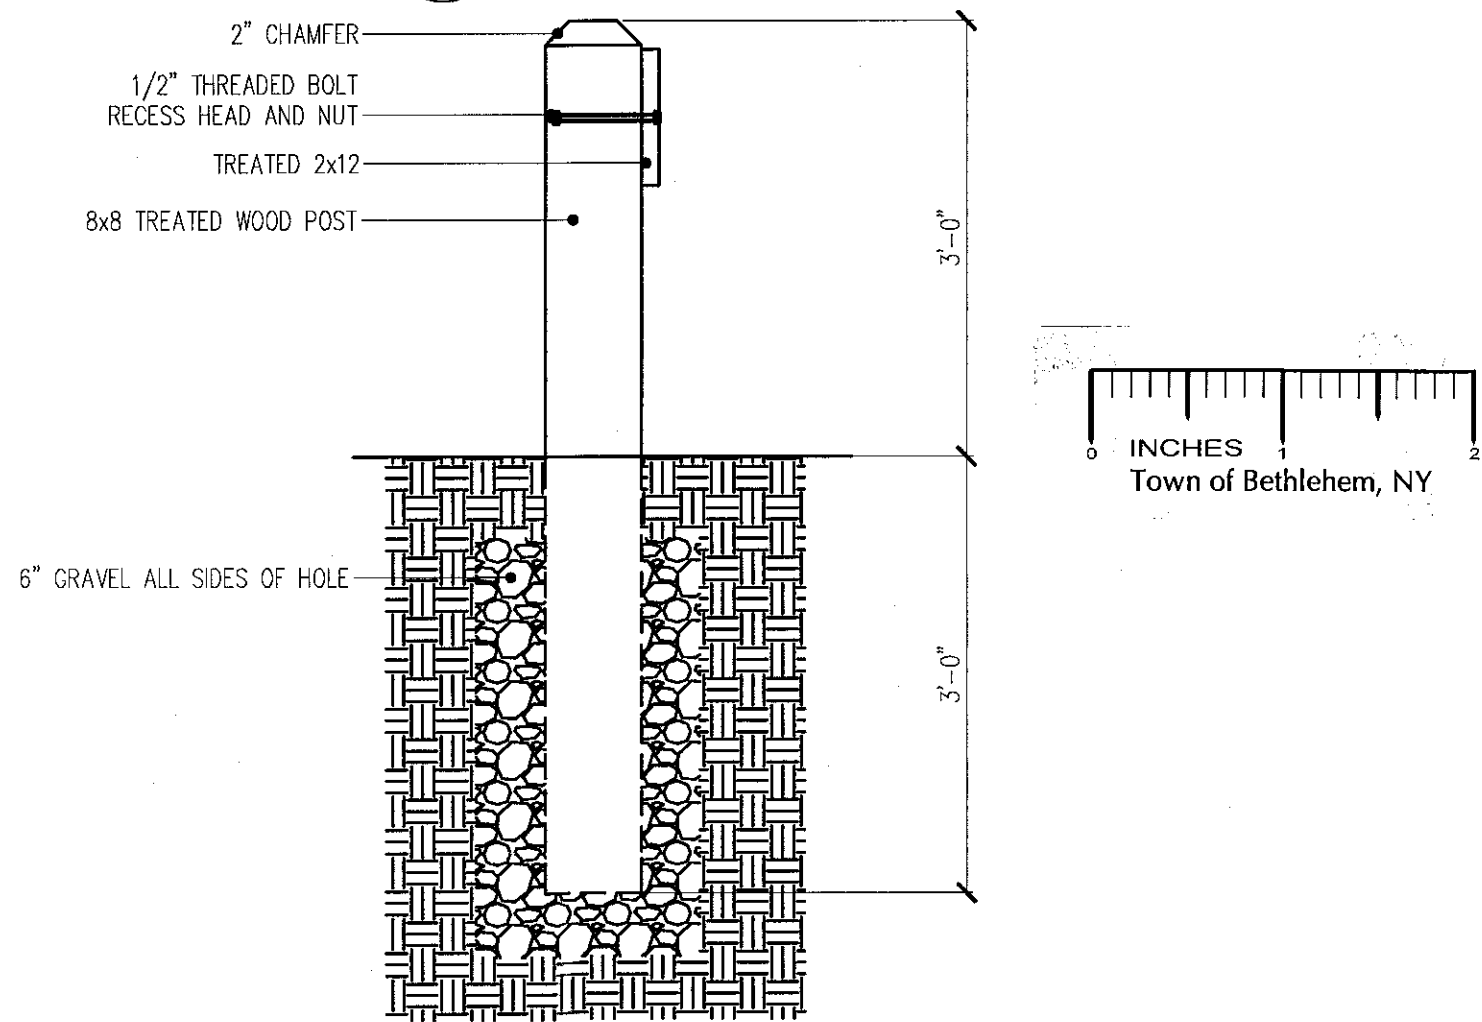


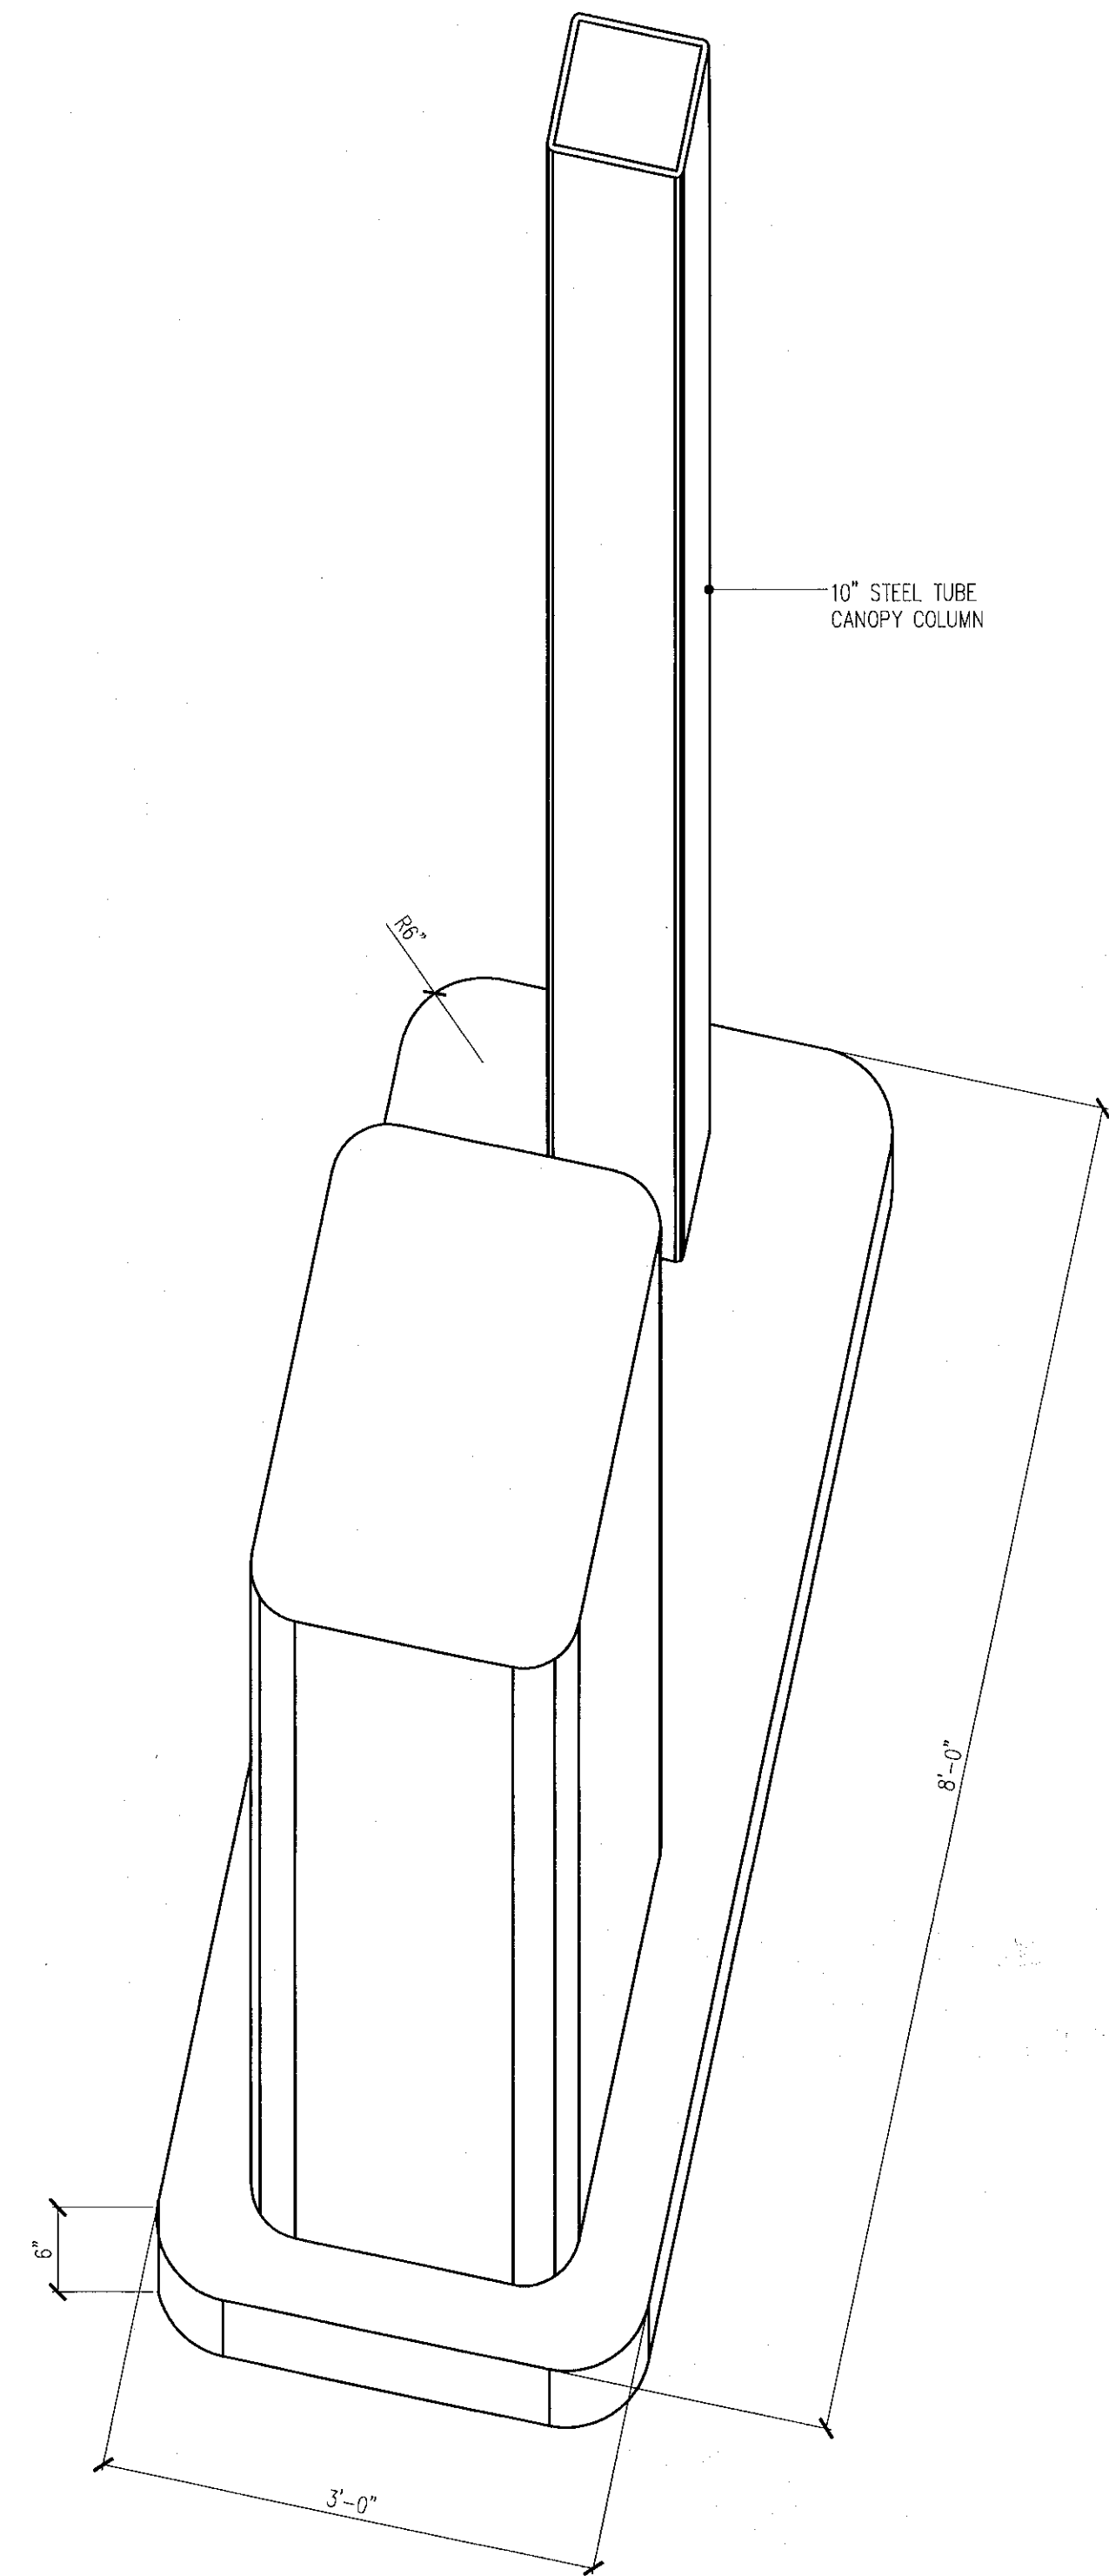

CORRUGATED HDPE PIPE						
PIPE DIMENSIONS ¹			TRENCH DIMENSIONS			
NOMINAL SIZE	ID	Bc	ID/4	Bc/4	Bd(ft)	ROCK EXCAVATION BELOW PIPE (ft)
12"	12"	15"	3"	4"	3.0'	6"
15"	15"	18"	4"	5"	3.0'	6"

NOTE:
1. STORM SEWER PIPE TO BE SMOOTH WALL.
2. ALL SLEEVES SHALL BE WATERTIGHT.
3. GASKETS SHALL CONFORM TO ASTM F477.
4. GASKETS AND SLEEVES SHALL BE LUBRICATED AS RECOMMENDED BY THE MANUFACTURER.
5. FITTINGS SHALL BE IN CONFORMANCE WITH AASHTO M294.

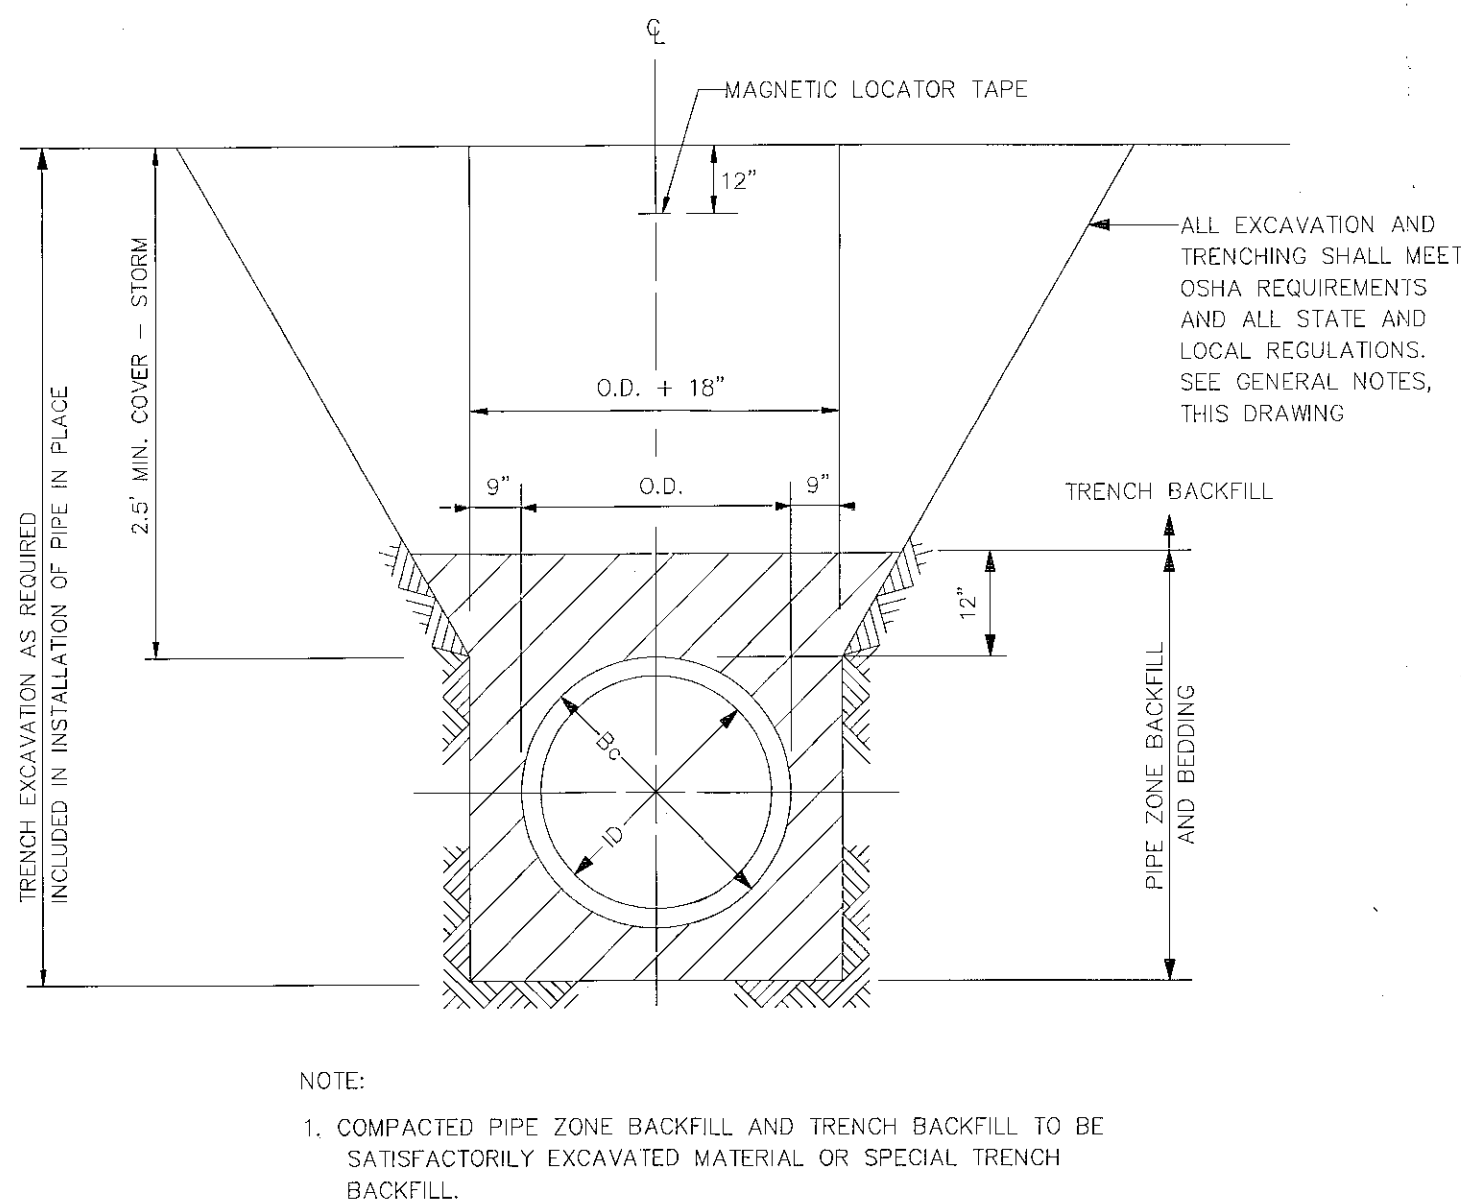

PLANNING BOARD APPROVAL
TOWN OF BETHLEHEM
ALBANY COUNTY, NEW YORK
This Site Plan Approved.
Date: 9/11/08

CAPITAL ARCHITECTURE
37 DAVIS AVENUE
ALBANY, NEW YORK 12203
253-1442

THIS WORK WAS PREPARED BY ME
OR UNDER MY SUPERVISION AND
CONSTRUCTION OF THIS PROJECT
WILL BE UNDER MY OBSERVATION

GLENMONT MOBIL
415 ROUTE 9W
GLENMONT, NY

REVISIONS:
AS NOTED
DATE: 22 SEPTEMBER 07
DRAWN: A.D.
SHEET #

SHEET #
OF 11