


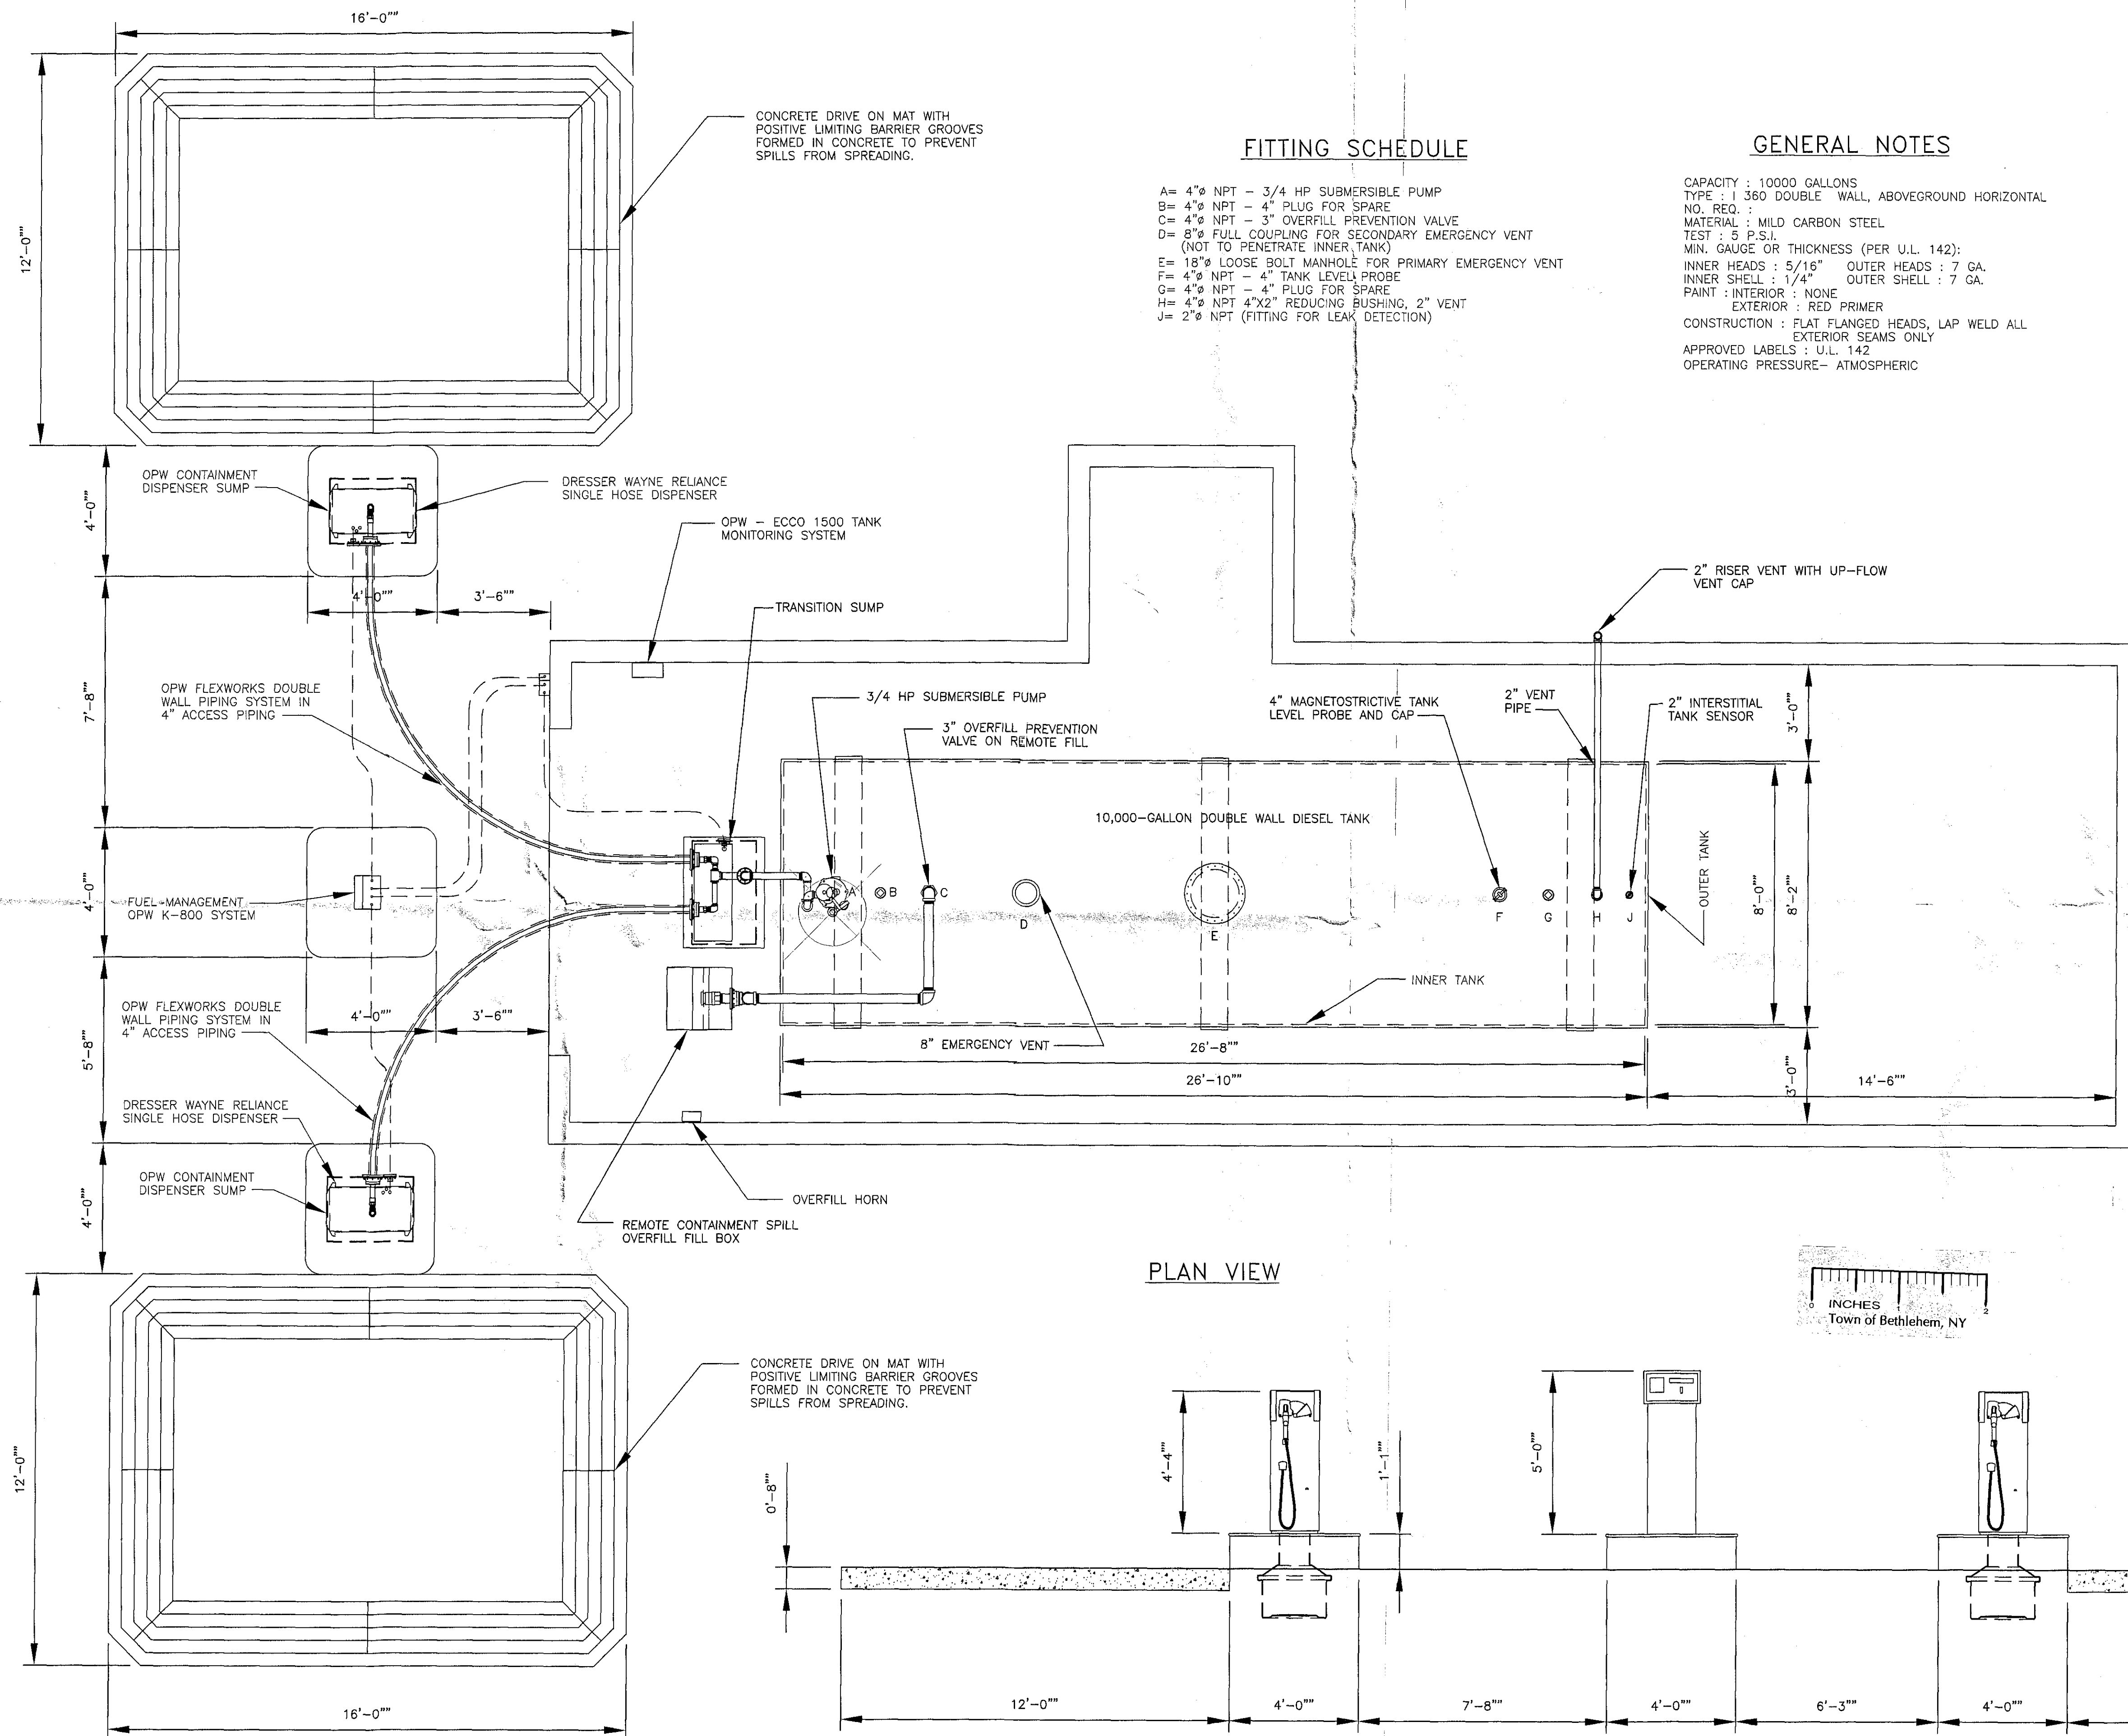

FITTING SCHEDULE

A= 4" NPT - 3/4 HP SUBMERSIBLE PUMP
B= 4" NPT - 4" PLUG FOR SPARE
C= 4" NPT - 3" OVERFILL PREVENTION VALVE
D= 8" FULL COUPLING FOR SECONDARY EMERGENCY VENT (NOT TO PENETRATE INNER TANK)
E= 18" LOOSE BOLT MANHOLE FOR PRIMARY EMERGENCY VENT
F= 4" NPT - 4" TANK LEVEL PROBE
G= 4" NPT - 4" PLUG FOR SPARE
H= 4" NPT 4"x2" REDUCING BUSHING, 2" VENT
J= 2" NPT (FITTING FOR LEAK DETECTION)

GENERAL NOTES

CAPACITY : 10000 GALLONS
TYPE : 1360 DOUBLE WALL, ABOVEGROUND HORIZONTAL
NO. REQ. :
MATERIAL : MILD CARBON STEEL
TEST : 5 P.S.I.
MIN. GAUGE OR THICKNESS (PER U.L. 142):
INNER HEADS : 5/16" OUTER HEADS : 7 GA.
INNER SHELL : 1/4" OUTER SHELL : 7 GA.
PAINT : INTERIOR : NONE
EXTERIOR : RED PRIMER
CONSTRUCTION : FLAT FLANGED HEADS, LAP WELD ALL EXTERIOR SEAMS ONLY
APPROVED LABELS : U.L. 142
OPERATING PRESSURE- ATMOSPHERIC

Errors And Omissions:
Father & Sons Consultants Is unable to accept liability for any errors of omission in excess of the original purchase cost of the plans. While every attempt has been made in the preparation of this plan to avoid errors. Father & Sons Consultants cannot guarantee against human error and omissions. Therefore, the contractor must check all dimensions and details and be responsible for the same. Do Not Scale Drawings.

Sheet 4

or 4


Drawn by JJB II

1 Town Revision 11.10.08

No. Revision Date

No. Revision Date

THIS DRAWING IS AND SHALL REMAIN THE PROPERTY OF FATHER AND SONS CONSULTANTS ANY USE OR REPRODUCTIONS, ALTERATIONS OF THESE DRAWINGS WITHOUT THE EXPRESSED WRITTEN CONSENT OF FATHER AND SONS CONSULTANTS IS STRICTLY PROHIBITED BY LAW.

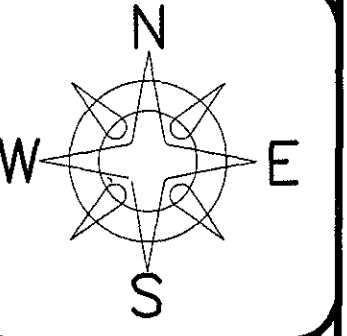

FATHER & SONS
CONSULTING ENGINEERS
122 MOHAWK STREET
COHOES, NY 12047

PLANNING BOARD
TOWN OF BETHLEHEM
ALBANY COUNTY, NEW YORK
This Site Plan Approved
Francis A. Lashway Jr.
Municipal Engineer
Date 12-16-08

FUEL DISPENSING SYSTEM
For Base of Operation Transportation Terminal
OWNER
DIVERSIFIED AUTO
ADDRESS
75 SPEEDER ROAD
SELKIRK, NY 12158
DATE 7/18/08
SCALE As Shown



FATHER & SONS CONSULTANT ENGINEERS
FRANCIS A. LASHWAY JR. P.E., (NY# 64314)
122 MOHAWK STREET
COHOES, NY. 12047
PH (518) 283-5464 FAX (518) 283-5464