

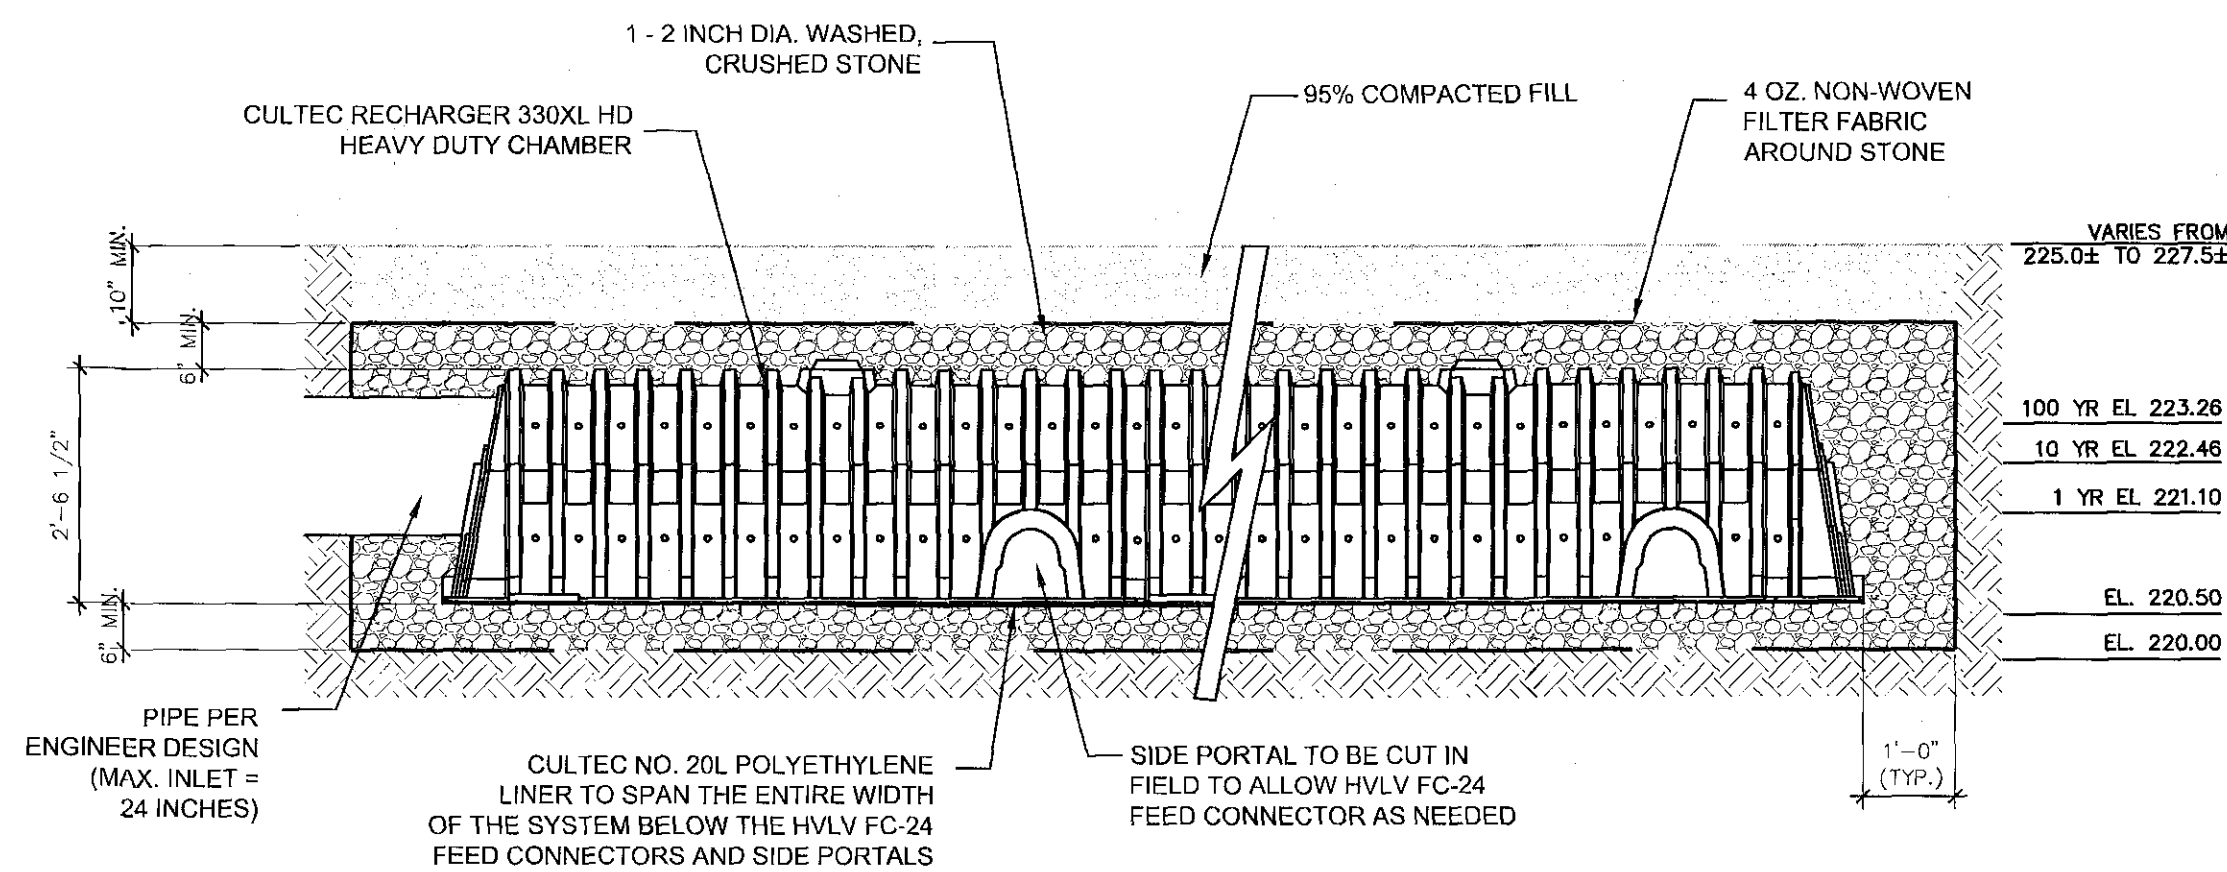
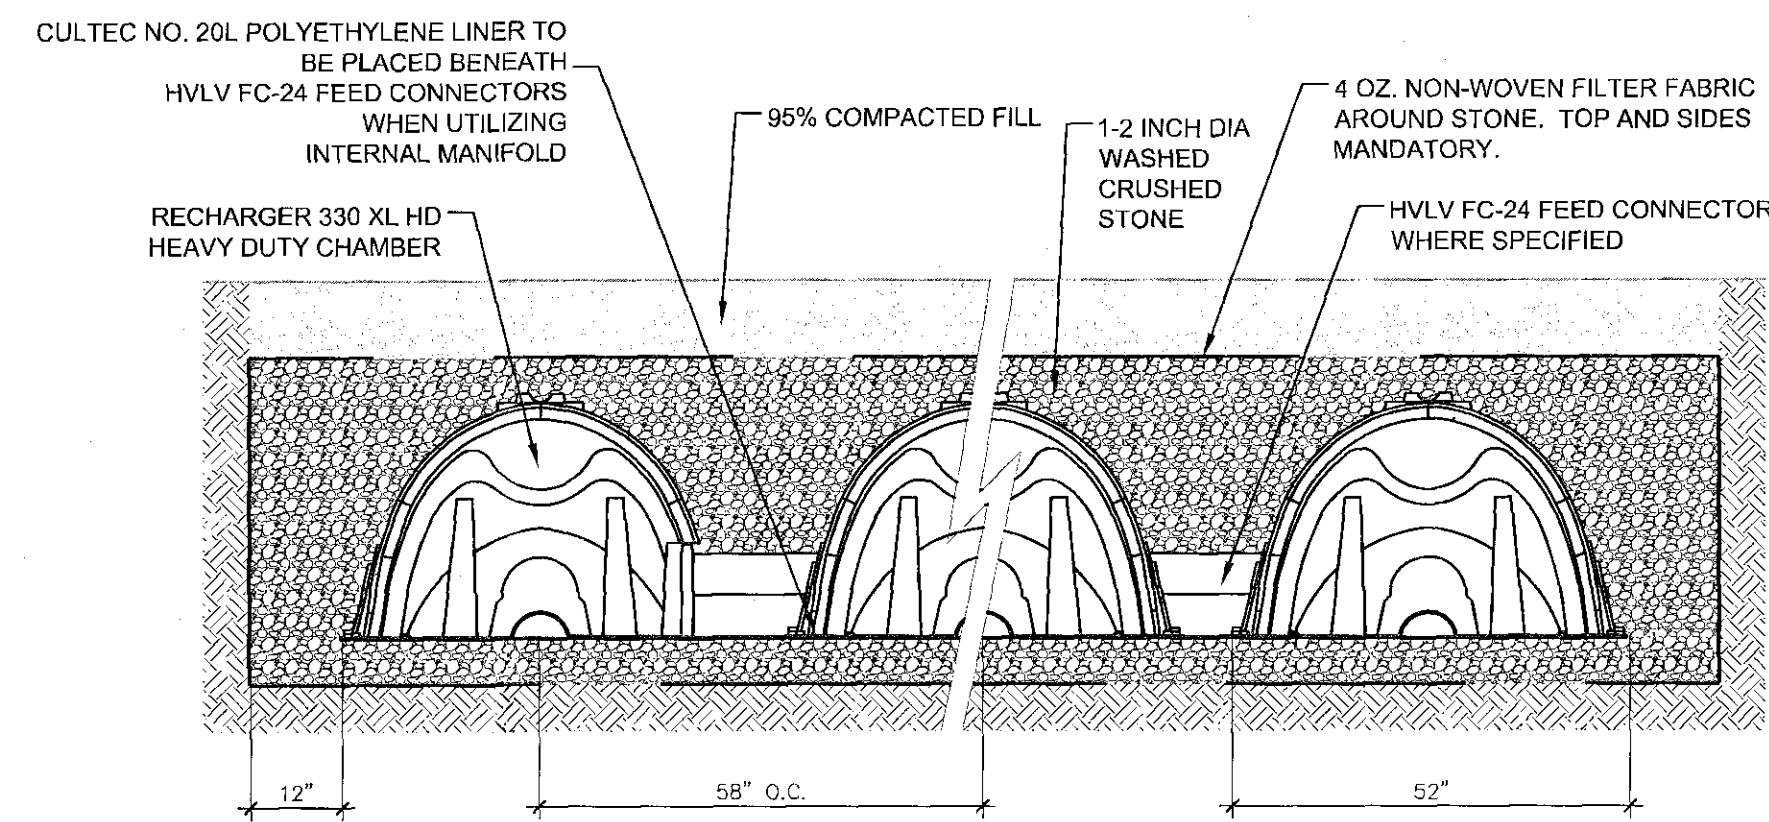
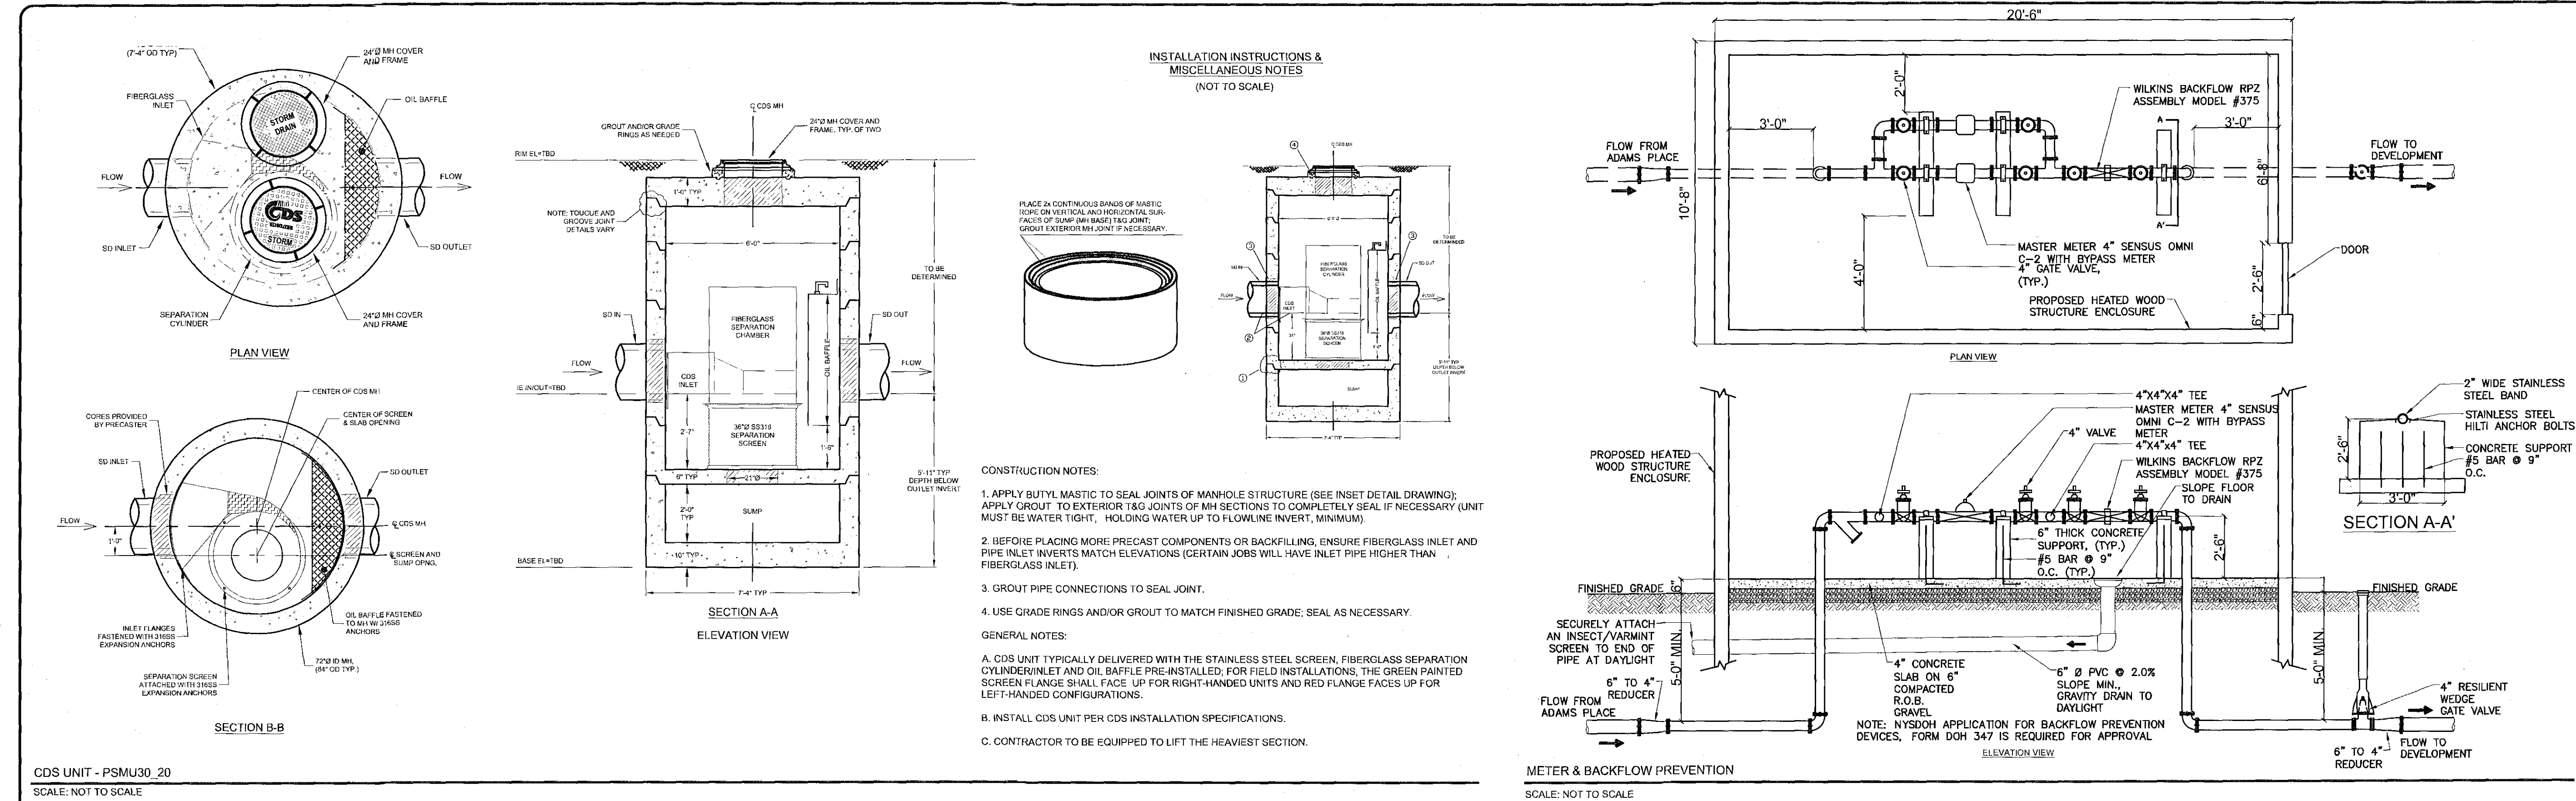


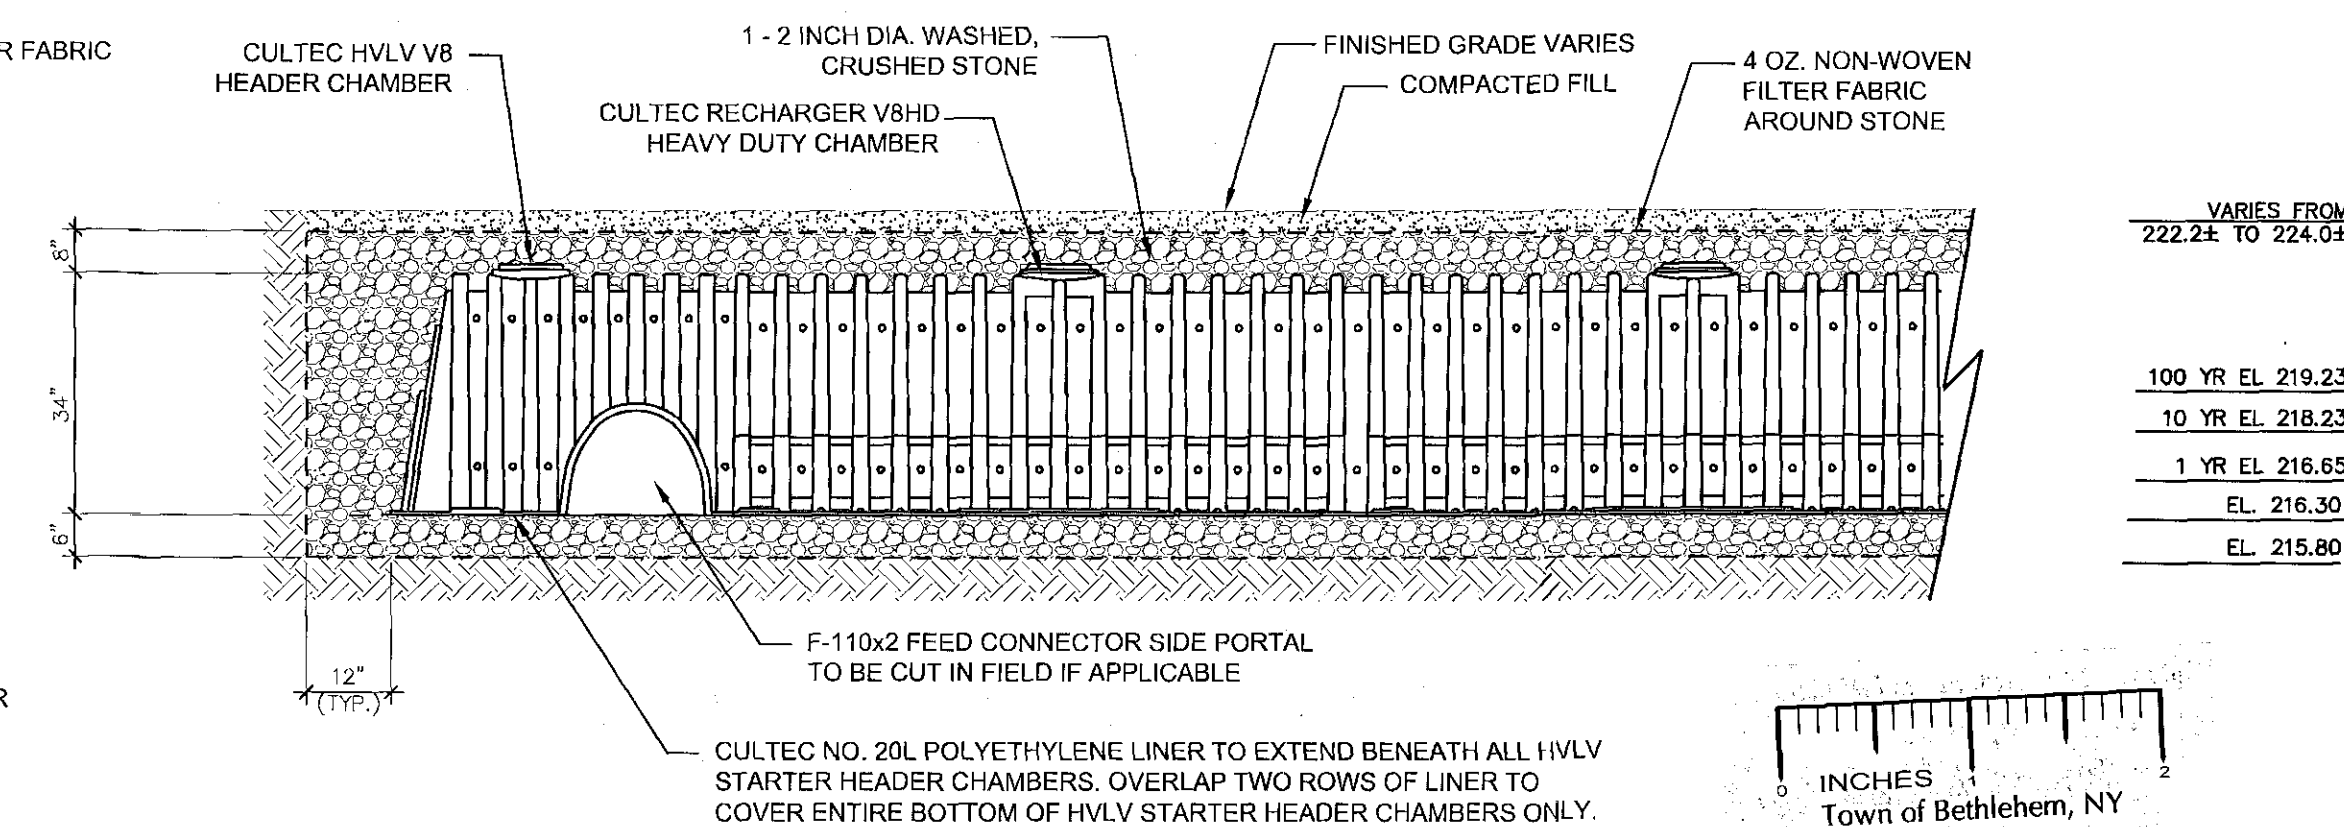

CULTEC SYSTEM - POND 1.2

SCALE: NOT TO SCALE

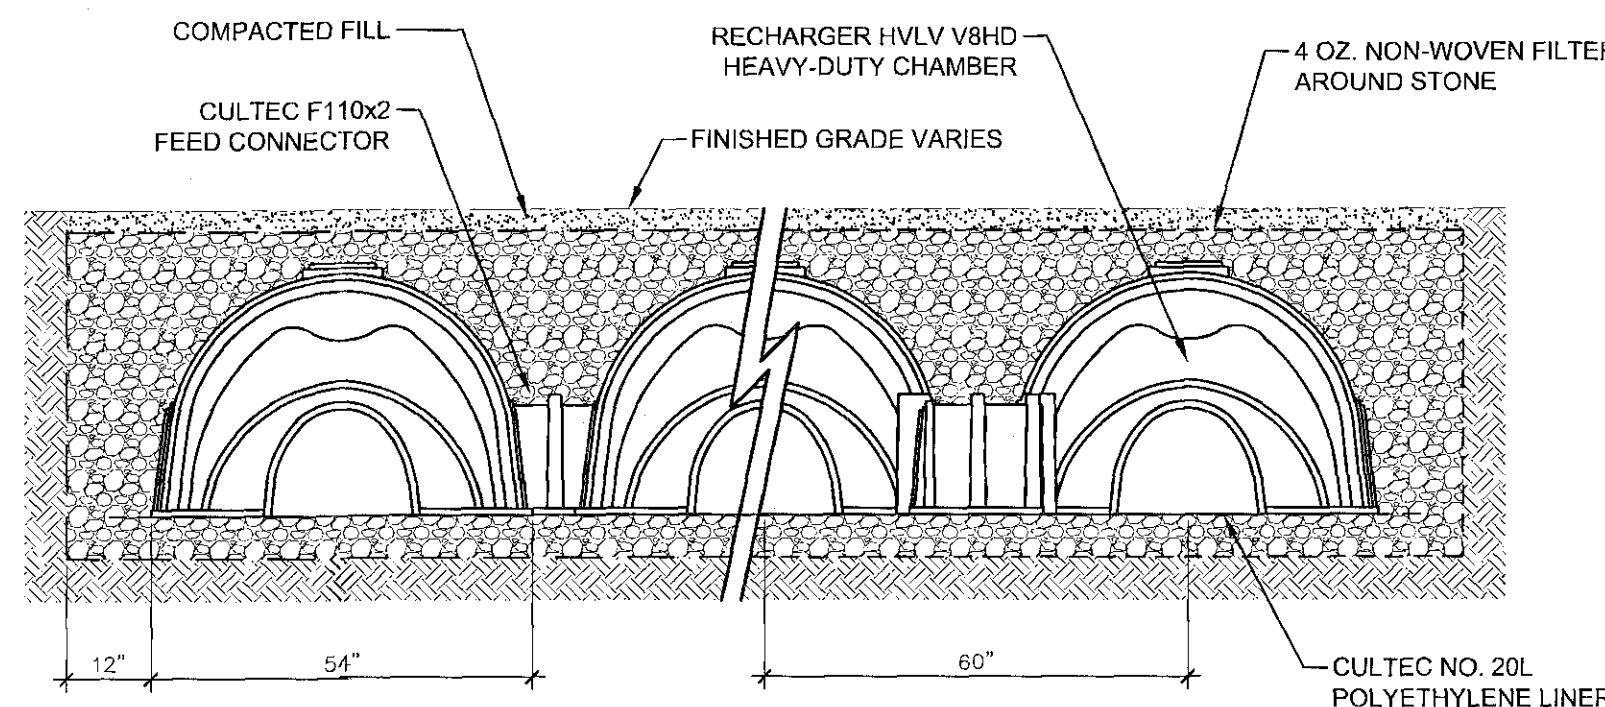

- GENERAL NOTES
1. RECHARGER V8HD BY CULTEC, INC. OF BROOKFIELD, CT. STORAGE PROVIDED = 13.03 CF/FI PER DESIGN UNIT. REFER TO CULTEC, INC.'S CURRENT RECOMMENDED INSTALLATION GUIDELINES. USE RECHARGER V8HD HEAVY DUTY FOR TRAFFIC AND/OR H2O APPLICATIONS.
 2. ALL RECHARGER V8HD HEAVY DUTY UNITS ARE MARKED WITH A COLOR STRIPE FORMED INTO THE PART ALONG THE LENGTH OF THE CHAMBER. ALL RECHARGER V8HD CHAMBERS MUST BE INSTALLED IN ACCORDANCE WITH ALL APPLICABLE LOCAL, STATE AND FEDERAL REGULATIONS.
 3. EXISTING GRADE IN THE VICINITY OF CULTEC SYSTEM IS APPROXIMATELY ELEV. 220.0 TO 221.0 FEET.
 4. THE GROUND WATER ELEVATION IS ESTIMATED TO BE BELOW ELEV. 213.60' BASED ON FIELD MEASUREMENTS.

PLANNING BOARD
TOWN OF BETHLEHEM
ALBANY COUNTY, NEW YORK


This Site Plan Approved:

Angie Finner
Title: Chairman

Date: 4/15/2011 SP153A2

infinigy
engineering

11 Herbert Drive,
Latham, New York 12110
(518) 690-0790

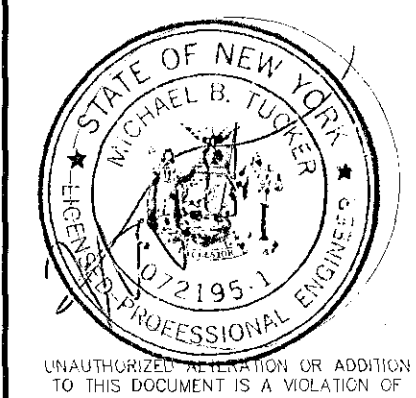

No.	Submital / Revision	App'd	Date
4	TOWN COMMENTS	MBT	3/11
3	TOWN COMMENTS	MBT	1/11
2	TOWN COMMENTS	MBT	12/10
1	TOWN COMMENTS	MBT	12/10

Drawn: M.B. Date: 10/10
Designed: MBT Date: 10/10
Checked: MBT Date: 10/10

Project Number
182-122

Project Title

The Gables
at Delmar

Delaware Avenue
Delmar, NY 12054

Prepared For

Keystone
Builders Inc.

Drawing Title
Site & Utility
Details

Drawing Scale:
1" = 40'

Date:
3/18/2011

Issued For

SITE PLAN
APPROVAL

Drawing Number

C-18