

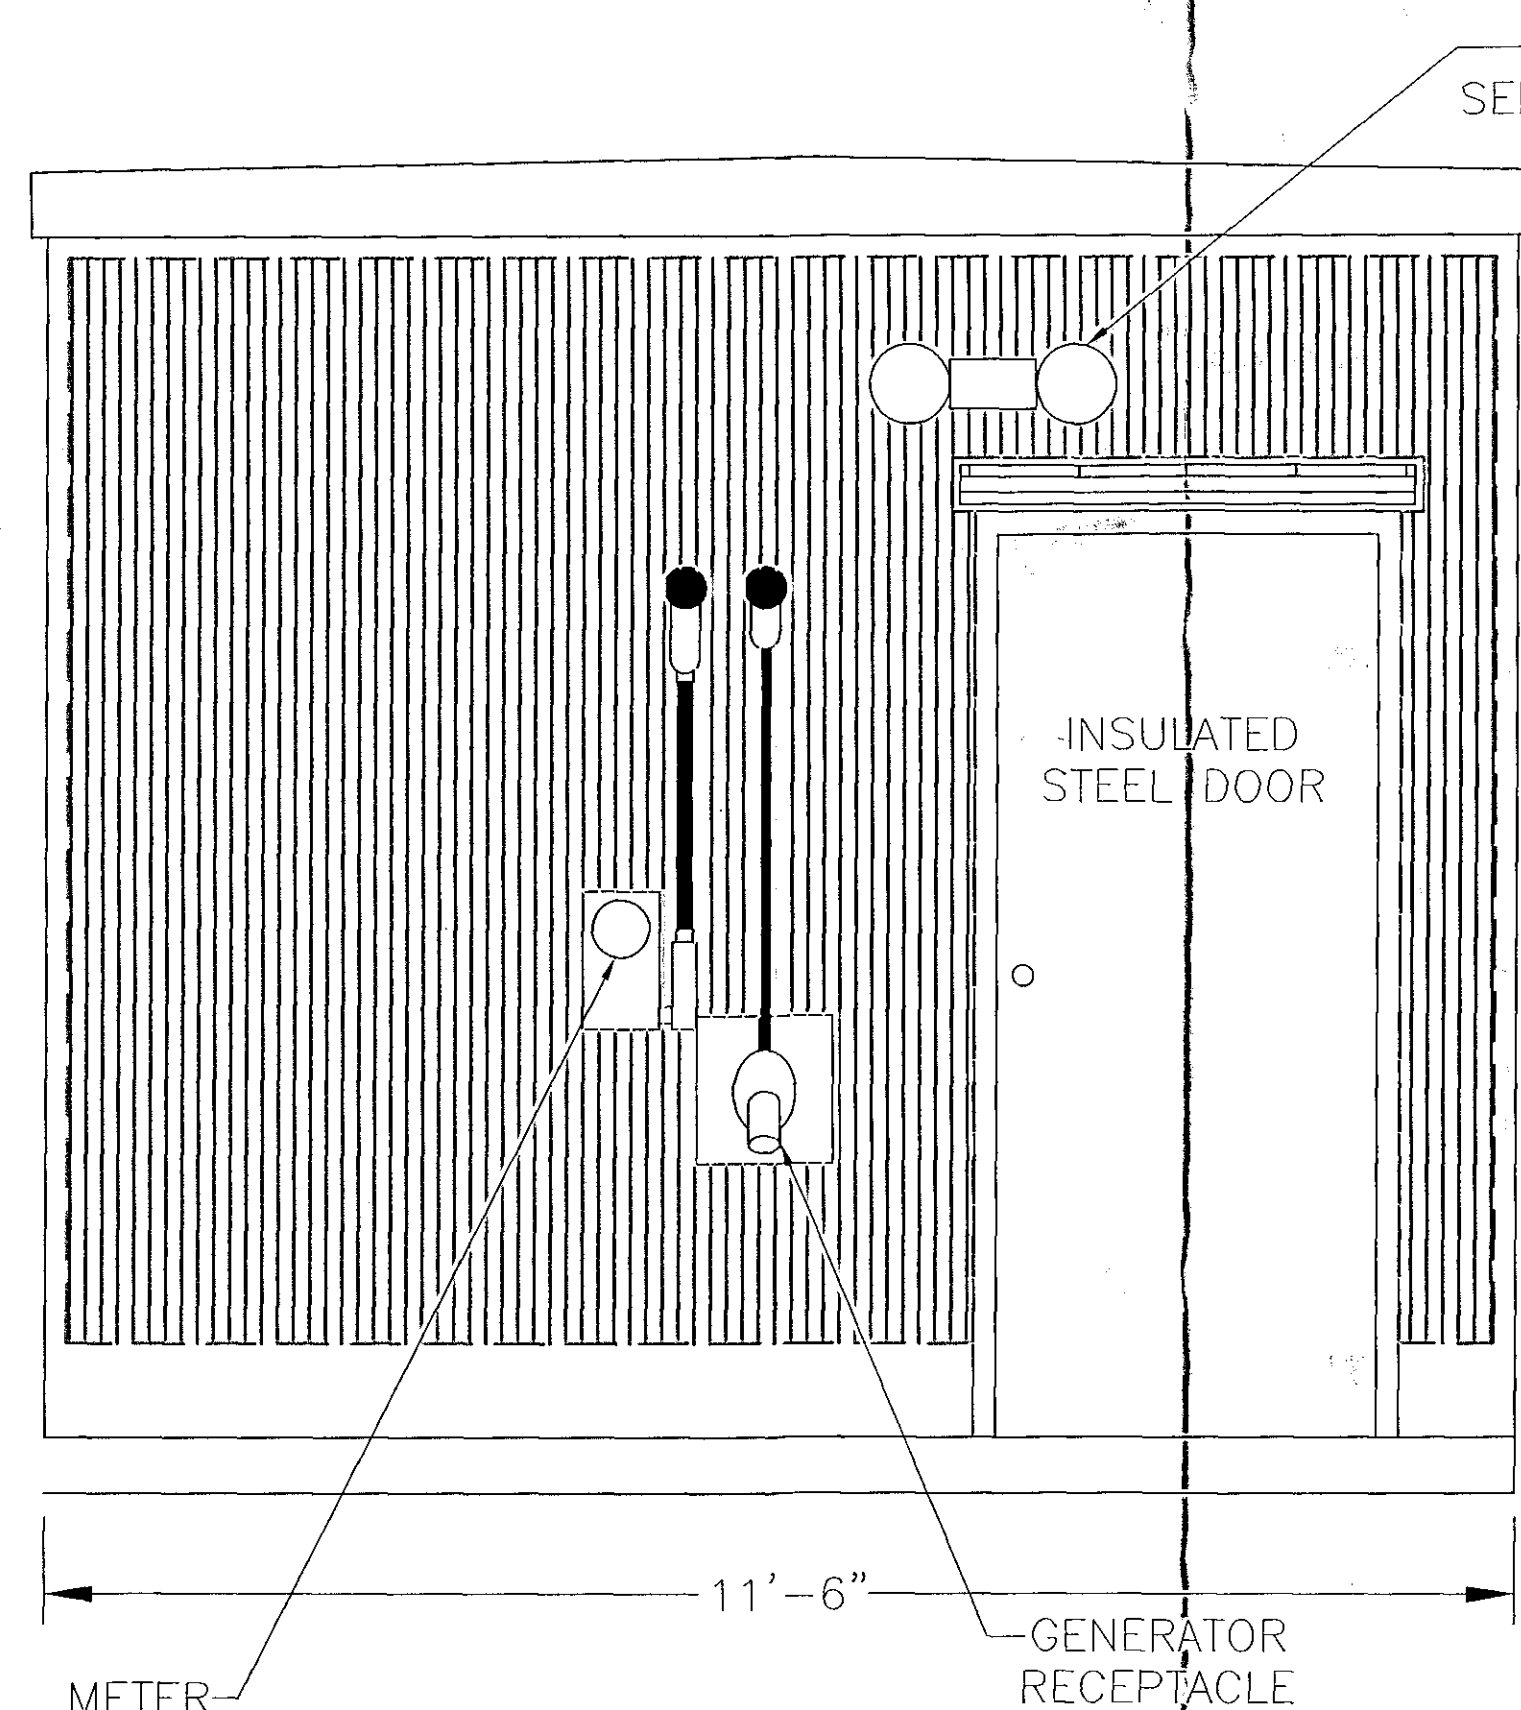


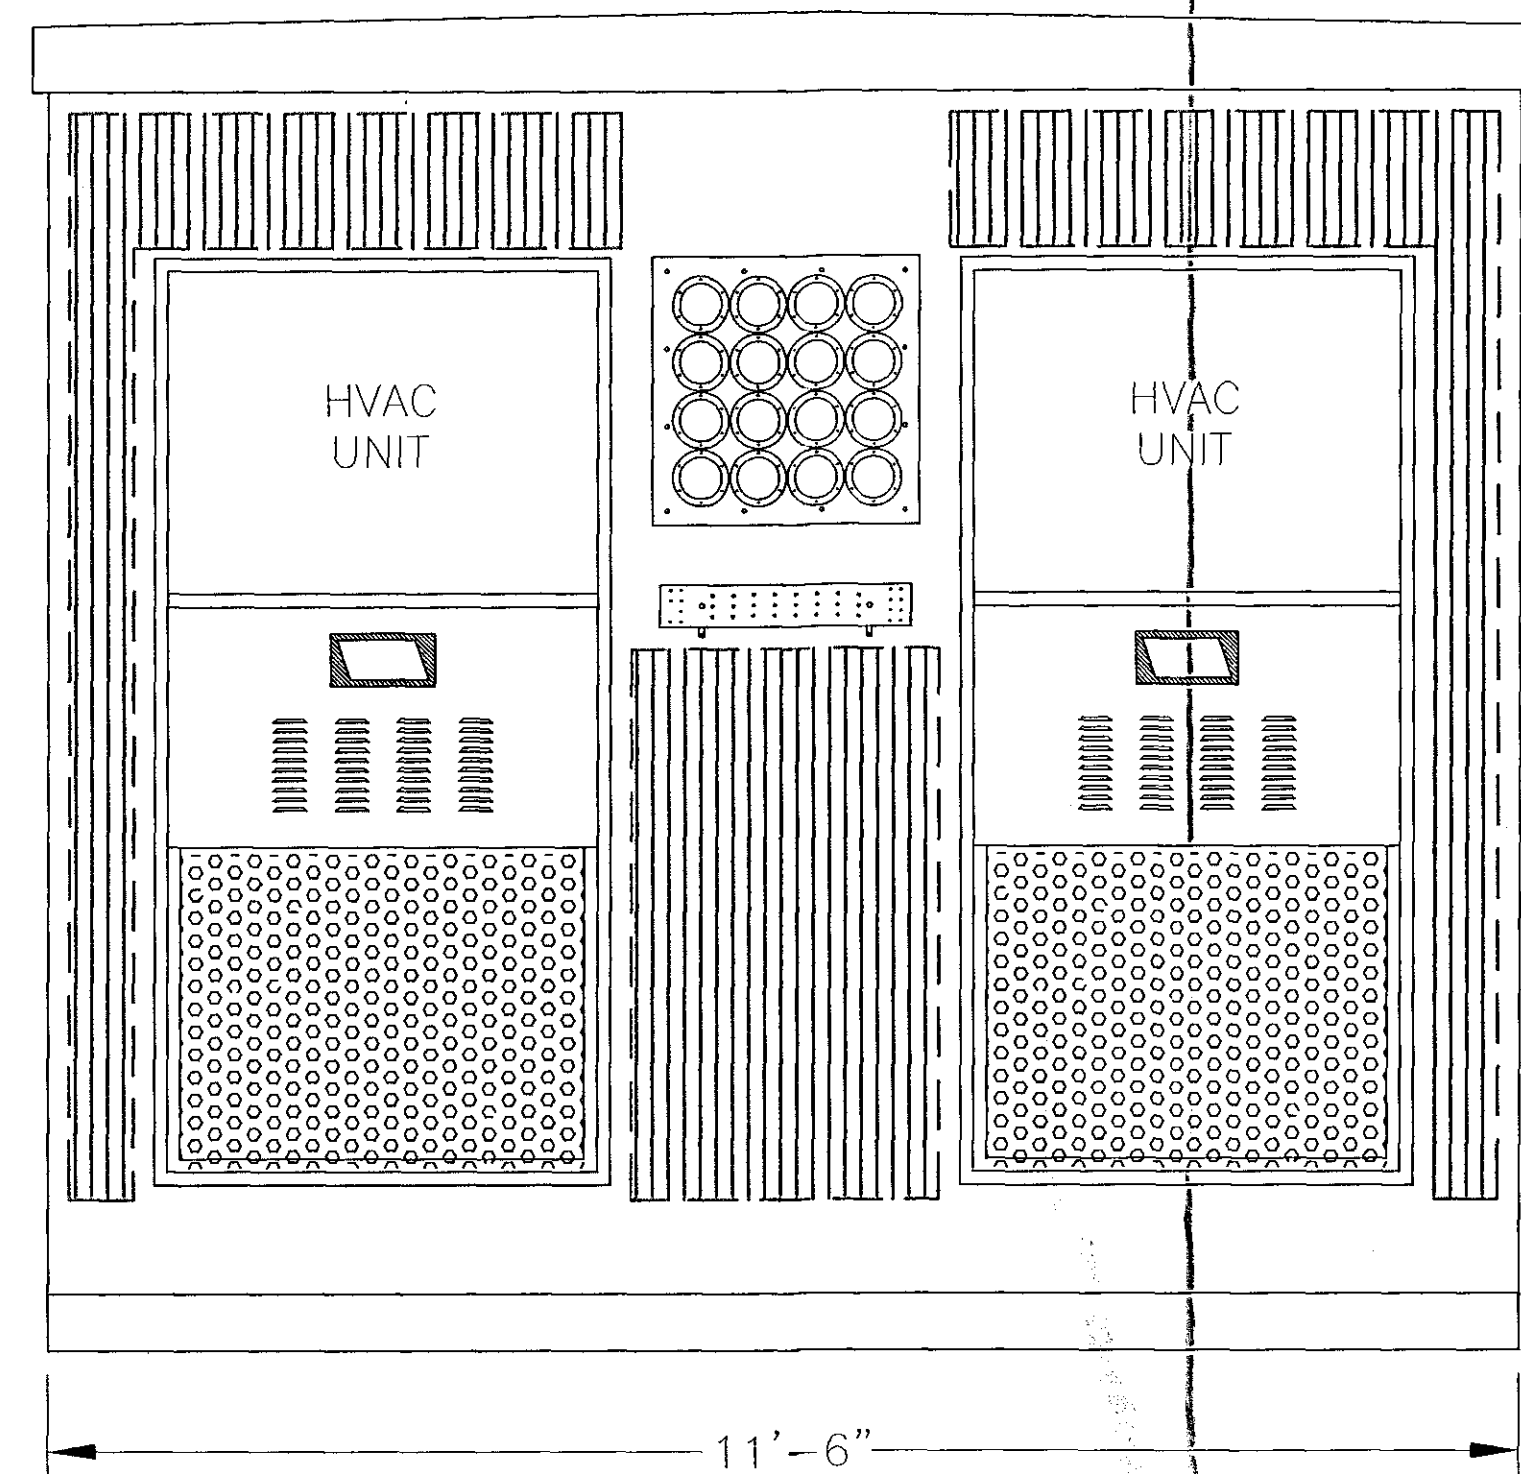

HVAC UNIT

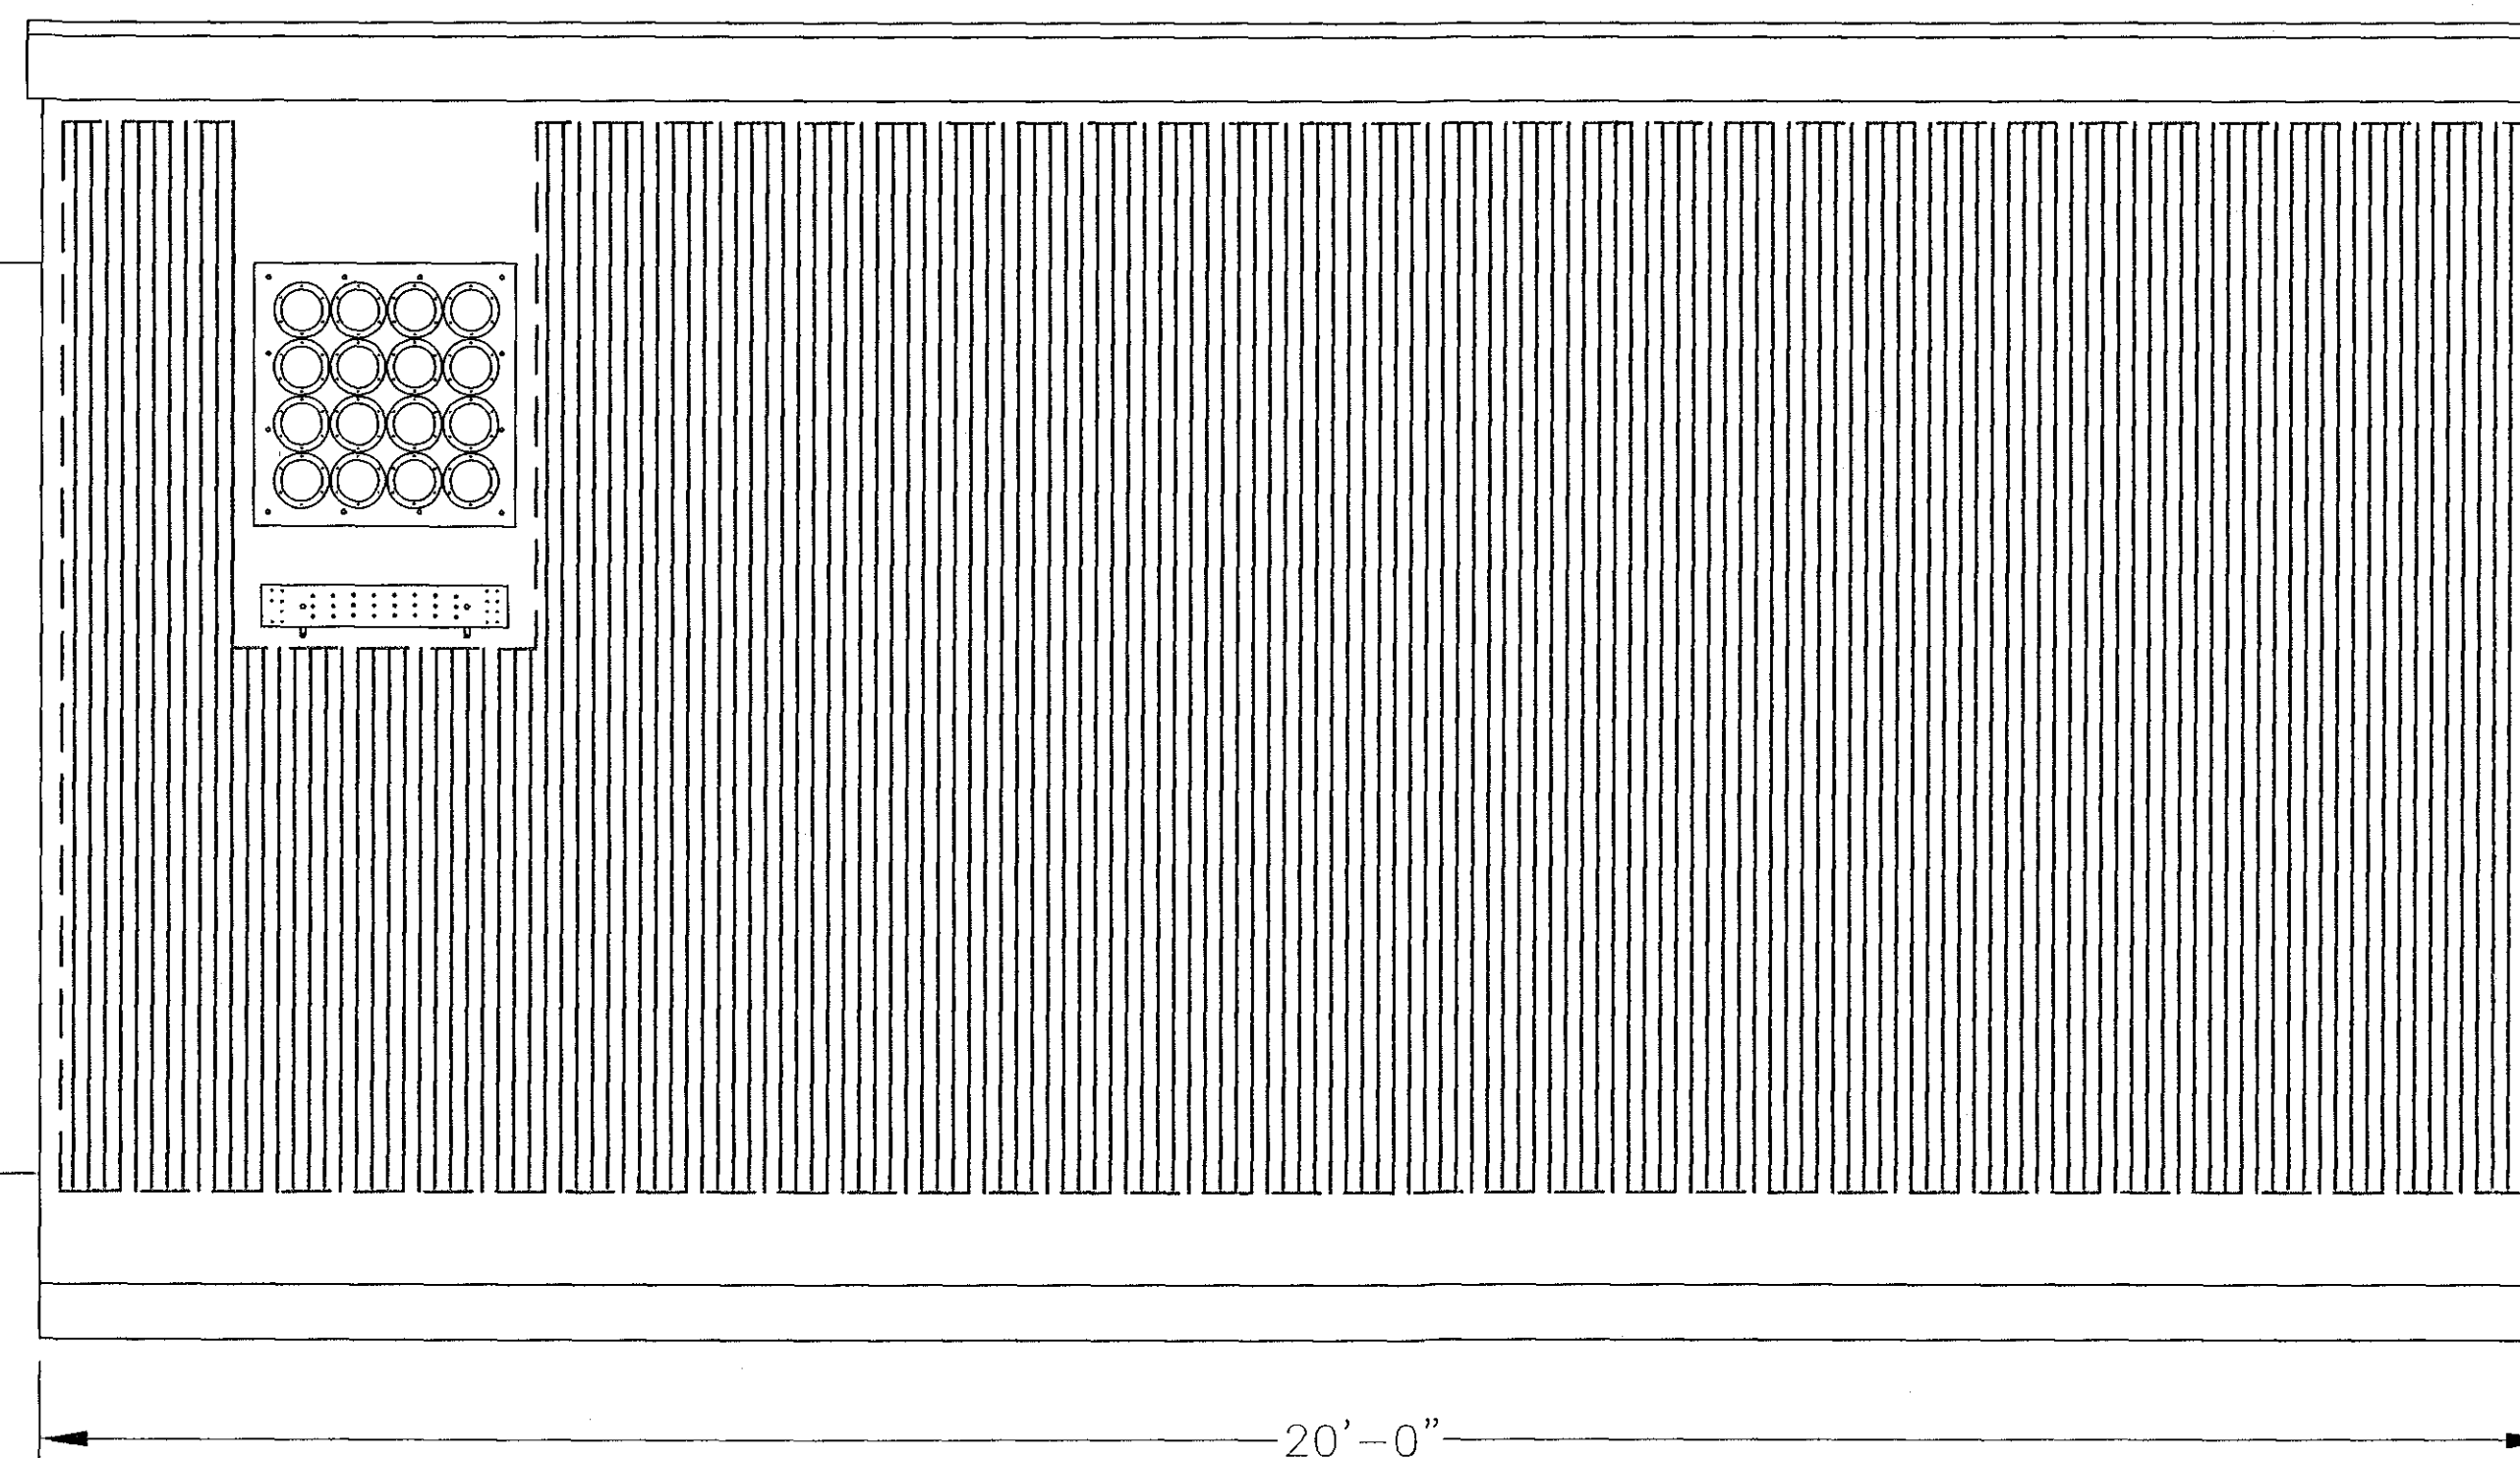

METER


GENERATOR RECEPTACLE

DUAL MOTION
SENSORED EXTERIOR
LIGHTING

METER


GENERATOR
RECEPTACLE

HVAC UNIT

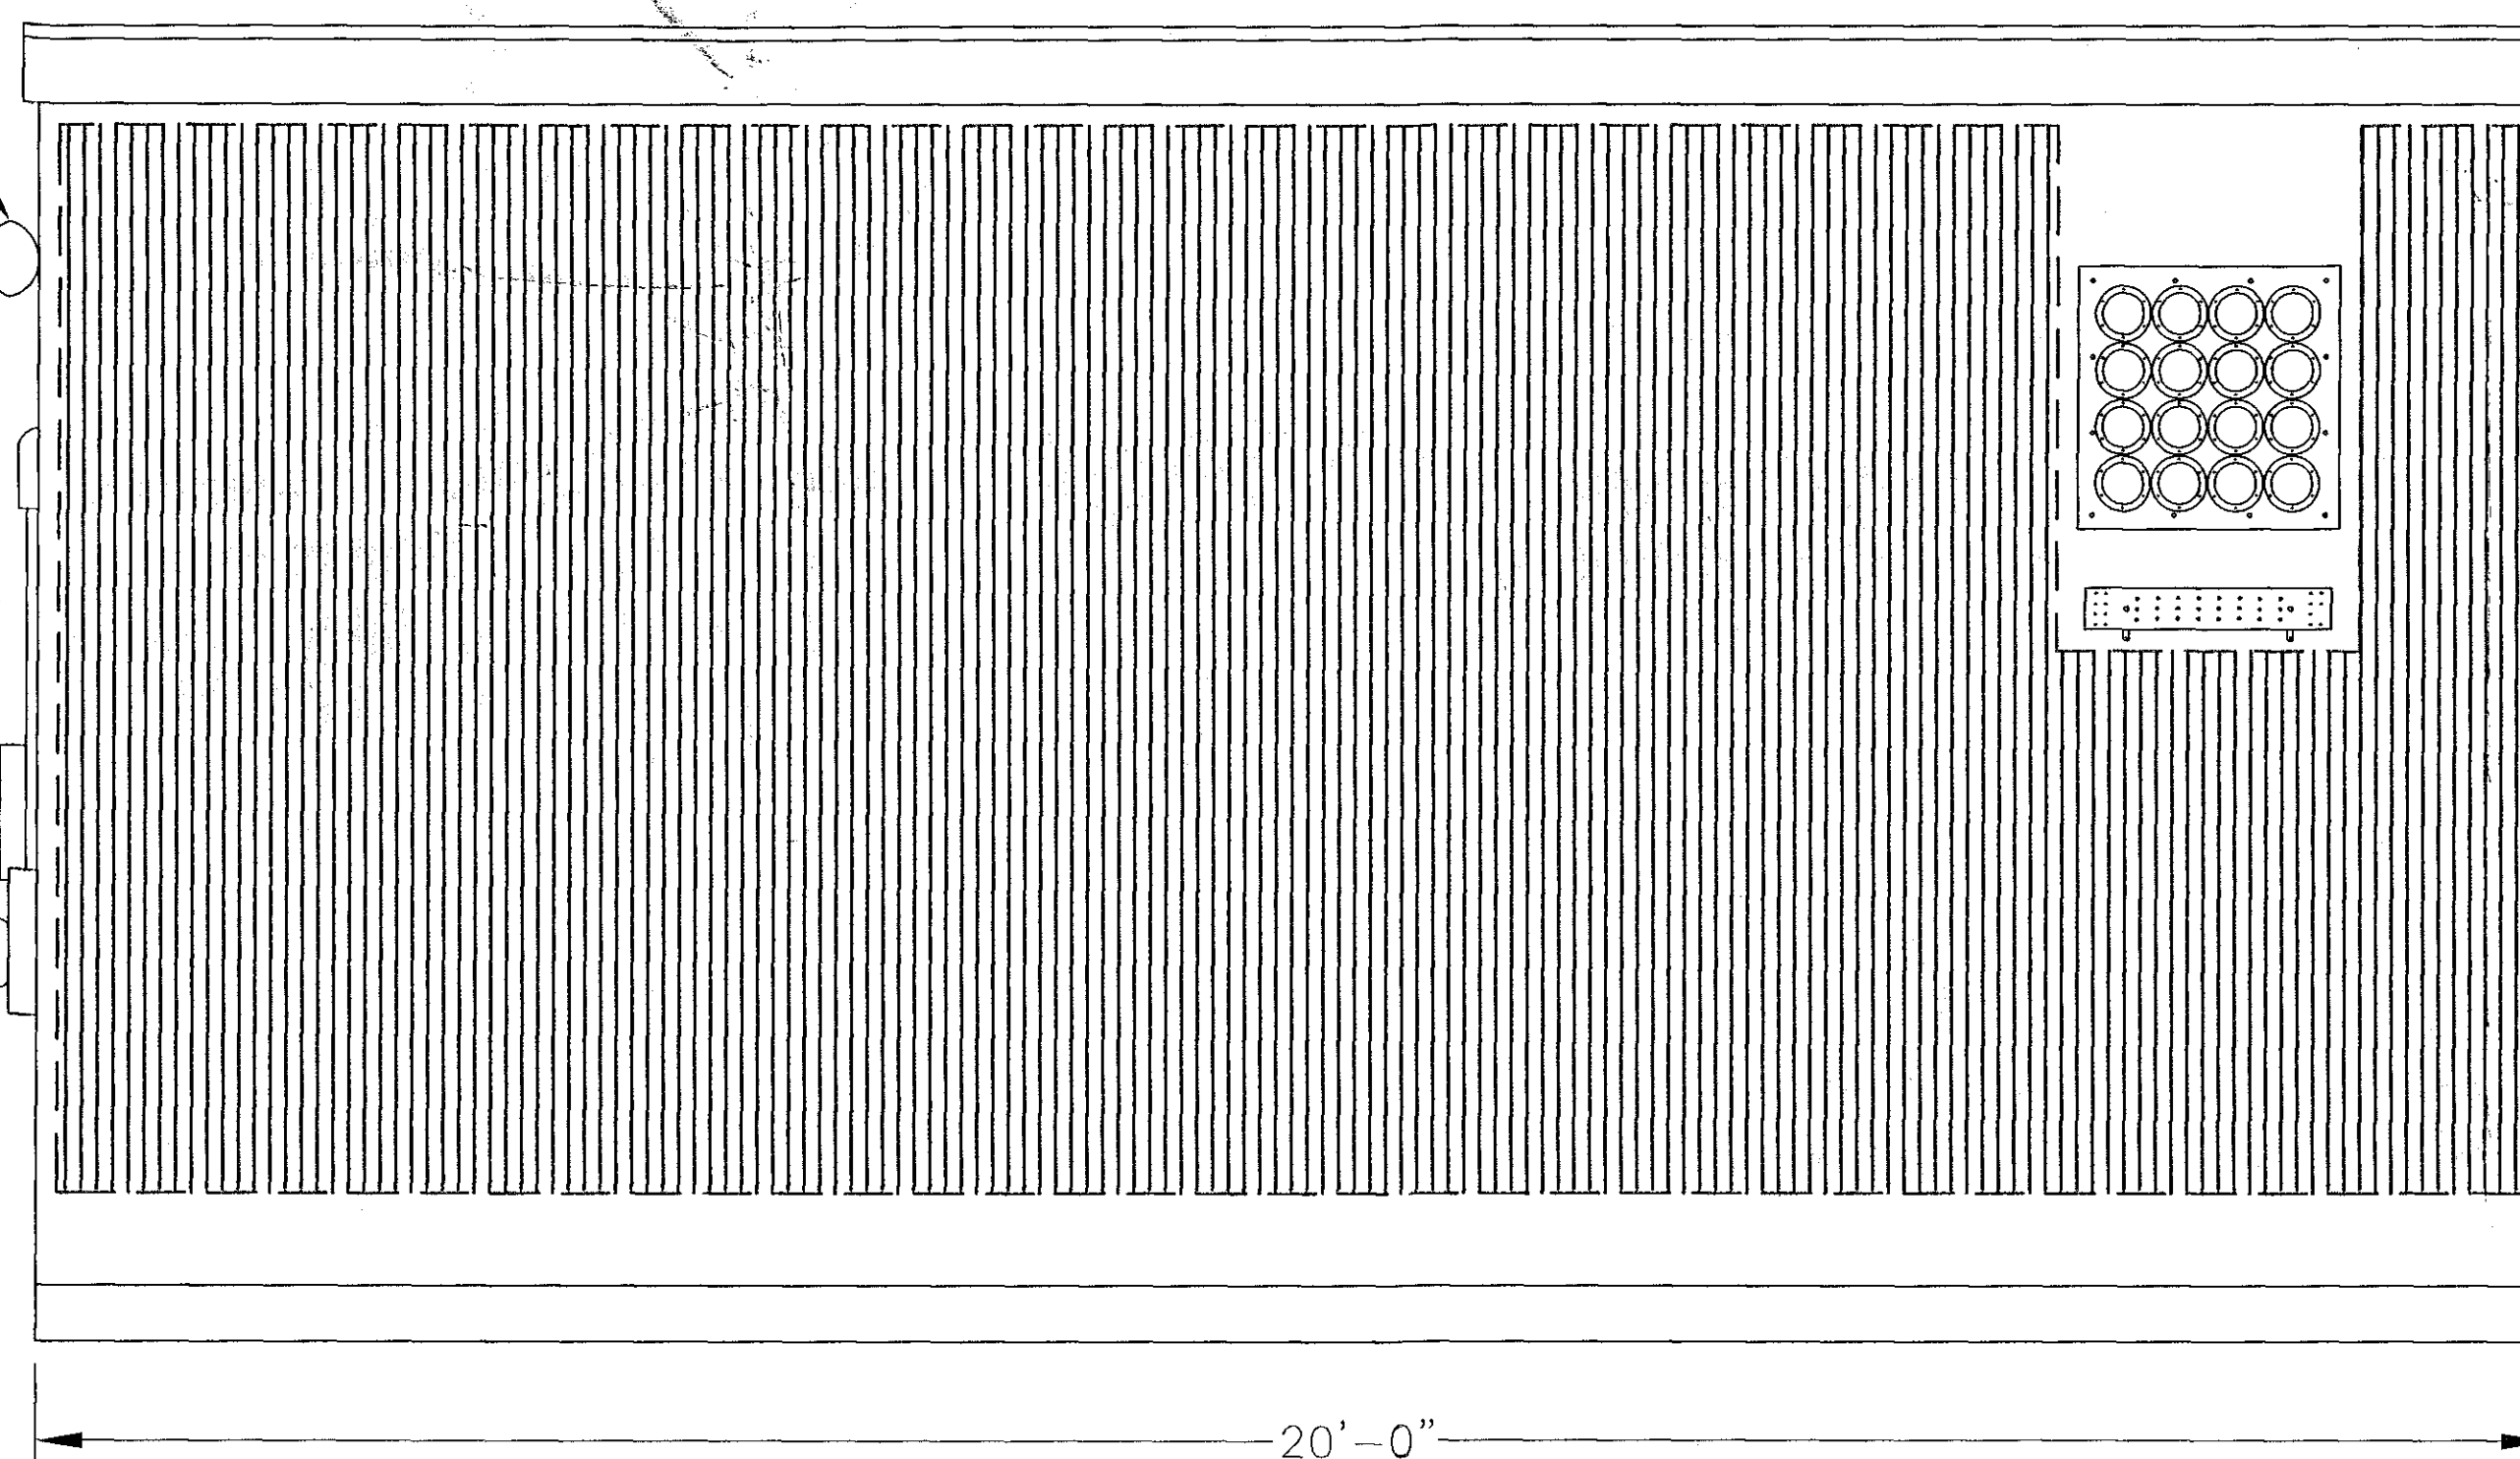

NOTE: THE SHELTER SHOWN IS OF A TYPICAL LAYOUT ONLY. CONTRACTOR TO REFER TO FINAL MANUFACTURER'S SHELTER DESIGN DRAWINGS FOR EXACT DIMENSIONS, EQUIPMENT LOCATIONS AND CONDUIT PENETRATIONS, ETC., PRIOR TO CONSTRUCTION.

at&t EQUIPMENT SHELTER N.T.S.

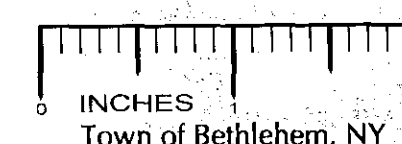

at&t WIRELESS
5841 BRIDGE STREET
EAST SYRACUSE, NY 13057

GENERAL DYNAMICS
Information Technology

77 "A" STREET
NEEDHAM, MA 02494
PHONE: (718) 455-4836

CICG CARPENTER
CONSULTING
GROUP
DEVELOPMENT DESIGN
RESIDENTIAL | COMMERCIAL | WIRELESS | ENERGY
17 Industrial Street | Rochester, NY 14614
Office: 585-360-2733 | Fax: 585-360-2735
www.carpentercg.com

IT IS A VIOLATION OF LAW FOR ANY PERSON UNLESS THEY ARE ACTING UNDER THE DIRECTION OF A LICENSED PROFESSIONAL ENGINEER TO ALTER THIS DOCUMENT, UNLESS EXPLICITLY AGREED TO BY THE ENGINEER IN WRITING. THE ENGINEER DISCLAIMS ALL LIABILITY ASSOCIATED WITH THE REUSE, ALTERATION OR MODIFICATION OF THE CONTENTS HEREIN.


DESIGNED BY:	DATE:
DRB	5/5/09
APPROVED BY:	A&E PROJECT #:
DWC	09-BV-172

REVISIONS		
12.	4/5/11	ROTATED AT&T SHELTER
11.	4/1/11	REVISED PER REDLINES
10.	3/30/11	REVISED PER REDLINES
9.	3/3/11	REVISED PER REDLINES
8.	2/7/11	REVISED PER REDLINES
7.	2/3/11	REVISED PER REDLINES
NO.	DATE	DESCRIPTION

RECEIVED

MAY 2 2011

Town of Bethlehem
Planning Board

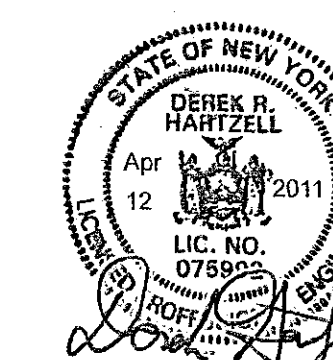

PLANNING BOARD
TOWN OF BETHLEHEM
ALBANY COUNTY, NEW YORK
This Site Plan Approved.
[Signature]
Title: *[Signature]*
Date: MAY 12, 2011 SEA 170 (SUPP)

SITE NAME:	ESCO TOWER DELMAR-VAN DYKE ROAD
SITE NUMBER:	A-04-010
SITE ADDRESS:	75 VAN DYKE ROAD DELMAR, NEW YORK 12054
SITE TYPE:	RAW LAND

SHEET TITLE:	at&t SHELTER DETAILS
DRAWING #	Z9
REVISION:	12