
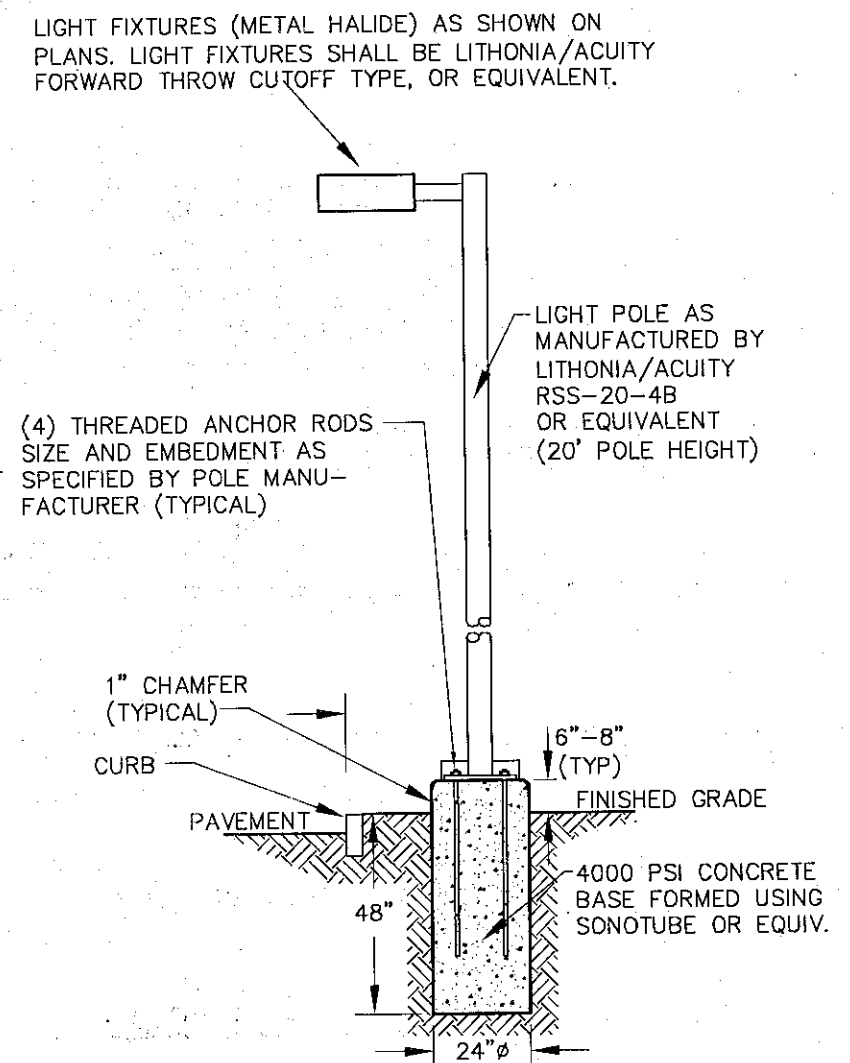
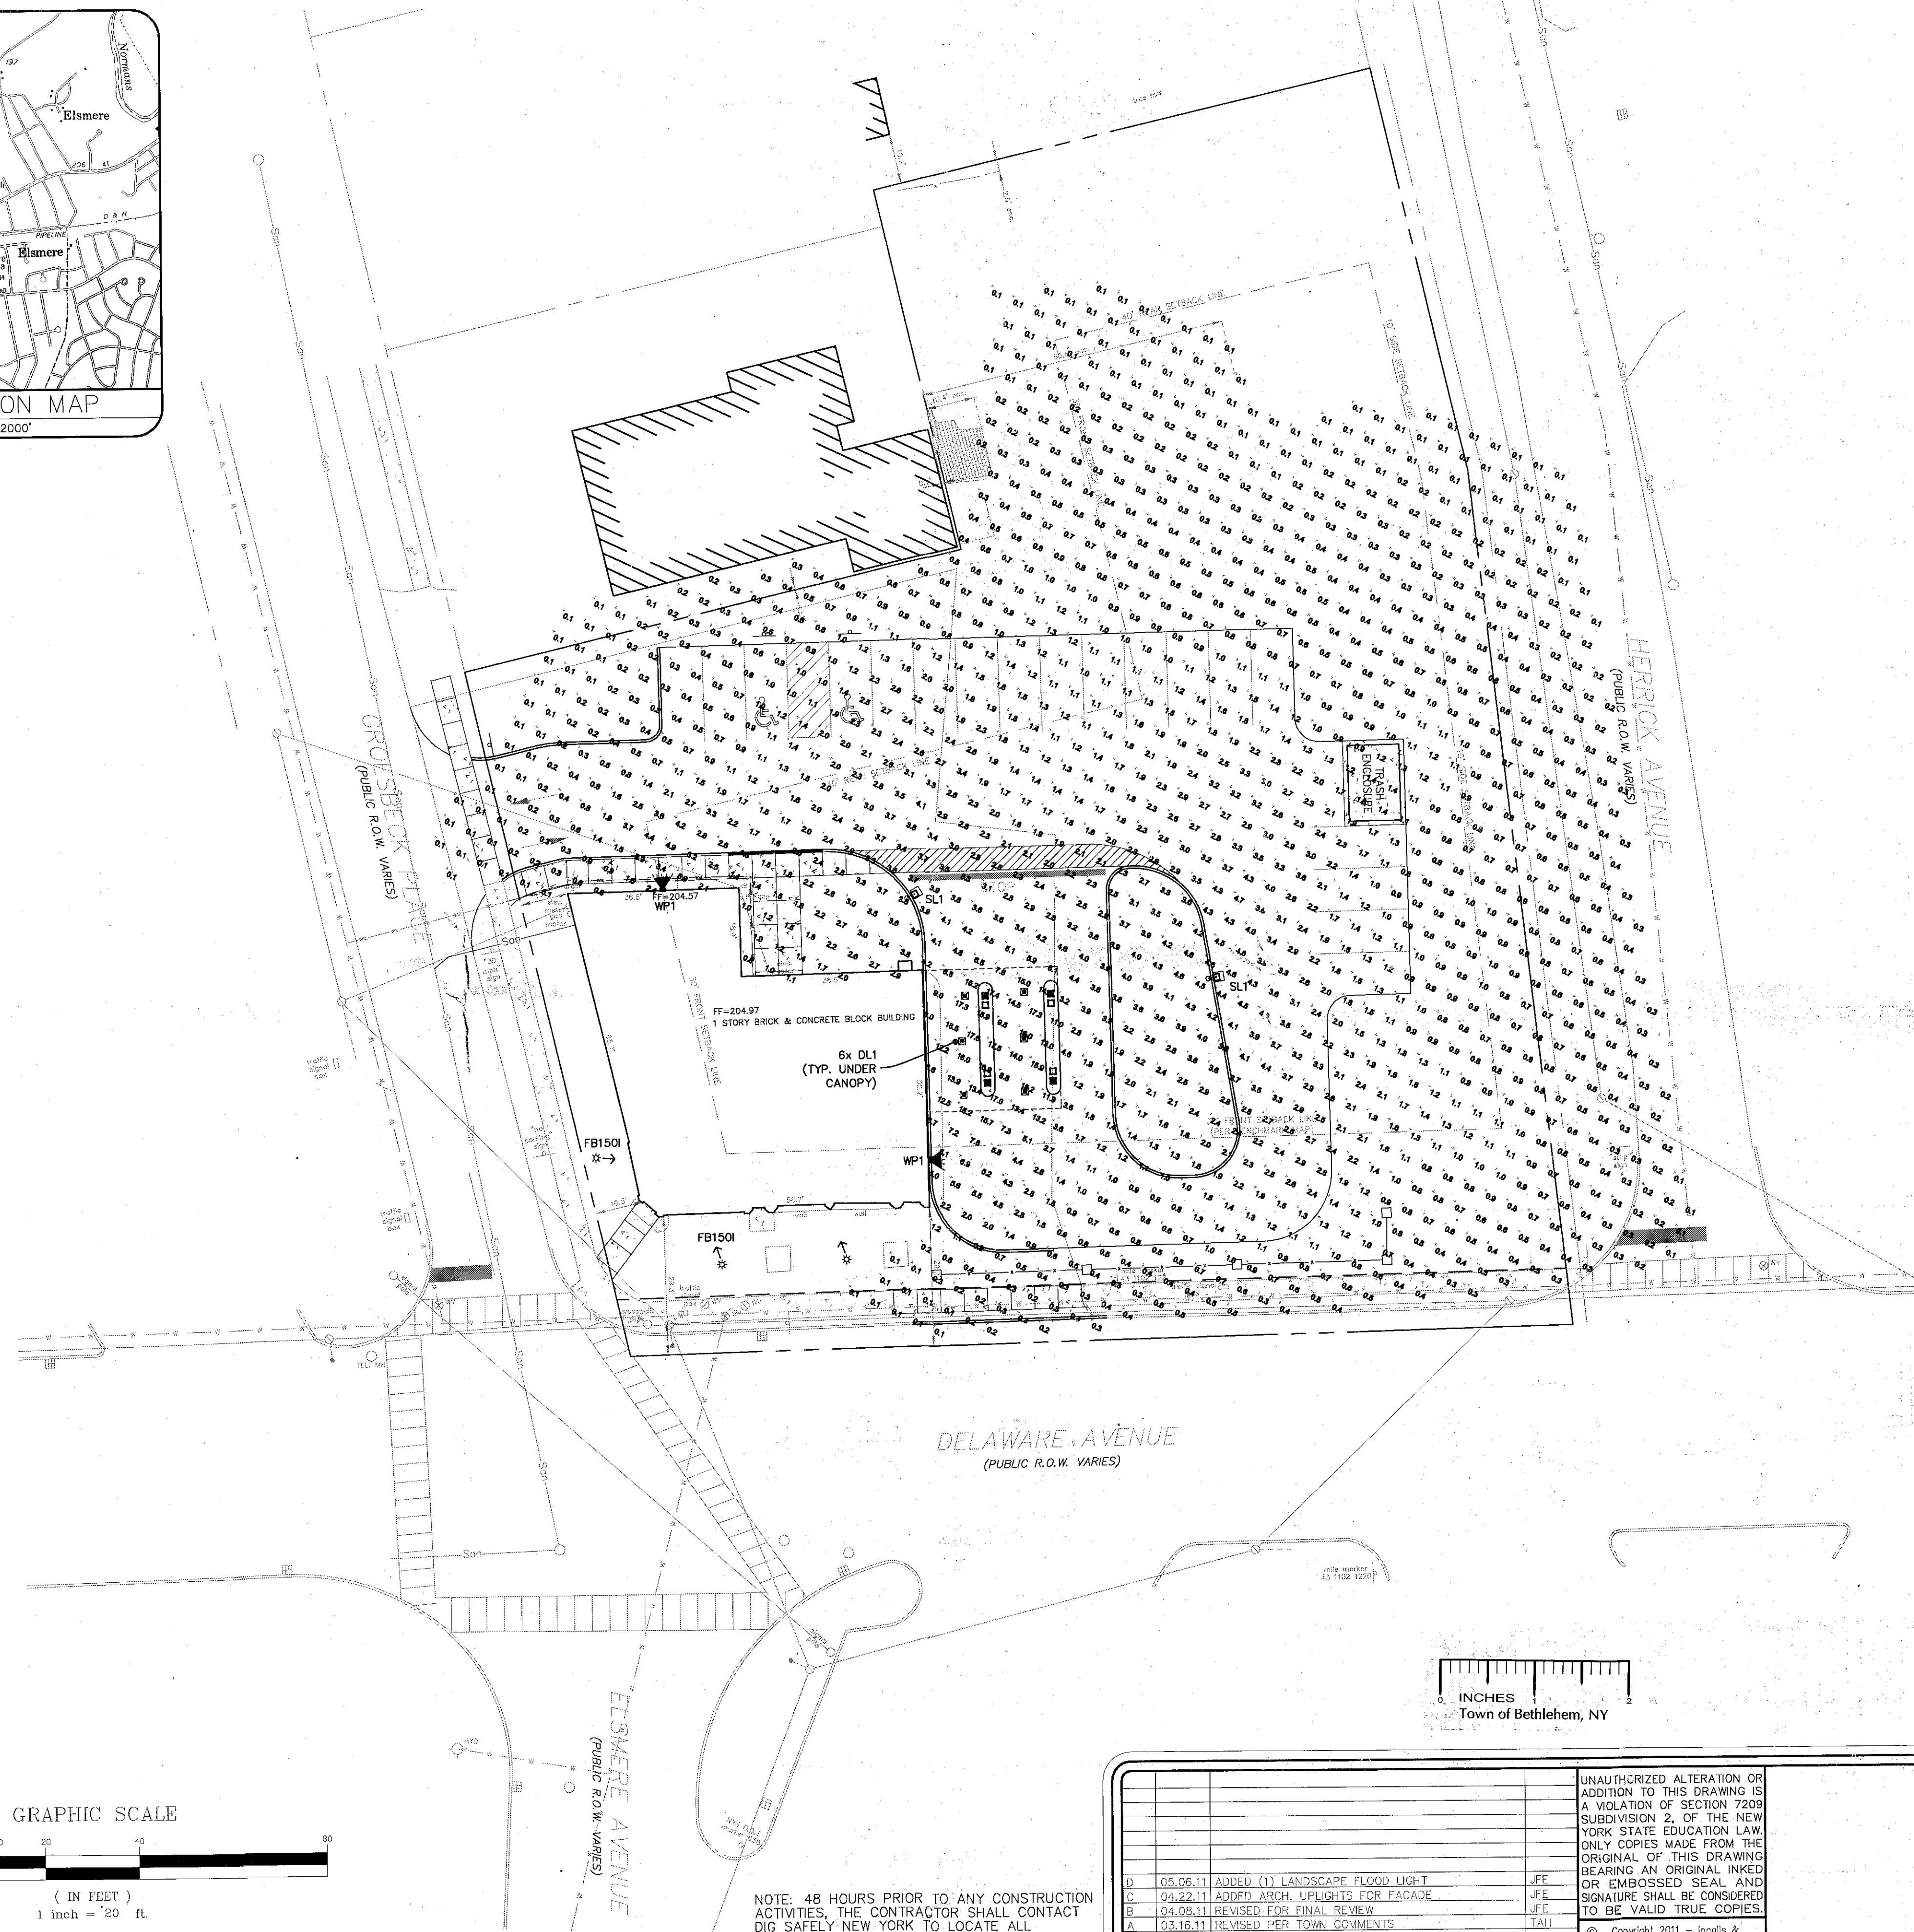


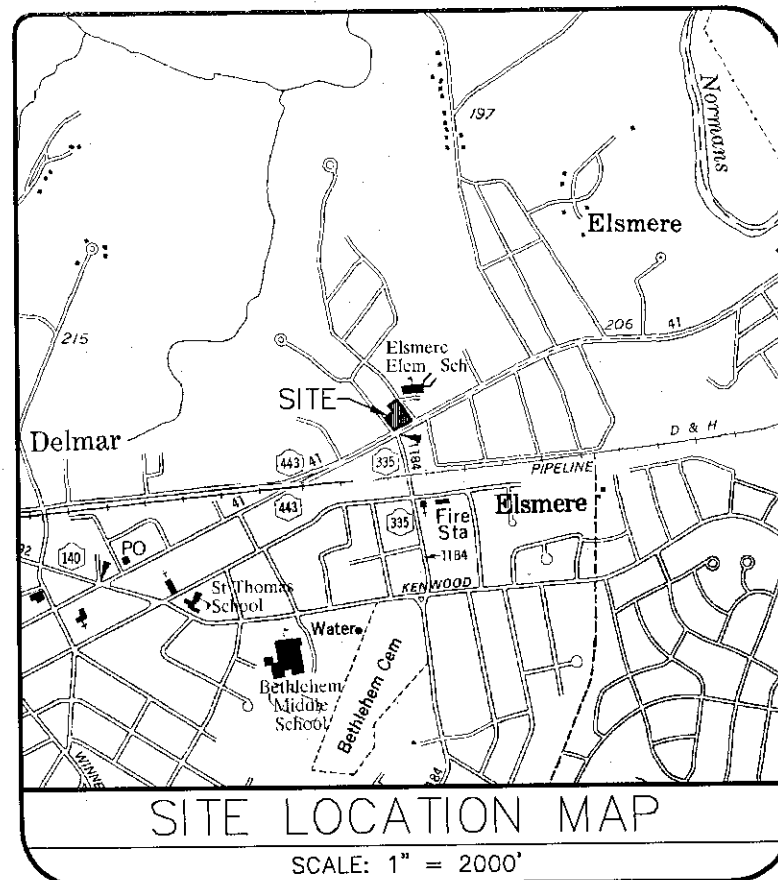


TYPICAL LIGHT POLE INSTALLATION
NOT TO SCALE

- LEGEND
- PROPOSED LIGHT POLE
 - ◀ PROPOSED WALL LIGHT
 - ★ PROPOSED ARCHITECTURAL FLOODLIGHT

Label	Catalog Number	Description
SL1	KSF2 400M R4W	Specification Area Luminaire, 400W Metal Halide, R4 Wide Reflector, Full Cutoff. MEETS THE 'NIGHTTIME FRIENDLY' CRITERIA
DL1	LP8HN 100M 120/277 8L4	8" HID LENSED DOWNLIGHT WITH 8L4 TRIM
WP1	WST 100M FT	ARCHITECTURAL SCENCE WITH FORWARD THROW DISTRIBUTION WITH CLEAR FLAT GLASS LENS. CLEAR LAMP. MEETS THE 'NIGHTTIME FRIENDLY' CRITERIA
FB1501	FB1501 M12	CONTRACTOR SELECT LANDSCAPE FLOODLIGHT WITH LFP POST

Label	Lamp	File	Lamp Lumens	LLF	Watts
SL1	ONE 400 WATT CLEAR ED28 PULSE START METAL HALIDE IN HORIZONTAL POSITION	KSF2_400M_R4W.ies	38000	0.81	456
	ONE 100-WATT COATED ED17 PROTECTED METAL HALIDE, VERTICAL BASE UP POS.	LP8HN_100M_120_277_8L4.ies	7500	0.81	125
WP1	ONE 100-WATT CLEAR ED-17 METAL HALIDE, HORIZONTAL POSITION.	WST_100M_FT.ies	7500	0.81	125

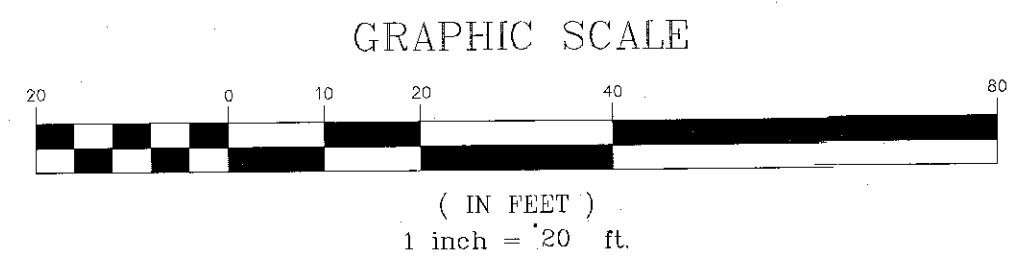


NOTE: 48 HOURS PRIOR TO ANY CONSTRUCTION ACTIVITIES, THE CONTRACTOR SHALL CONTACT DIG SAFELY NEW YORK TO LOCATE ALL UNDERGROUND UTILITIES. 1-800-962-7962

NO.	DATE	REVISIONS	BY
1	05.06.11	ADDED (1) LANDSCAPE FLOOD LIGHT	JFE
2	04.22.11	ADDED ARCH. UPLIGHTS FOR FACADE	JFE
3	04.08.11	REVISED FOR FINAL REVIEW	JFE
4	03.16.11	REVISED PER TOWN COMMENTS	TAH

UNAUTHORIZED ALTERATION OR ADDITION TO THIS DRAWING IS A VIOLATION OF SECTION 2209 SUBDIVISION 2, OF THE NEW YORK STATE EDUCATION LAW. ONLY COPIES MADE FROM THE ORIGINAL OF THIS DRAWING BEARING AN ORIGINAL INKED OR EMBOSSED SEAL AND SIGNATURE SHALL BE CONSIDERED TO BE VALID TRUE COPIES.

© Copyright 2011 - Ingalls & Associates, LLP - All rights reserved

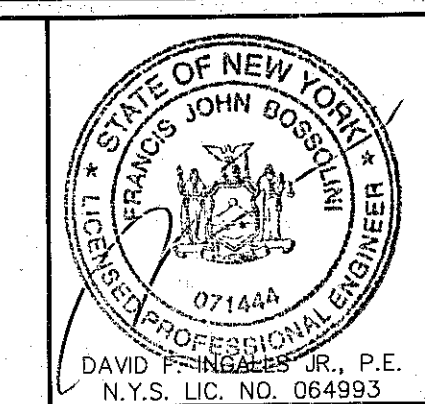

ingalls
ingalls & associates, LLP
engineers / surveyors
2603 GUILDFORD AVENUE
SCHENECTADY, N.Y. 12306
PHONE: (518) 393-7725
FAX: (518) 393-2324

LIGHTING PLAN
BERKSHIRE BANK
255 DELAWARE AVE
TOWN OF BETHLEHEM
ALBANY COUNTY STATE OF NEW YORK

DATE: JANUARY, 2011
CHECKED BY: DF1
JOB NO. 10-116
DRAWN BY: TAH
CADD FILE: 10-116DF

SCALE: 1" = 20'
SHEET 3 OF 6

RECEIVED
JUN 16 2011
Town of Bethlehem
Planning Board

PLANNING BOARD
TOWN OF BETHLEHEM
ALBANY COUNTY, NEW YORK
This Site Plan Approved:
George J. Finner
Title: CHAIRMAN
Date: 6/23/2011 SPAT13
PLANNING BOARD APPROVAL