



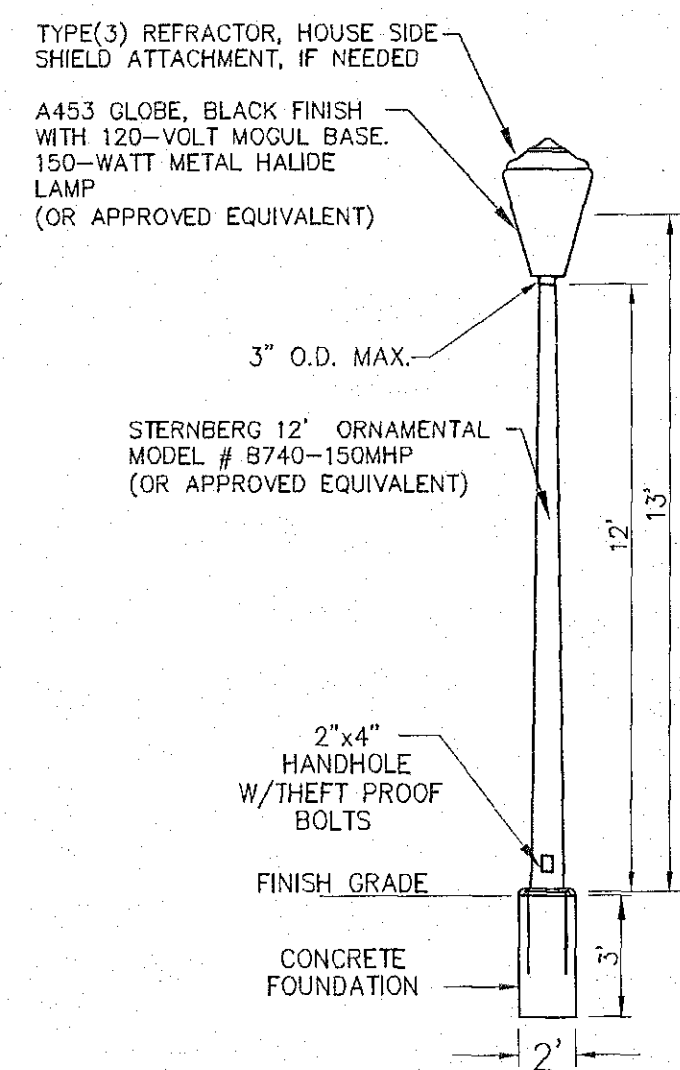

1
5 POLE MOUNTED LIGHT
NOT TO SCALE

NOTES:
1. NORTHERN AND SOUTHERN MOST FIXTURES SHALL HAVE SIDE SHIELDS.

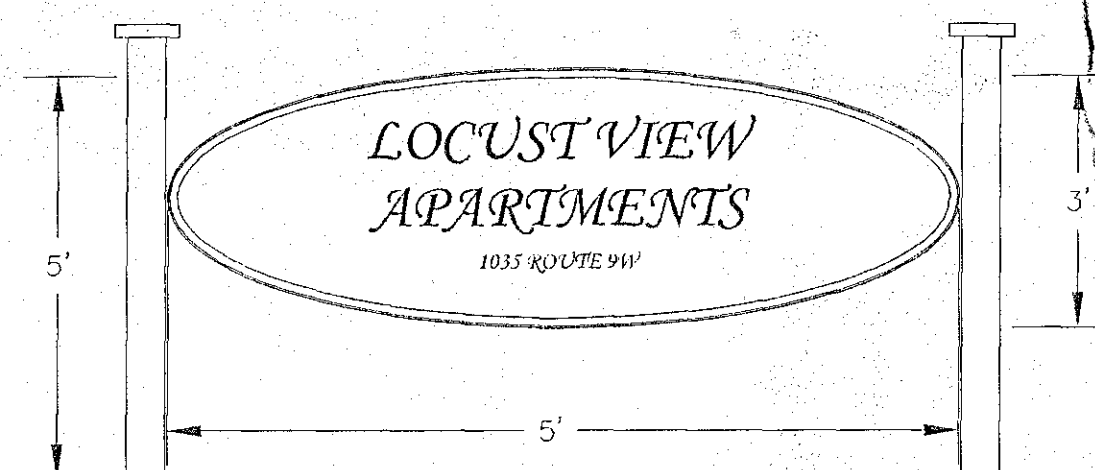

2
5 ENTRANCE SIGN
NOT TO SCALE

NOTES:
1. COLOR SCHEME TO BE NATURAL GREEN LETTERING WITH GOLD BACKGROUND
2. SIGN TO BE WOOD AND POSTS TO BE 4"x4" TIMBER
3. SIGN TO BE 3'x5' ELLIPTICAL SHAPE, APPROX. 11.8 SF
4. SIGN TO BE ILLUMINATED WITH GROUND-MOUNTED LANDSCAPE STYLE FLOODLIGHTS.
5. SIGN LIGHTING SHALL BE DIRECTED SO AS TO NOT CAUSE GLARE FOR ADJOINING PROPERTIES OR MOTORISTS. WHAT CONSTITUTES GLARE SHALL BE A DETERMINATION OF THE TOWN BUILDING INSPECTOR, WHO MAY REQUIRE THAT SAID LIGHTING BE REDIRECTED AND/OR REDUCED IN INTENSITY TO SATISFY THIS CONDITION.

LIGHTING SCHEDULE					
SYMBOL	TYPE	MODEL	WATTAGE	QUANTITY	HEIGHT
	POLE MOUNTED	STERNBERG B740-150MHP	150	5	12'
	WALL MOUNTED	WST 100MHC	100	19	7'
	FLOOD LIGHTING	P/N FB150	150	2	1'

NOTES:
1) MODEL AS NOTED OR APPROVED EQUAL
2) FIXTURE LOCATION IS SHOWN ON THE LIGHTING PLAN, THIS SHEET
3) FIXTURE AIMING POINT DEPICTED BY SYMBOL IF APPLICABLE
4) PARKING LOT LUMINAIRE LEVELS:
MAXIMUM - 3.9 ISOFOOTCANDELS
MINIMUM - 0.4 ISOFOOTCANDELS
AVERAGE - 1.7 ISOFOOTCANDELS
UNIFORMITY RATIO - .24


LEGEND	
PROPERTY LINE	---
EXISTING CONTOUR	---420---
EXISTING STREAM	---
EXISTING WATER LINE	---
EXISTING SANITARY SEWER	---
EXISTING SANITARY MANHOLE	○
FLOODPLAIN BOUNDARY	---
20% SLOPES OR GREATER	---
EXISTING WETLANDS	---
EXISTING TREELINE	---
PROPOSED CLEARING LIMITS	---
PROPOSED WATER LINE	---
PROPOSED FIRE HYDRANT	---
PROPOSED STORM SEWER	---
PROPOSED ILLUMINATION CONTOUR	0.25
PROPOSED LIGHT POLE	---
PROPOSED WALL LIGHT	---

ALBANY COUNTY DEPARTMENT OF HEALTH
DIVISION OF ENVIRONMENTAL HEALTH SERVICES
By direction of the Commissioner of Health, these plans are hereby approved. See first sheet for date and signature.

Town of Bethlehem Planning Board
By direction of the Chairman
these plans are hereby Approved.
See first sheet for date & signature.


PLANNING BOARD APPROVAL

NOTE: 48 HOURS PRIOR TO ANY CONSTRUCTION ACTIVITIES, THE CONTRACTOR SHALL CONTACT DIG SAFELY NEW YORK TO LOCATE ALL UNDERGROUND UTILITIES. 1-800-962-7962

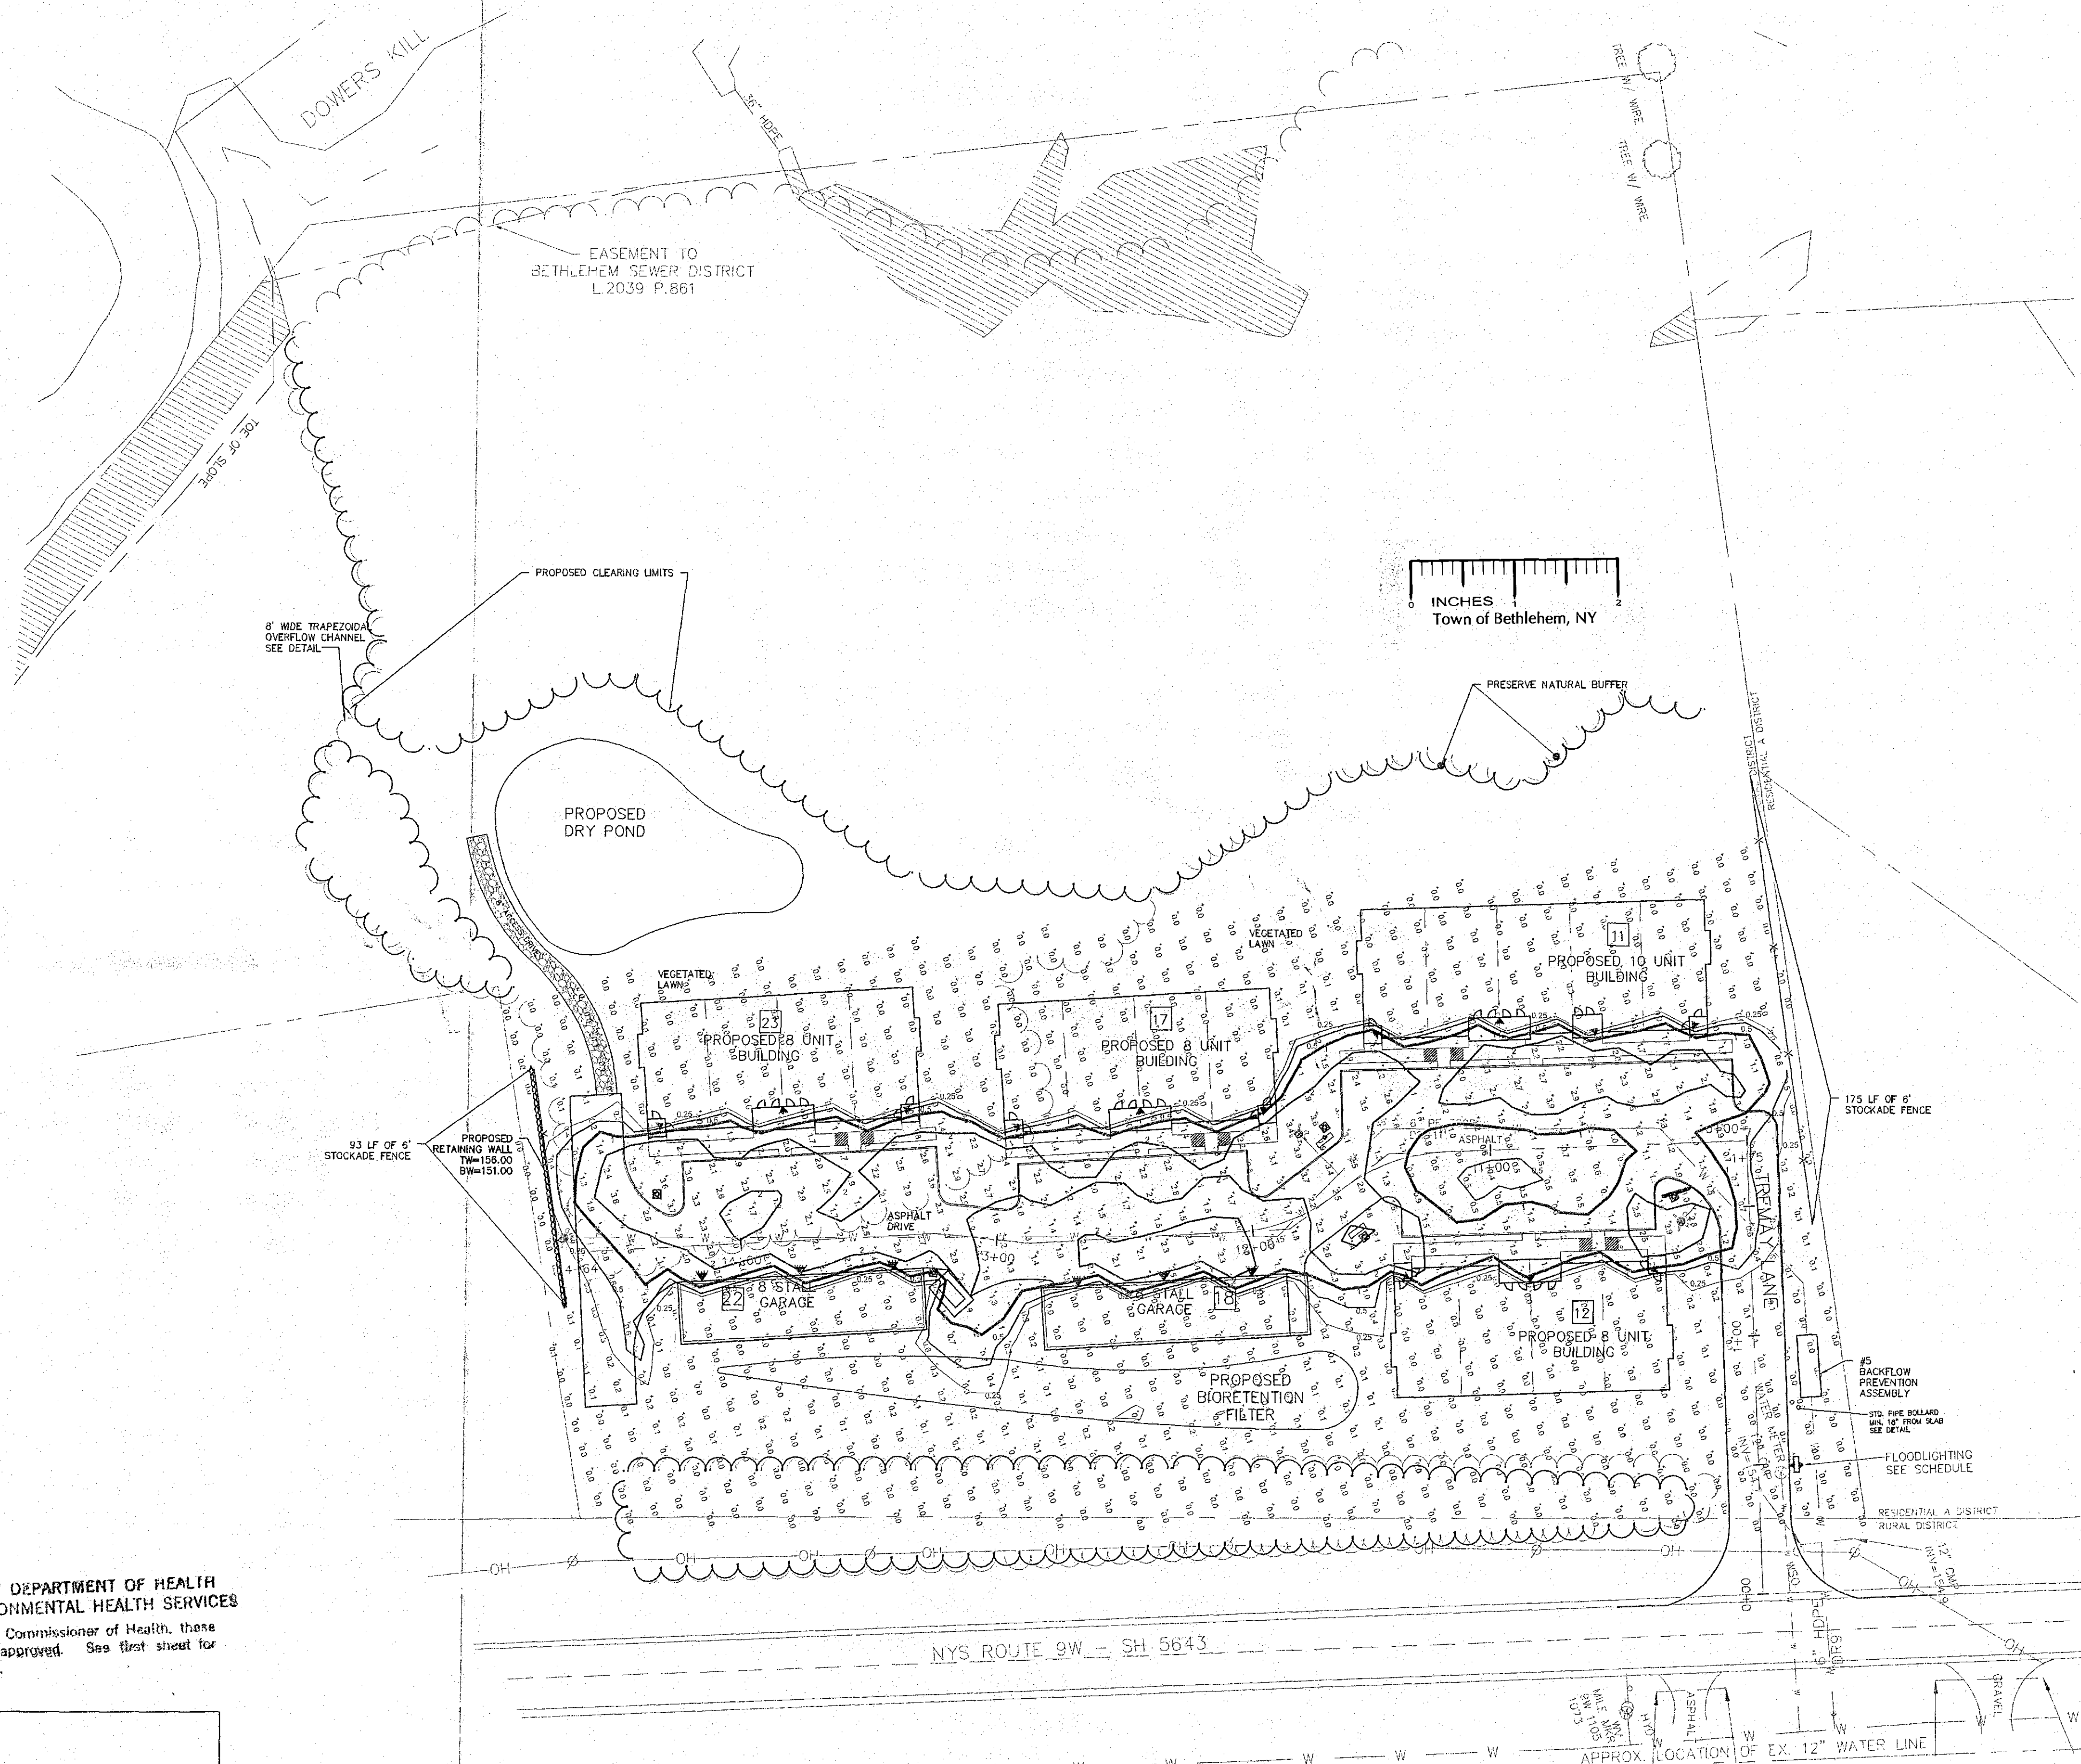

NO.	DATE	REVISIONS PER FINAL TOWN COMMENTS	CDL	BY
1	6/6/12	REVISIONS PER FINAL TOWN COMMENTS	CDL	BY

UNAUTHORIZED ALTERATION OR ADDITION TO THIS DRAWING IS A VIOLATION OF SECTION 7209 SUBDIVISION 2, OF THE NEW YORK STATE EDUCATION LAW. ONLY COPIES MADE FROM THE ORIGINAL OF THIS DRAWING BEARING AN ORIGINAL INKED OR EMBOSSED SEAL AND SIGNATURE SHALL BE CONSIDERED TO BE VALID TRUE COPIES.

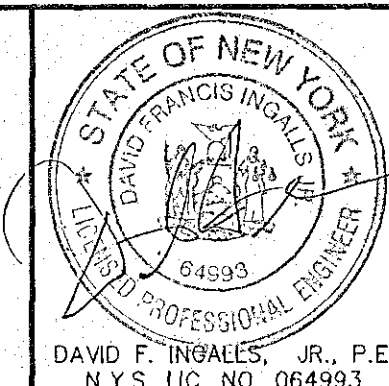

ingalls

ingalls & associates, LLP
engineers / surveyors
2023 GULFVIEW AVENUE
SCHENECTADY, N.Y. 12306
PHONE: (518) 393-7725
FAX: (518) 393-6224

LIGHTING PLAN		
1035 ROUTE 9W LOCUST VIEW APARTMENTS		
TOWN OF BETHLEHEM COUNTY OF ALBANY STATE OF NEW YORK		
DATE APRIL 13, 2012	CHECKED BY: D.F.I. JOB NO. 10-084	SCALE: 1" = 40'
DRAWN BY: C.D.L. CADD FILE: PLOT.DWG	SHEET 5 OF 10	