



605 FEURA BUSH ROAD
TOWN OF BETHLEHEM
ALBANY COUNTY, STATE OF NEW YORK

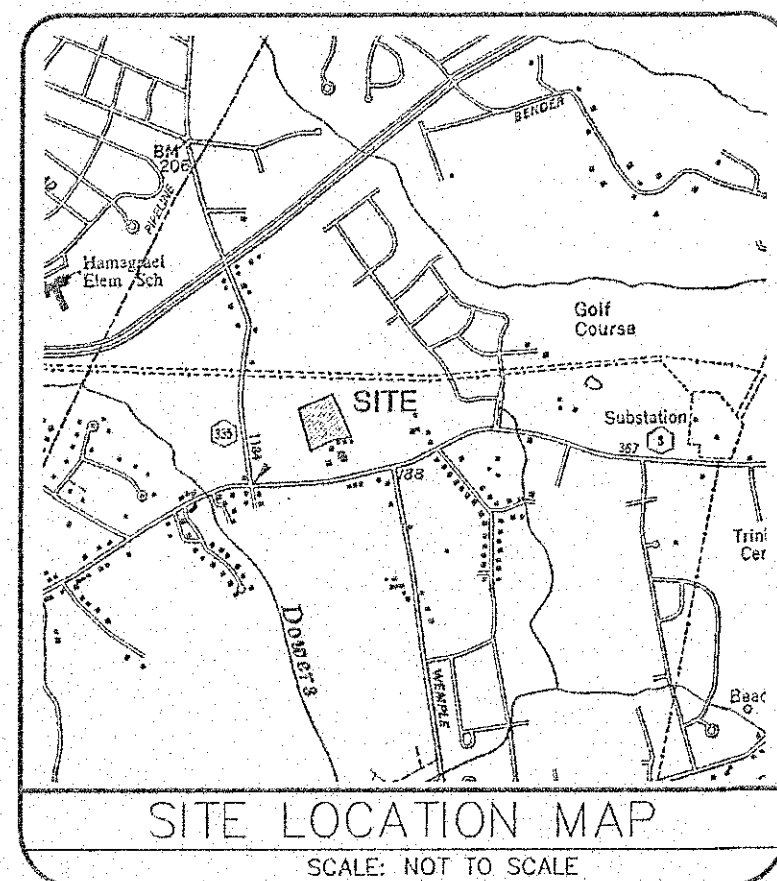

APPLICANT:
FEURA BUSH DEVELOPMENT, LLC
2603 GUILDERLAND AVENUE
SCHENECTADY, NY 12306

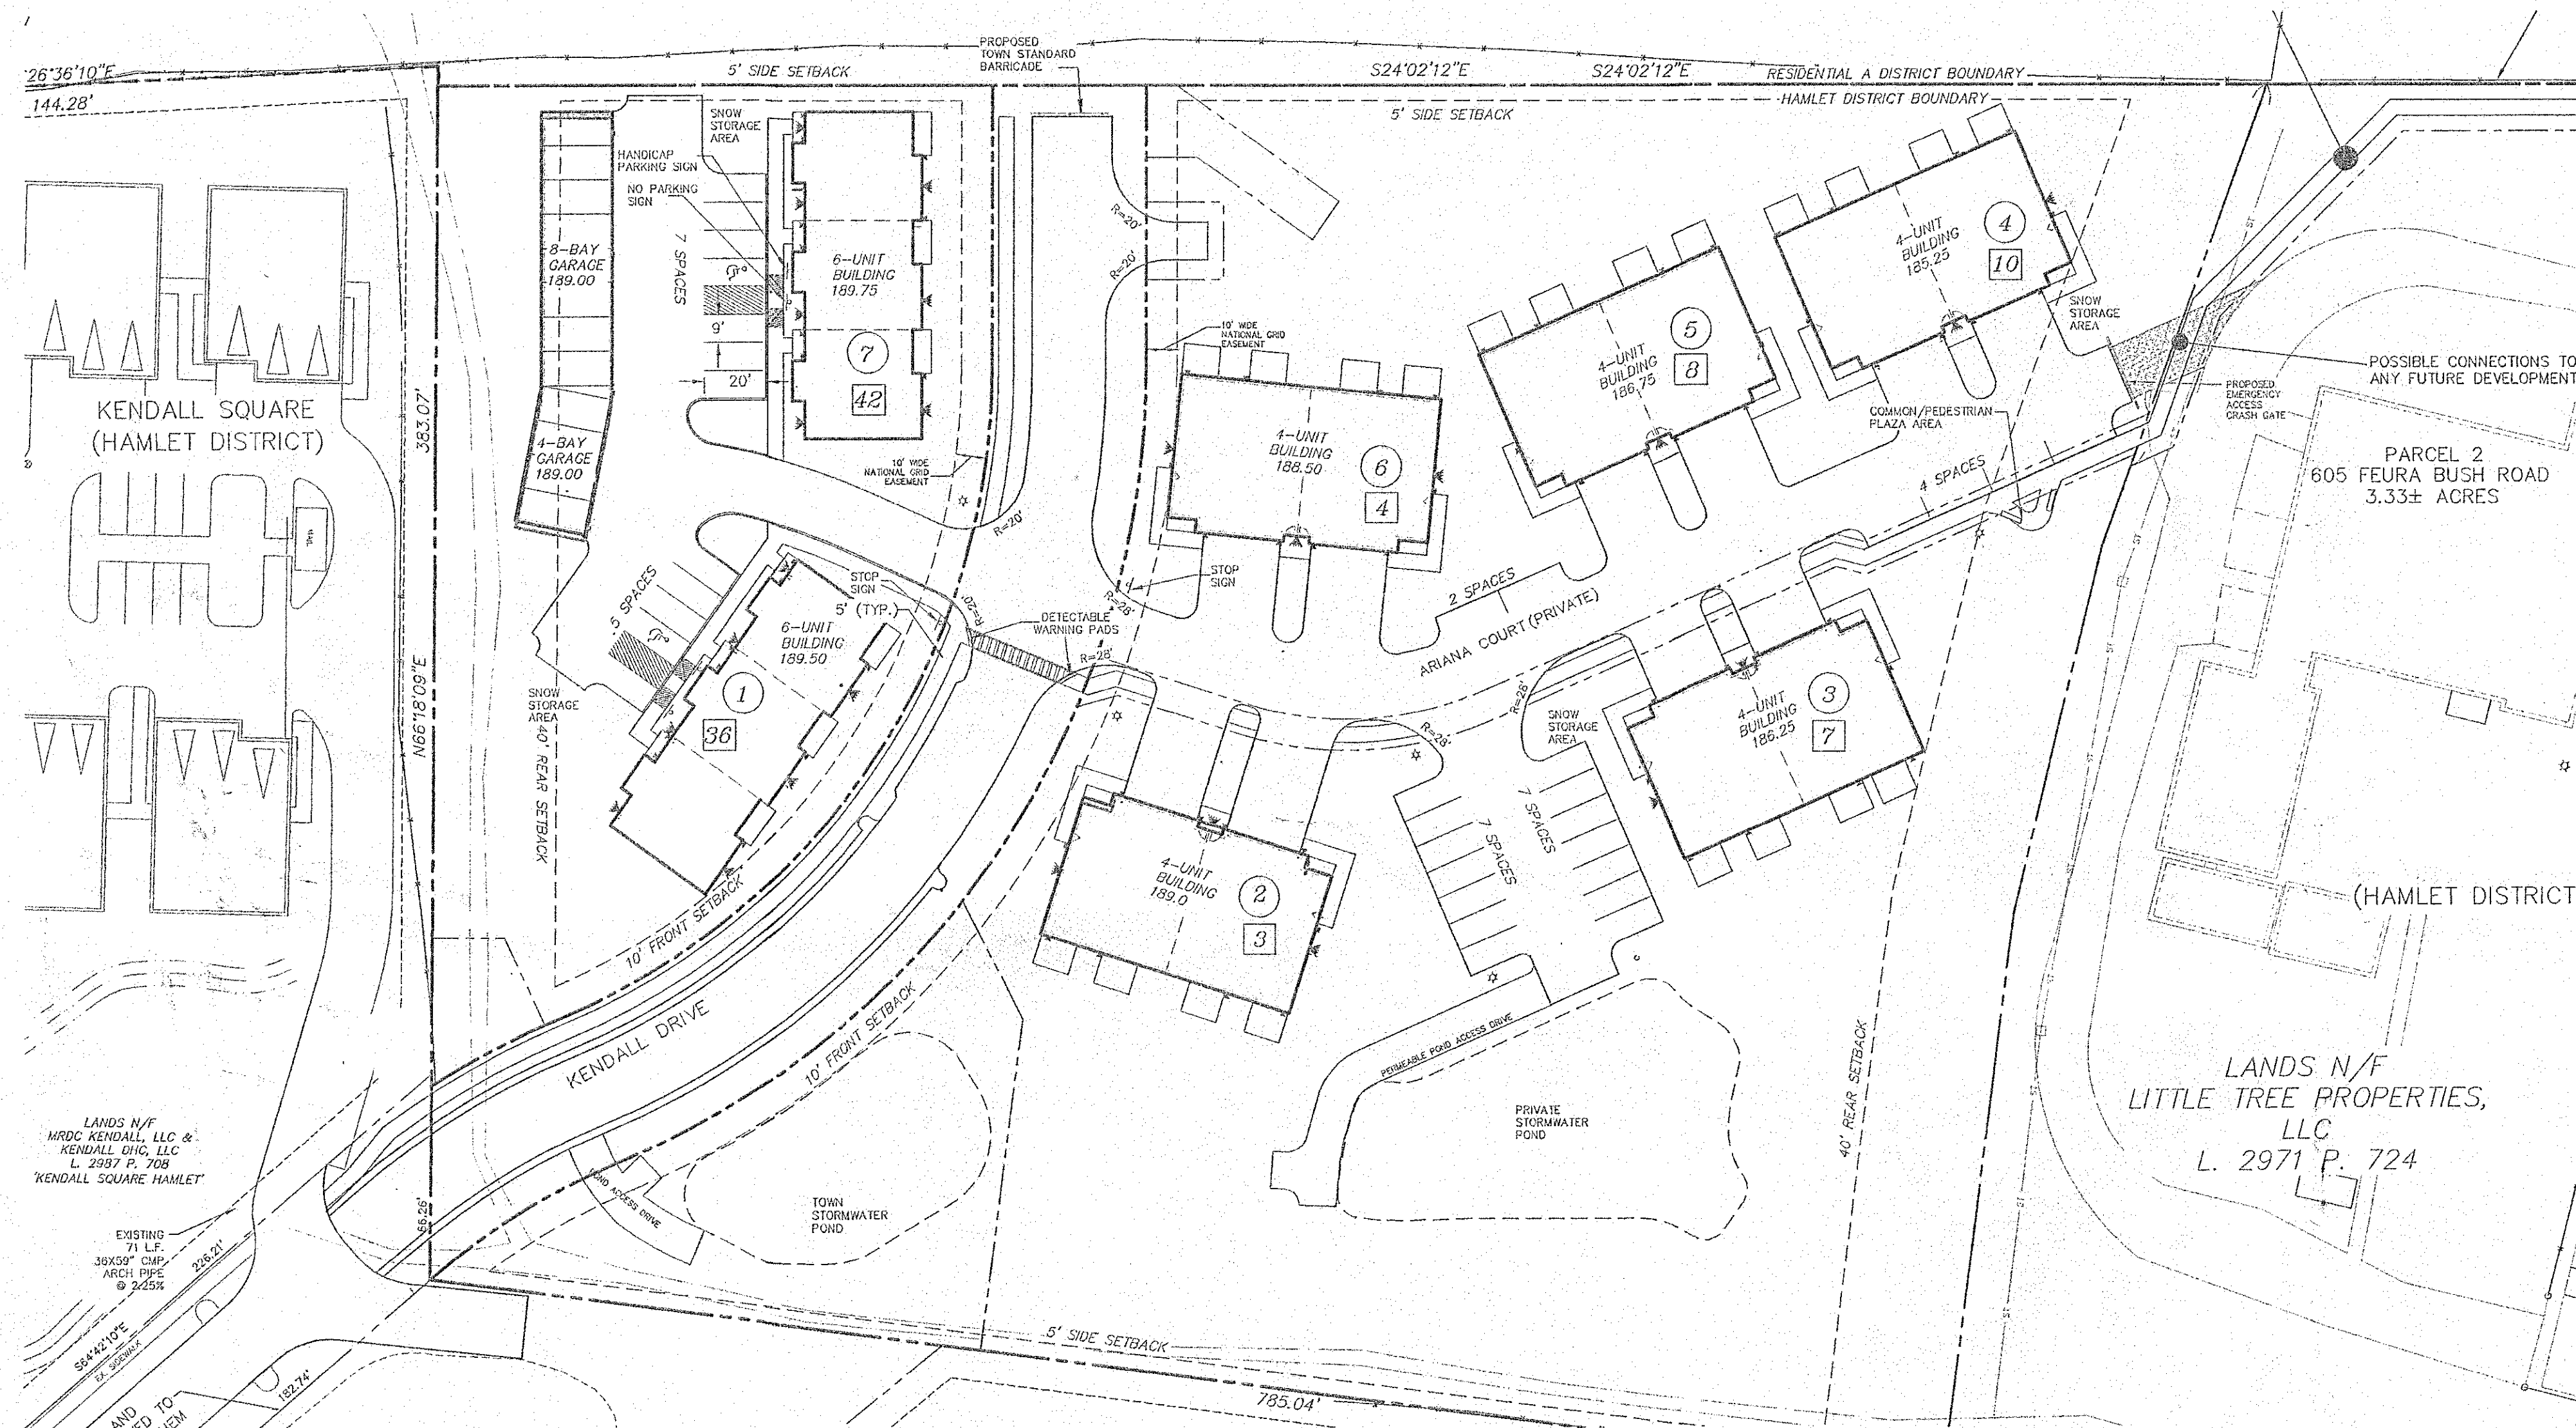

FILE

Albany County Clerk
Document Number 11346824
Rcvd 03/05/2013 12:54:06 PM

Town of Bethlehem Planning Board
By direction of the Chairman
these plans are hereby Approved.
See ~~first~~ sheet for date & signature.
813

SCHEDULE OF DRAWINGS	
SHEET NO.	DRAWING TITLE
	COVER SHEET
1	EXISTING CONDITIONS PLAN
2	SUBDIVISION PLAT
3	SITE PLAN
4	GRADING & UTILITY PLAN
5	PLANTING PLAN
6	LIGHTING PLAN
7	ROAD PROFILES
8	EROSION & SEDIMENT CONTROL PLAN
9	EROSION & SEDIMENT CONTROL DETAILS
10	STORMWATER DETAILS
11	CONSTRUCTION DETAILS
12	"HOTBOX" DETAIL

Cert. 253 CF

Cert. 253 CF

SPA 1988

ALBANY COUNTY DEPARTMENT OF HEALTH
DIVISION OF ENVIRONMENTAL HEALTH SERVICE:

By direction of the Commissioner of Health, these
plans are hereby approved. See last sheet for
date and signature. 4/11

