


SITE DEVELOPMENT PLANS

FOR:


ROBERT H. FINKE & SONS, INC.

LOCATION OF SITE:

1569 U.S. ROUTE 9W
TOWN OF BETHLEHEM
ALBANY COUNTY, NEW YORK
SECTION 133.00, BLOCK 1, LOTS 38 & 39.15

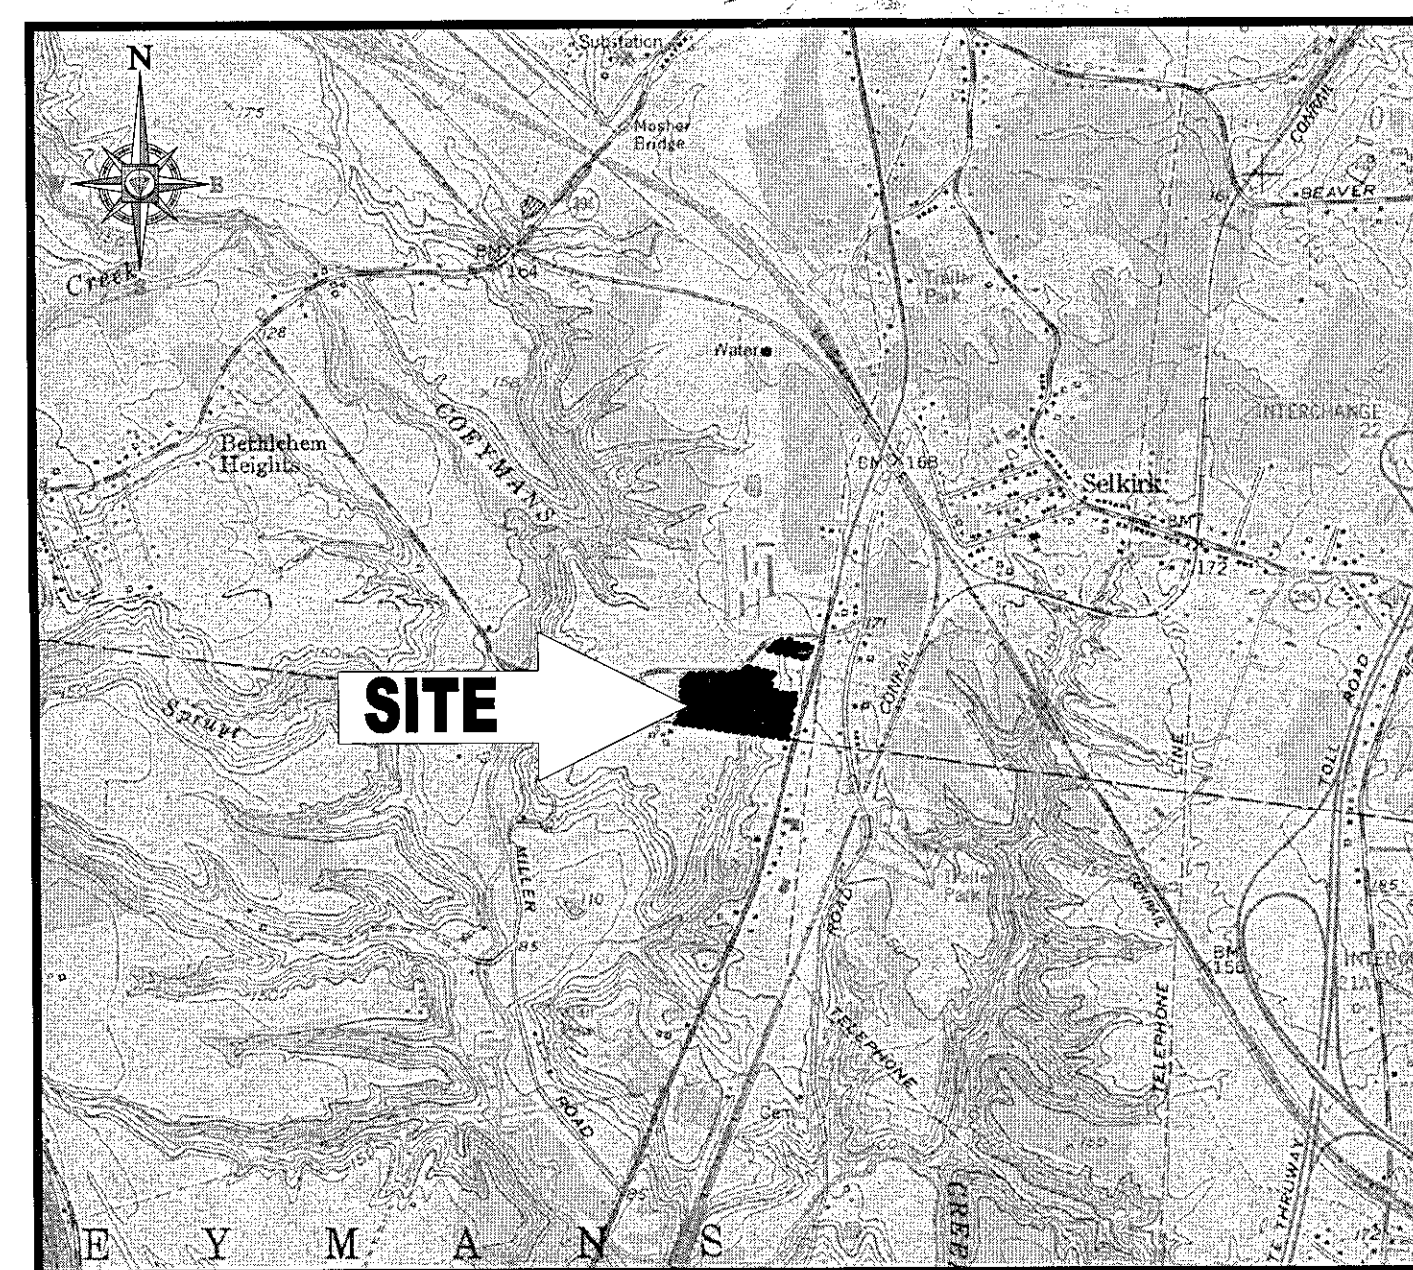

LOCATION MAP
SCALE: N.T.S.
TOWN OF BETHLEHEM

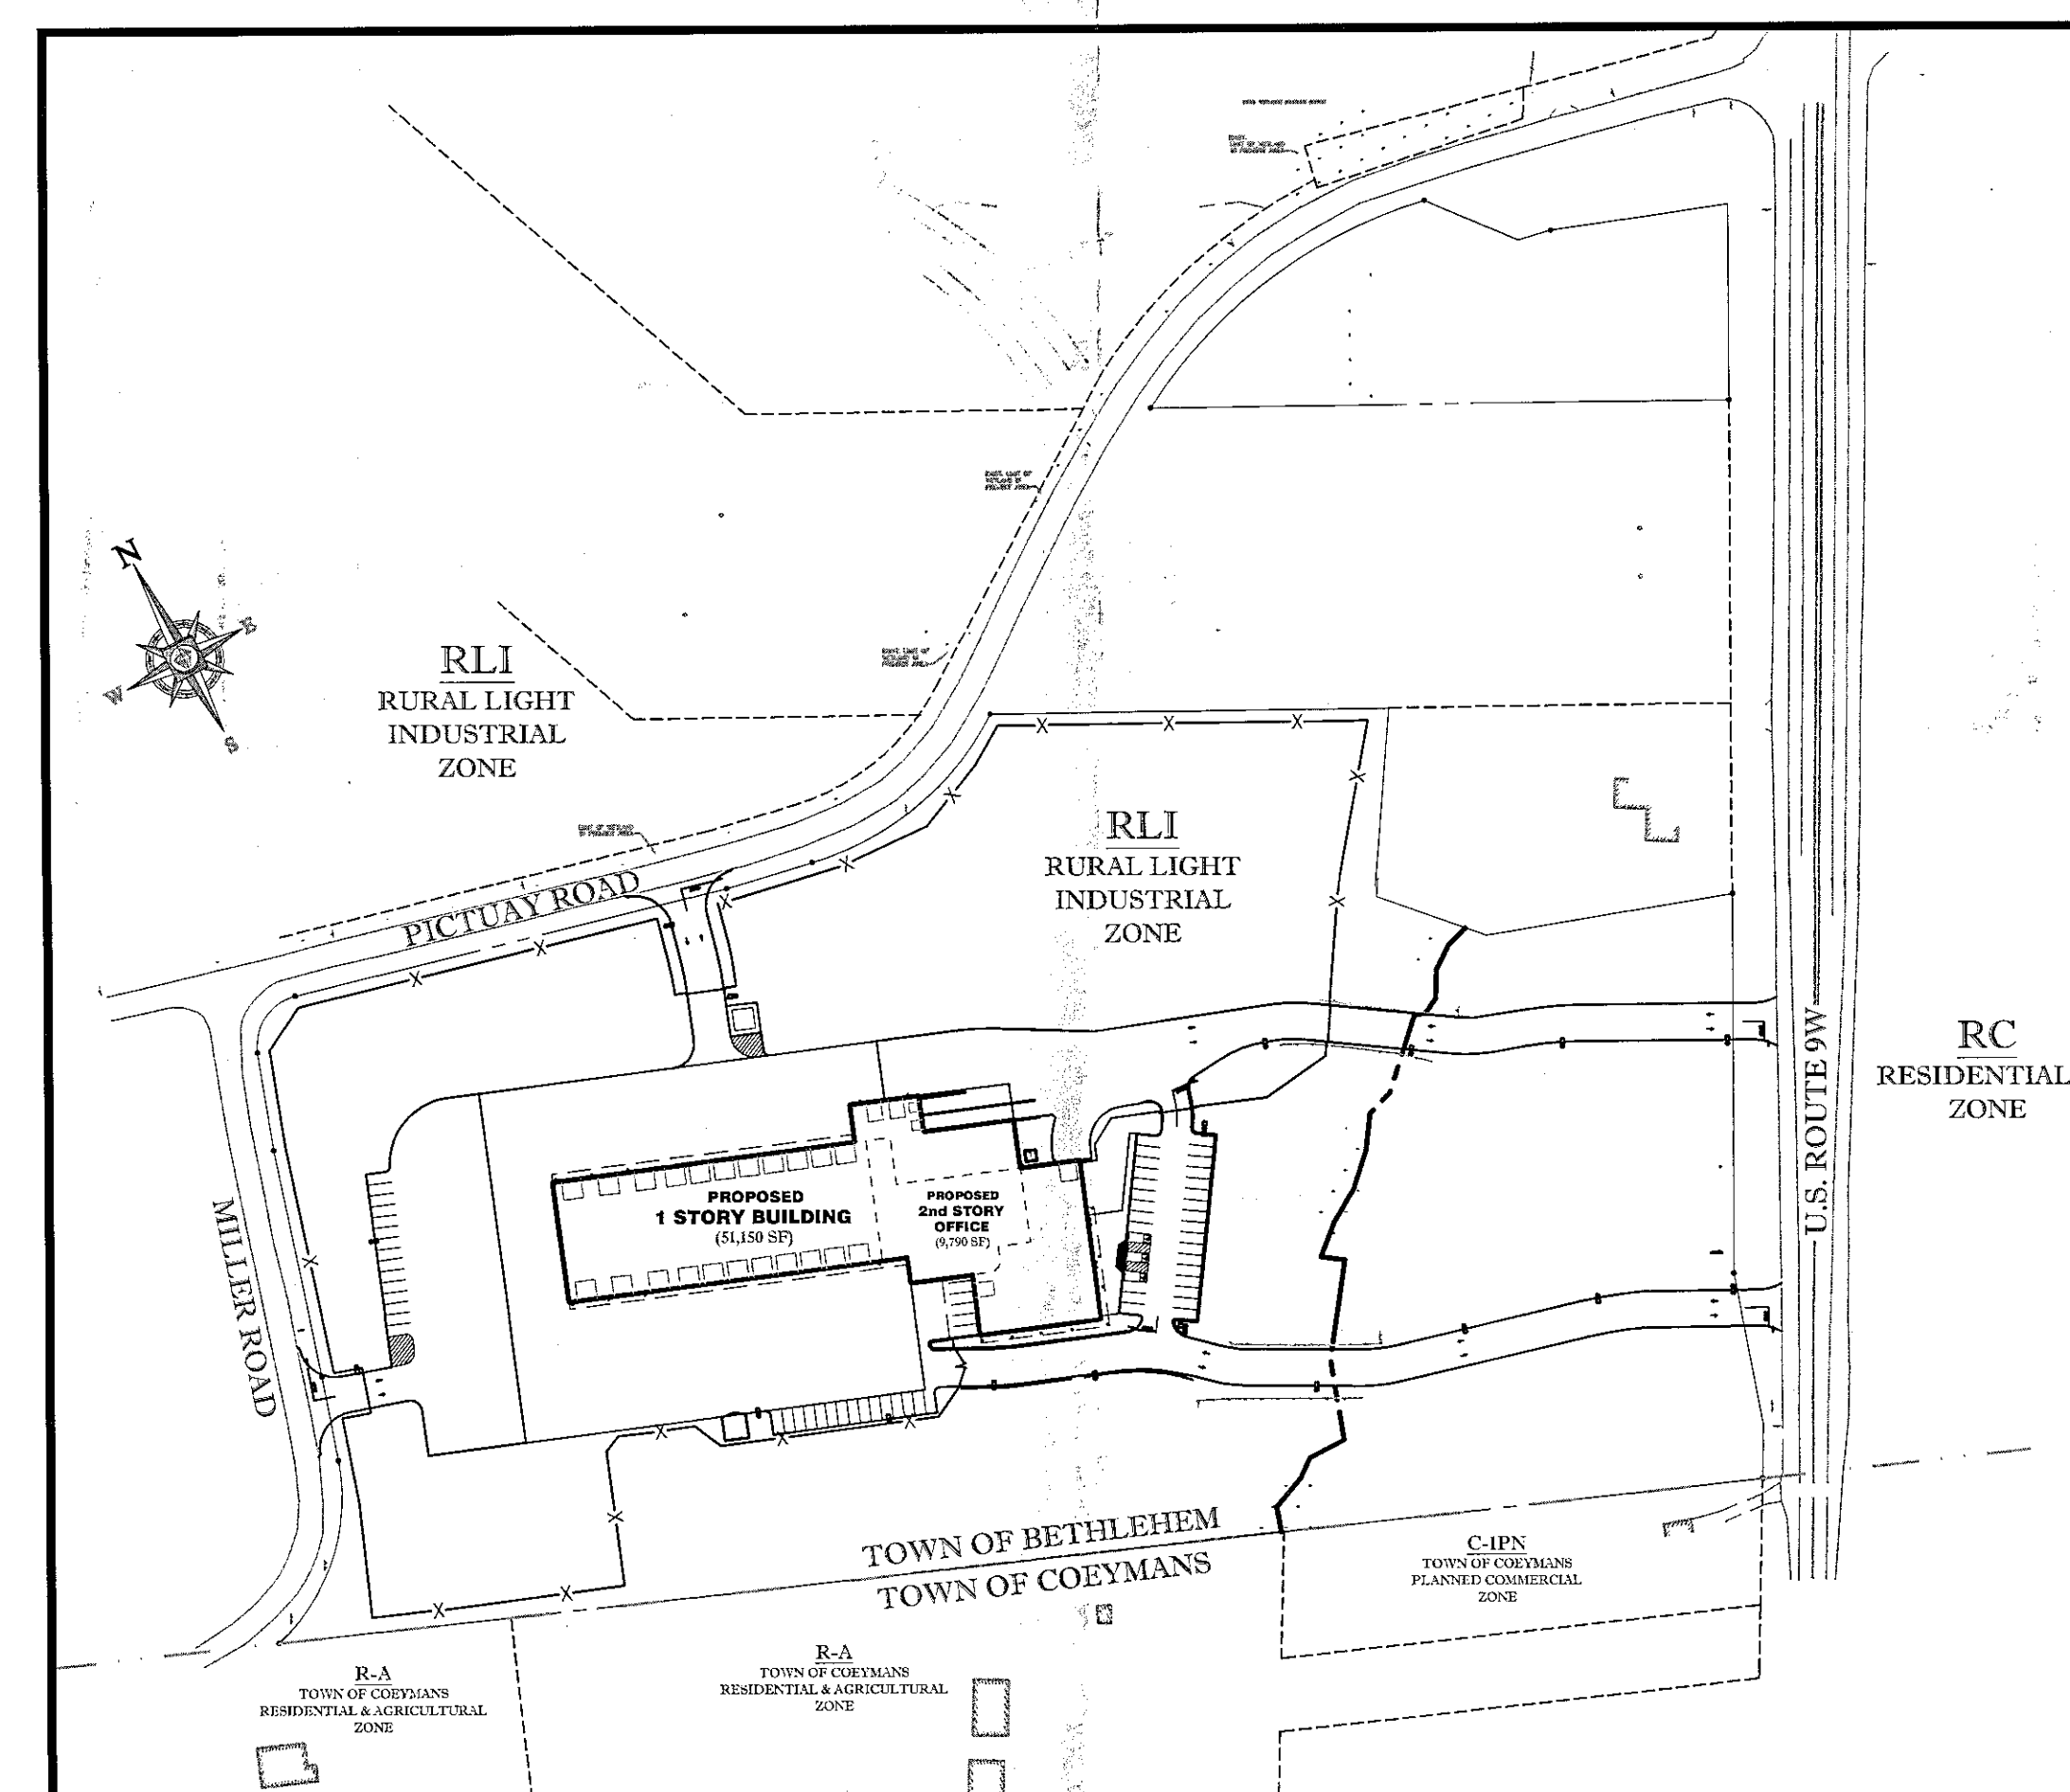


AREA PLAN
SCALE: N.T.S.

PREPARED BY



SHEET TITLE	SHEET NUMBER
COVER SHEET	1 OF 14
GENERAL NOTES SHEET	2 OF 14
DEMOLITION PLAN	3 OF 14
SITE PLAN	4 OF 14
GRADING & DRAINAGE PLAN	5 OF 14
UTILITY PLAN	6 OF 14
SOIL EROSION & SEDIMENT CONTROL PLAN	7 OF 14
SOIL EROSION CONTROL NOTES & DETAILS SHEET	8 OF 14
LANDSCAPE PLAN	9 OF 14
LANDSCAPE NOTES & DETAILS SHEET	10 OF 14
LIGHTING PLAN	11 OF 14
CONSTRUCTION DETAIL SHEET	12 OF 14
CONSTRUCTION DETAIL SHEET	13 OF 14
CONSTRUCTION DETAIL SHEET	14 OF 14
ALTA SURVEY (BY OTHERS)	1 OF 2
ALTA SURVEY (BY OTHERS)	2 OF 2

DRAWING INDEX

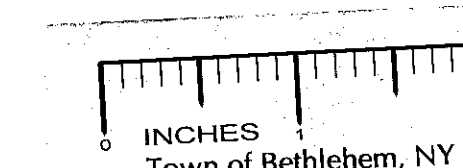


THE EDUCATION LAW OF THE STATE OF NEW YORK PROHIBITS ANY PERSON ALTERING ANYTHING ON THESE DRAWINGS AND/OR THE ACCOMPANYING SPECIFICATIONS, UNLESS IT IS UNDER THE DIRECTION OF A LICENSED PROFESSIONAL ENGINEER, WHERE SUCH ALTERATIONS ARE MADE. THE PROFESSIONAL ENGINEER MUST SIGN, DATE AND DESCRIBE THE FULL EXTENT OF THE ALTERATION ON THE DRAWINGS AND/OR IN THE SPECIFICATIONS (NYS EDUCATION LAW SECTION 2205-3)


RECEIVED
Town of Bethlehem Planning Board
By direction of the Chairman
these plans are hereby Approved. Town of Bethlehem
See for date and signature. Planning Board
Sheet 14

PLANNING BOARD
TOWN OF BETHLEHEM
ALBANY COUNTY, NEW YORK
This Site Plan Approved.
James Finke
Title Chairman
Date February 4, 2013
SPK 189

TOWN OF BETHLEHEM APPROVAL AREA

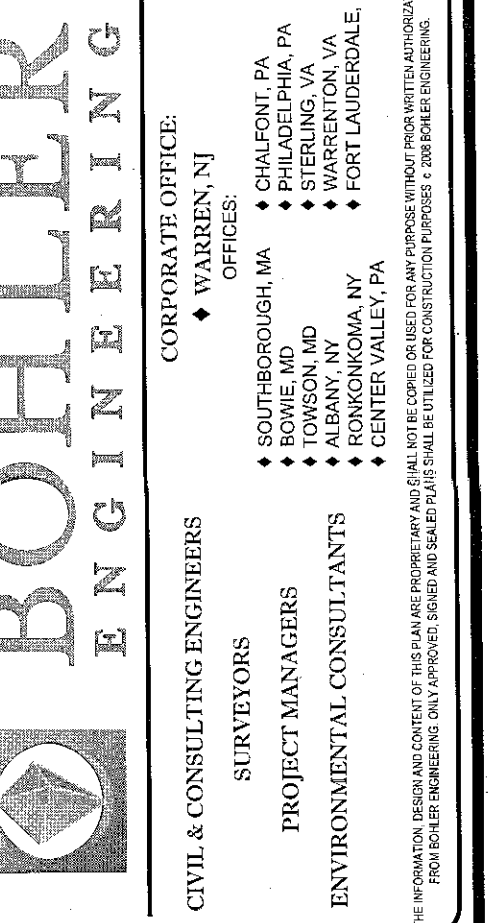

REV	DATE	COMMENT	BY
1	9/18/12	PER TOWN COMMENTS	SH
2	1/3/13	PER TOWN COMMENTS	SH
3	1/17/13	PER TOWN COMMENTS	SH
4	1/22/13	ADDED NYSDOT PAVEMENT DETAIL	SH
5			
6			
7			
8			
9			
10			
11			
12			
13			
14			
15			
16			
17			
18			
19			
20			
21			
22			
23			
24			
25			
26			
27			
28			

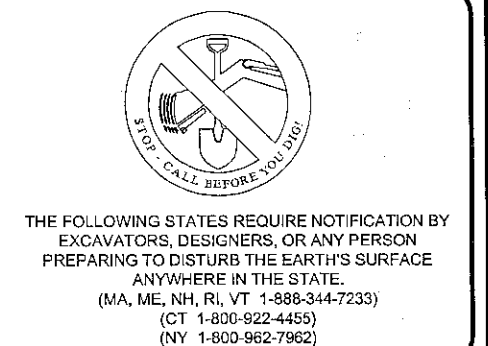

PERMIT SET
PROJECT No.: B120132
DRAWN BY: SH
CHECKED BY: RO
DATE: 8/28/2012
SCALE: AS NOTED
CAD L.D.: B120132SS4

SITE PLAN DOCUMENTS
FOR
ROBERT H. FINKE & SONS, INC.
LOCATION OF SITE
1569 U.S. ROUTE 9W
SELKIRK, NY 12158
TOWN OF BETHLEHEM
ALBANY COUNTY, NEW YORK

BOHLER ENGINEERING
5 COMPUTER DRIVE WEST SUITE 203
ALBANY NY, 12205
Phone: (518) 438-6900
Fax: (518) 438-0900
www.BohlerEngineering.com

W.D. GOEBEL
PROFESSIONAL ENGINEER
NEW YORK LICENSE No. 071254-1
OHIO LICENSE No. E-68329

COVER SHEET
SHEET TITLE:
SHEET NUMBER:
C-1
REV 4