




PLANT MATERIAL SCHEDULE					
SYM	BOTANICAL NAME	COMMON NAME	SIZE	AMT	COMMENTS
SHRUBS					
AC	AMELANCHIER CANADENSIS	SHADBLOW SERVICEBERRY	4'-5' HT.	7	B & B
CA	CORNUS ALBA STOLONIFERA	RED OSIER DOGWOOD	3 GAL.	10	C.G.
HV	HAMAMELIS VIRGINIANA	COMMON WITCH-HAZEL	3'-4' HT.	8	B & B
IC	ILEX GLABRA 'COMPACTA'	COMPACT INKBERY	24"-30" HT.	28	C.G.
JO	JUNIPERUS CHINENSIS 'SEA GREEN'	SEA GREEN JUNIPER	18" HT.	26	C.G.
RH	RHODODENDRON 'P.J.M.'	P.J.M. RHODODENDRON	2 1/2' HT.	24	B & B
TM	TAXUS X MEDIA 'HICKSI'	HICKS UPRIGHT YEW	30" HT.	4	C.G.
IE	THUJA OCCIDENTALIS 'EMERALD GREEN'	EMERALD ARBORVITAE	5'-6' HT.	5	B & B
VL	VIBURNUM LENTAGO	HANNYBERRY VIBURNUM	4'-5' HT.	3	B & B
TREES					
ARC	ACER RUBRUM 'COLUMNARE'	COLUMNARE RED MAPLE	2"-2 1/2" CAL.	6	B & B
CD	CERCIS CANADENSIS	EASTERN REDBUD	1 3/4"-2 1/2" CAL.	9	TREEFORM-B & B
FG	FAGUS GRANDIFOLIA	AMERICAN BEECH	2-2 1/2" CAL.	1	B & B
JS	JUNIPERUS SCULPTURUM	SKYROCKET JUNIPER	5'-6" HT.	22	B & B
TS	TSUGA CANADENSIS	CANADIAN HEMLOCK	5'-6" HT.	17	B & B
TS1	TSUGA CANADENSIS	CANADIAN HEMLOCK	7'-8" HT.	3	B & B
PERENNIALS					
HE	HEMEROCALLIS 'HYPERION'	DAY LILIES		20	
GRASSES					
PH	PENNISETUM ALOPECUROIDES 'HAMEL'	DWARF FOUNTAIN GRASS	#3 POT	12	

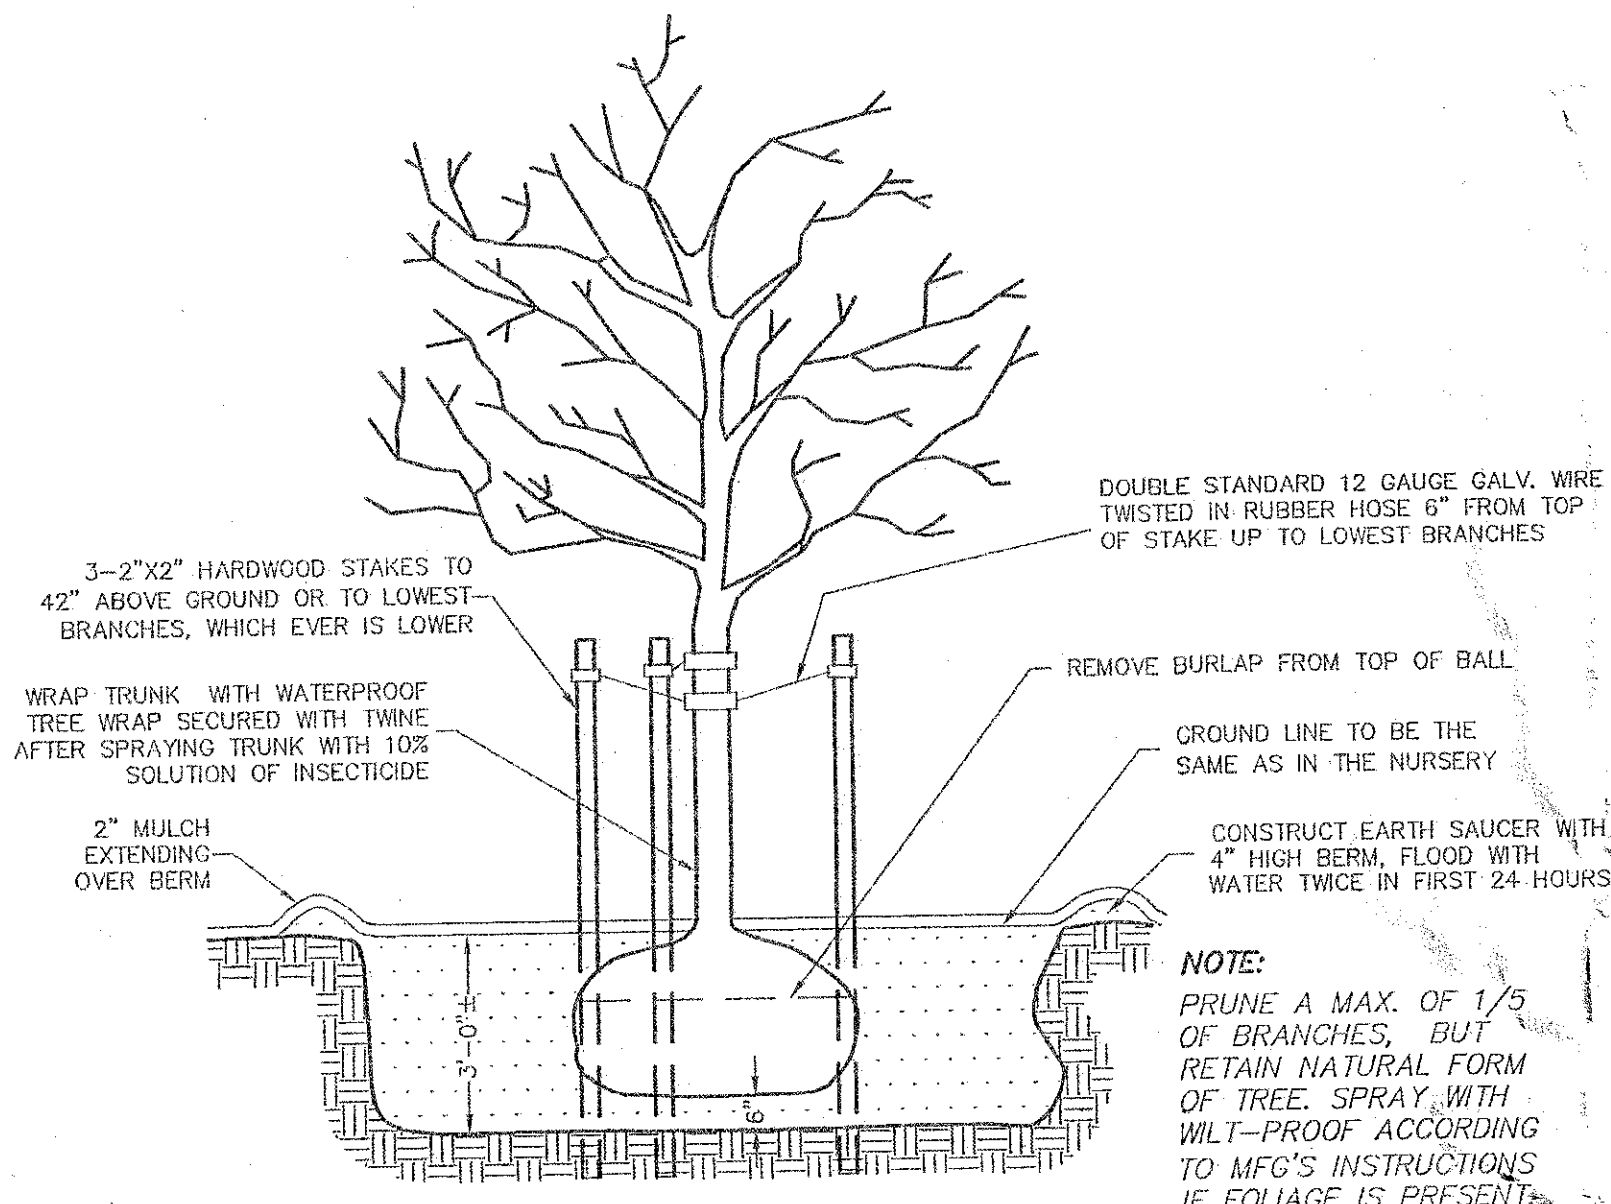

NEW TREE PLANTING DETAIL
NOT TO SCALE

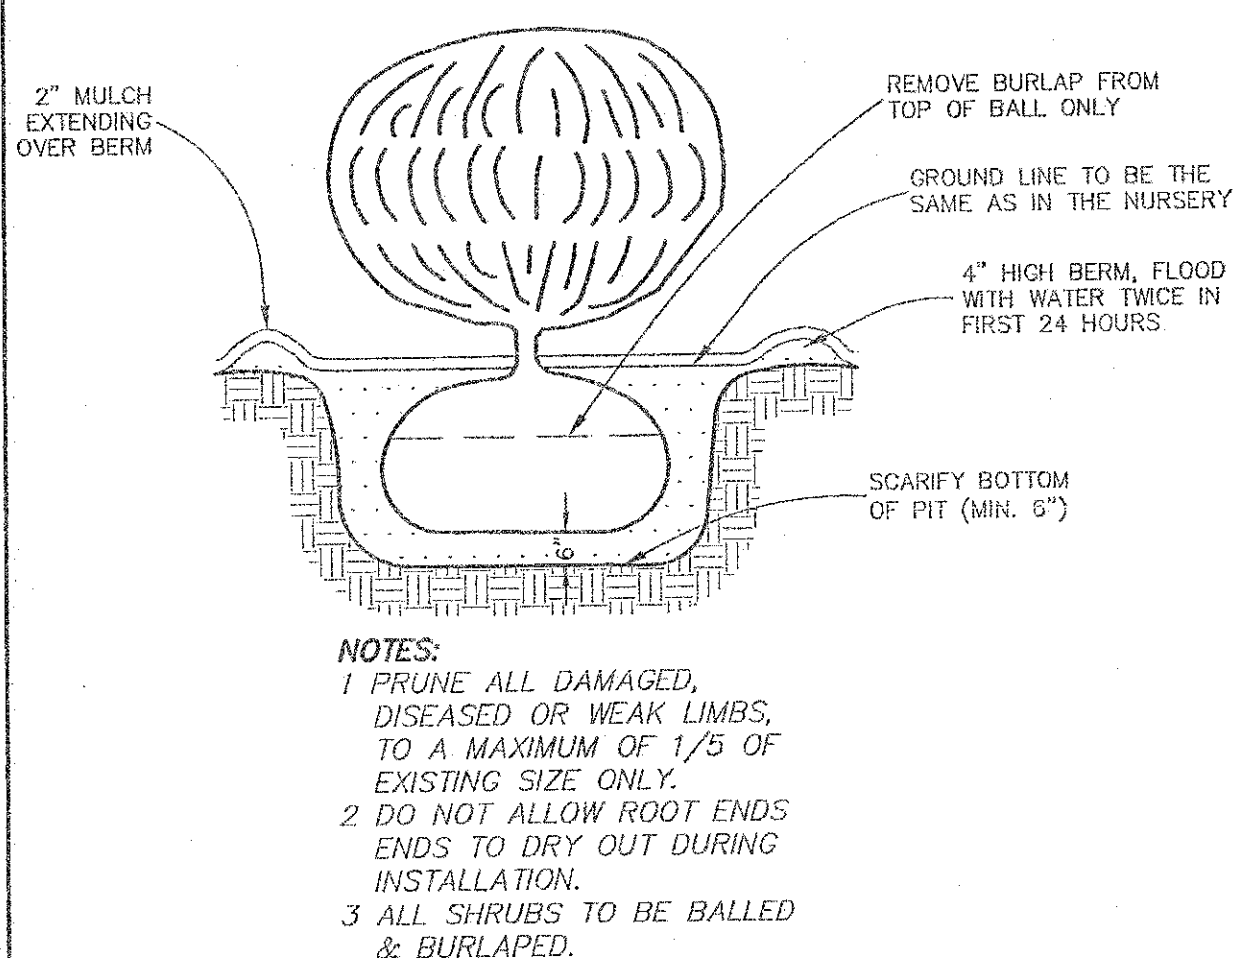

SHRUB PLANTING DETAIL
NOT TO SCALE

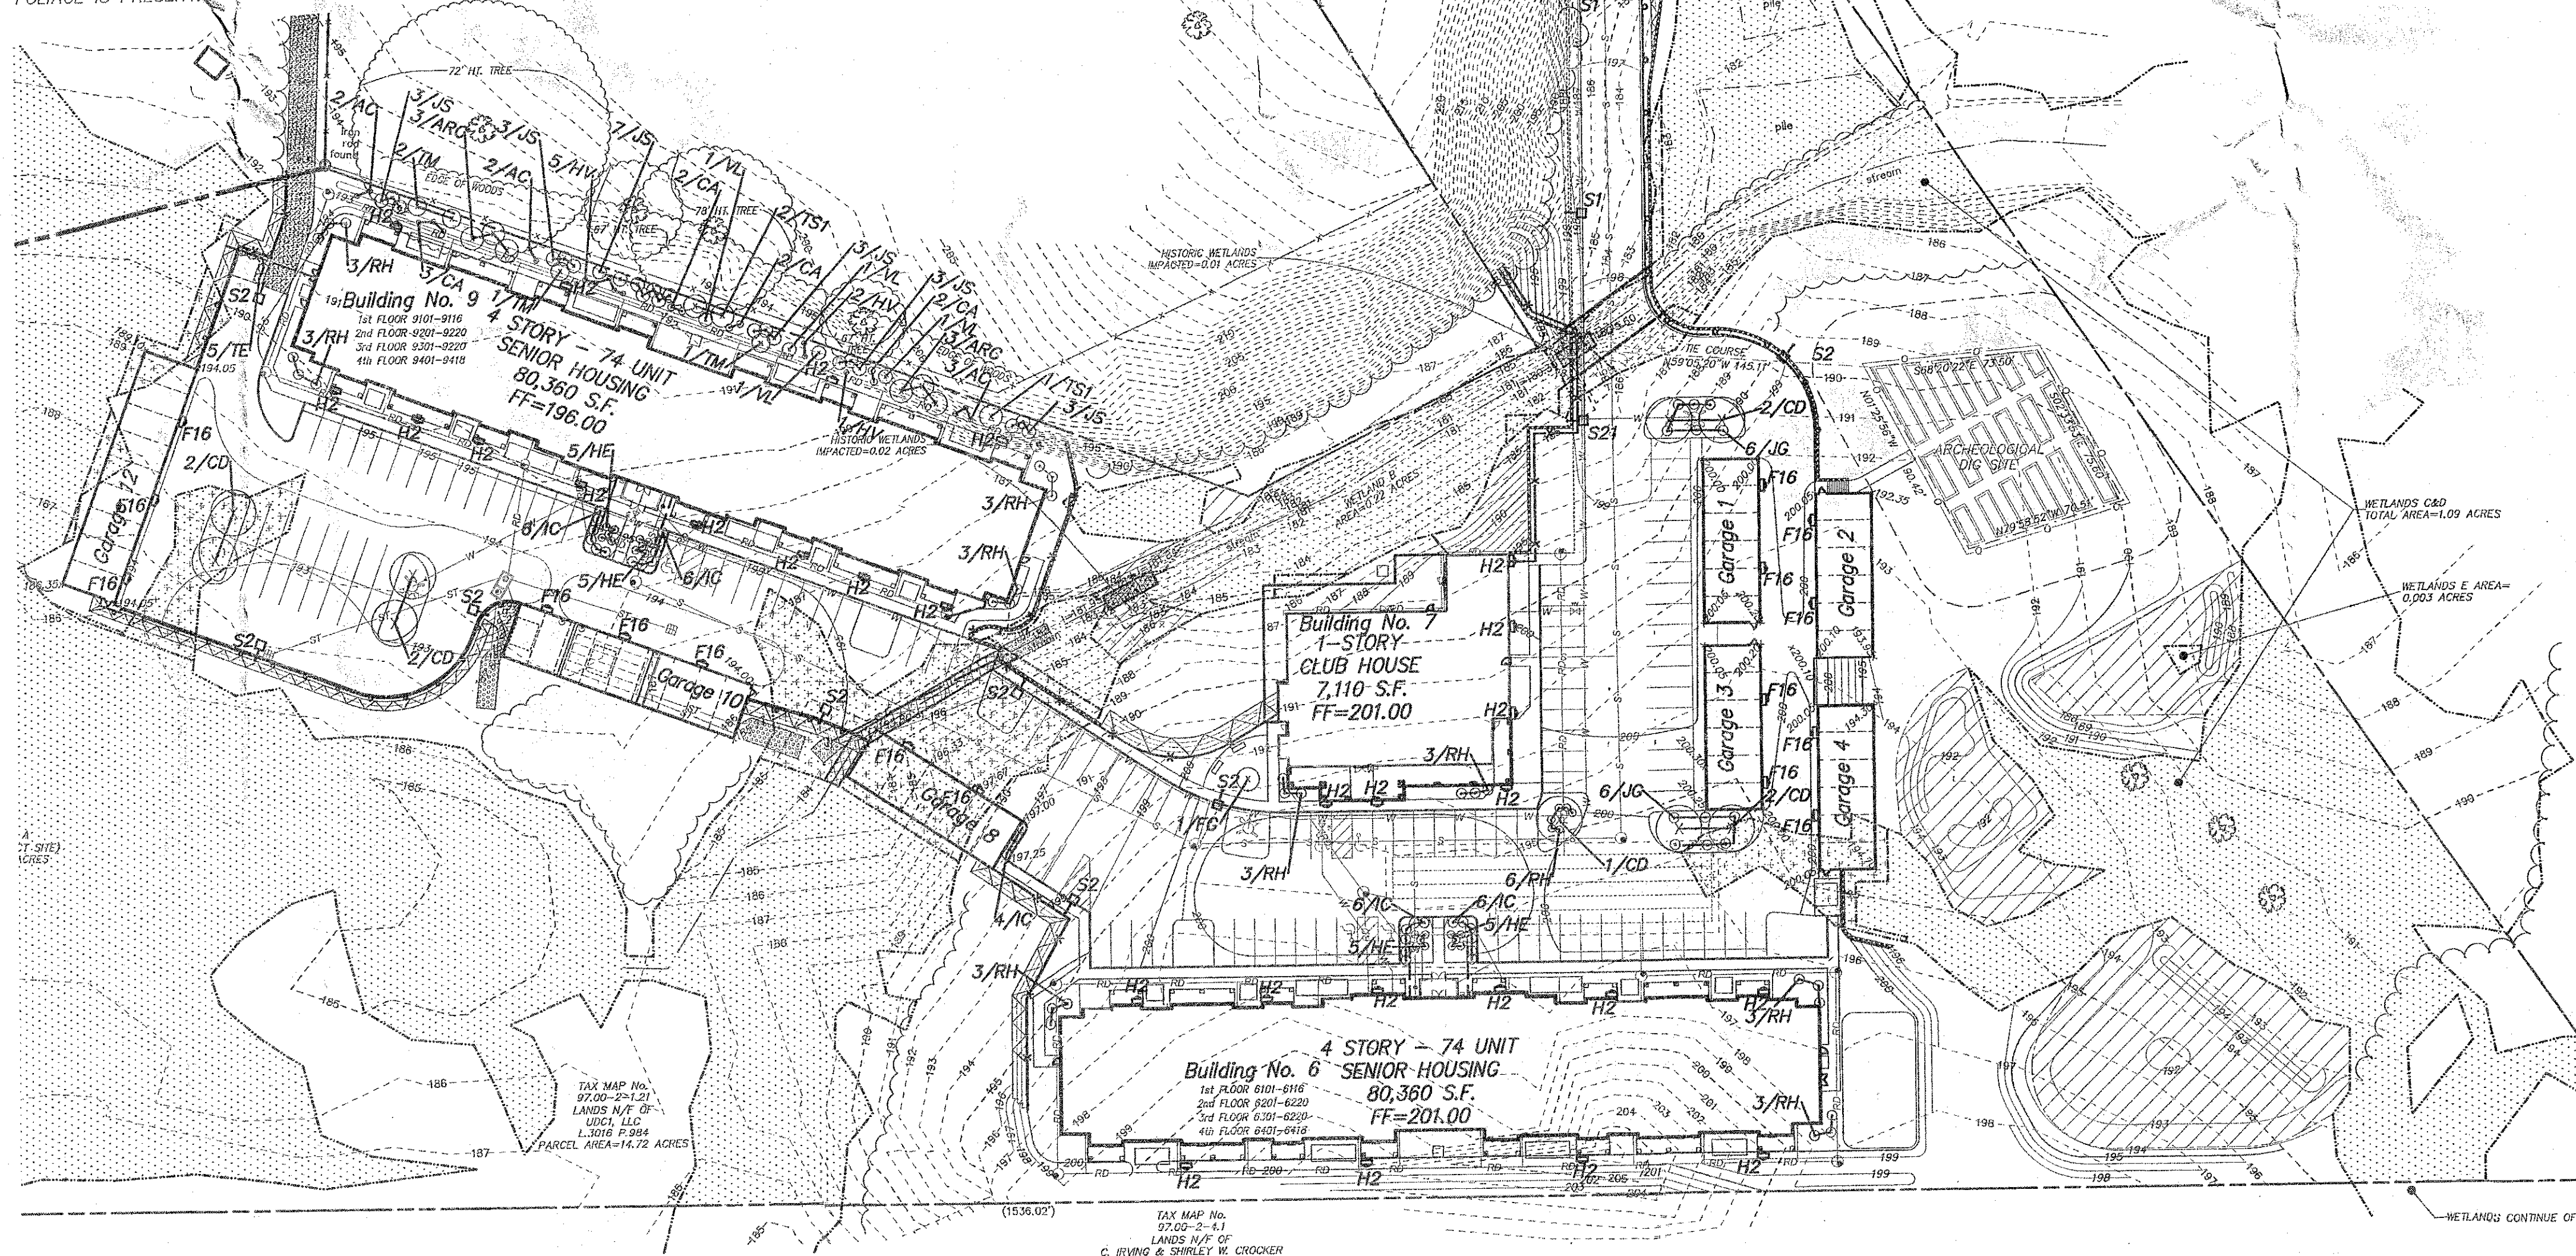

OVERALL LIGHTING AND LANDSCAPE PLAN
SCALE: 1"=50'

RELEASED FOR CONSTRUCTION

HERSHBERG & HERSHBERG
Consulting Engineers and Land Surveyors
18 Locust Street
Albany, New York 12203

ALTERATION OF THIS DOCUMENT EXCEPT BY A LICENSED PROFESSIONAL ENGINEER OR LAND SURVEYOR, IS ILLEGAL.

STATE OF NEW YORK
JAMES R. HERSHBERG
044226
PROFESSIONAL ENGINEER & LAND SURVEYOR

REVISIONS	DATE	REMARKS
1	1/9/14	REVISIONS AS PER 1/2/14 REVIEW LETTER
2	1/21/14	LIGHT PALE REVISIONS
3	2/18/14	FILE ACCESS AND CEMETERY SCREENING REV.
4	2/19/14	REV AS PER REVIEW LETTER DATED 2/7/14
5	3/20/14	2/19/14 & 2/19/14
6	5/5/14	SUBMISSION FOR STAMPING

PROPOSED LANDSCAPE AND LIGHTING PLAN
GLENMONT ABBEY VILLAGE
(FKA-GLENMONT VILLAGE SENIOR HOUSING)
GLENMONT ROAD
TOWN OF BETHLEHEM, NEW YORK

OWNER: VAN WIES VILLAGE, LLC
United Development Corp
300 Jordan Road
Troy, New York 12180

APPLICANT: VAN WIES VILLAGE, LLC
United Development Corp
300 Jordan Road
Troy, New York 12180

TOWN OF BETHLEHEM PLANNING BOARD APPROVAL

PLANNING BOARD
TOWN OF BETHLEHEM
ALBANY COUNTY, NEW YORK
By direction of the Chairman.
These drawings are hereby approved.
See sheet(s) 1-2
for date and signature.

INCHES
Town of Bethlehem, NY

FILE: 120266
SCALE: 1"=50'
DATE: 12/12/13
CHK: JGH
BY: AS
20266-Construction/SLDING

C-3