


AFRIM'S SPORTS DOME AT BETHLEHEM SOCCER CLUB

NO. 450 WEMPLE ROAD

TOWN OF BETHLEHEM * COUNTY OF ALBANY * STATE OF NEW YORK

SITE PLANS

AUGUST 2014

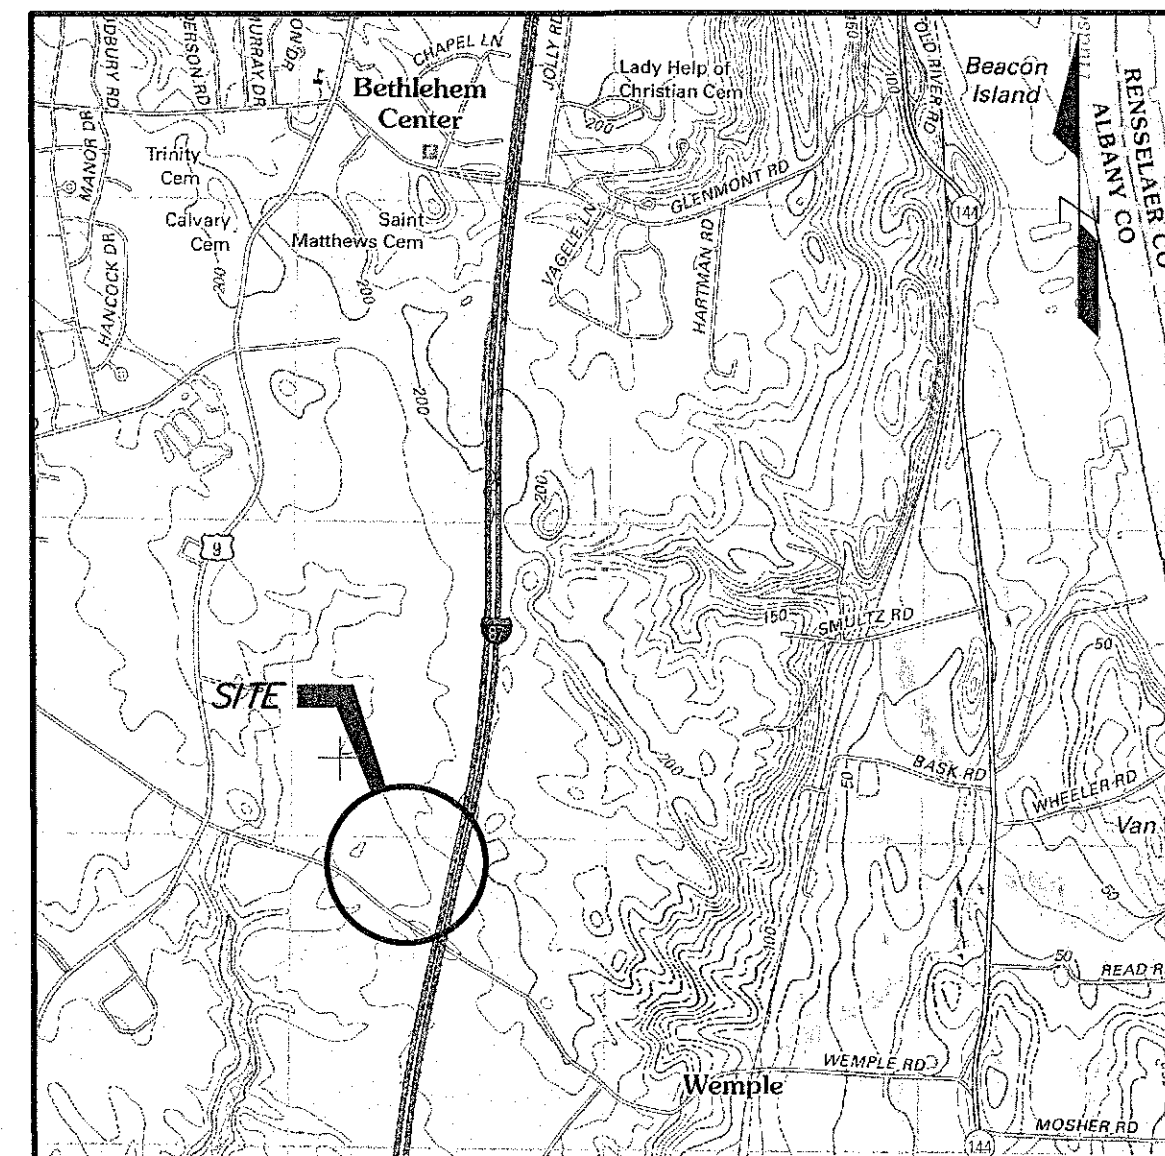

SITE LOCATION MAP
1" = 2000'



PROJECT MAP
1" = 200'

Sheet List Table		
Page	Sheet	Title
1	C-000	COVER
2	C-010	GENERAL NOTES
3	V-101	EXISTING CONDITIONS
4	C-090	DEMOLITION PLAN
5	C-101	SITE PLAN
6	C-111	UTILITY PLAN
7	C-121	GRADING AND EROSION CONTROL PLAN
8	C-151	LANDSCAPING PLAN
9	C-191	LIGHTING PLAN
10	C-501	DETAILS (1)
11	C-502	DETAILS (2)
12	C-503	DETAILS (3)
13	C-504	DETAILS (4)

APPLICANT/DEVELOPER:

**AFRIM'S
SPORTS**

AFRIM SPORTS, INC.
636 ALBANY SHAKER ROAD
COLONIE, NY 12110
CONTACT: AFRIM NEZAJ
PHONE: (518)438-3131
EMAIL: ANEZAJ1@GMAIL.COM

PROPERTY OWNER:



BETHLEHEM SOCCER CLUB
P.O. BOX 305
DELMAR, NY 12054
CONTACT: JEREMY MARTELLE
EMAIL: PRESIDENT@BSCNY.ORG

FILE

ALBANY COUNTY DEPT. OF HEALTH
DATE AUG 25 2014

These plans for Sewage Disposal
and Water System Improvements.
Examined and Approved

[Signature]
DIRECTOR, DIVISION OF ENVIRONMENTAL
HEALTH SERVICES

PLANNING BOARD
TOWN OF BETHLEHEM
ALBANY COUNTY, NEW YORK
By direction of the Chairman,
These drawings are hereby approved.
See sheet(s) C-101
for date and signature.

INCHES
Town of Bethlehem, NY

TOWN OF BETHLEHEM

ALBANY COUNTY DEPARTMENT OF HEALTH

Rev no	Date	Description	By
E	08-18-14	ISSUED FOR CONSTRUCTION	AJV
D	04-18-14	RESPONSE TO COMMENTS	AJV
C	03-11-14	RESPONSE TO COMMENTS-FINAL APPROVAL	AJV
B	01-10-14	ISSUE FOR DOH APPROVAL	AJV
A	01-07-14	ISSUED FOR SITE PLAN REVIEW	AJV

L.S. L. SIPPERLY & ASSOCIATES
ENGINEERS • SURVEYORS • LAND PLANNERS
696 TROY-SCHENECTADY ROAD, LATHAM, N.Y. 12110
PHONE: (518) 782-1800 FAX: (518) 782-1252



DESIGNED BY: AV
DRAWN BY: AV
CHECKED BY: TM
APPROVED BY: LS
SCALE: AS NOTED
DATE: 01-10-2014

**AFRIM'S SPORTS DOME
AT BETHLEHEM SOCCER CLUB
COVER**
450 WEMPLE ROAD
ALBANY COUNTY
TOWN OF BETHLEHEM
STATE OF NEW YORK

1 OF 13
C-000
REV. NO. E DWG. NO. E-14004

SUP 23/SPA 208 05/06/2014