

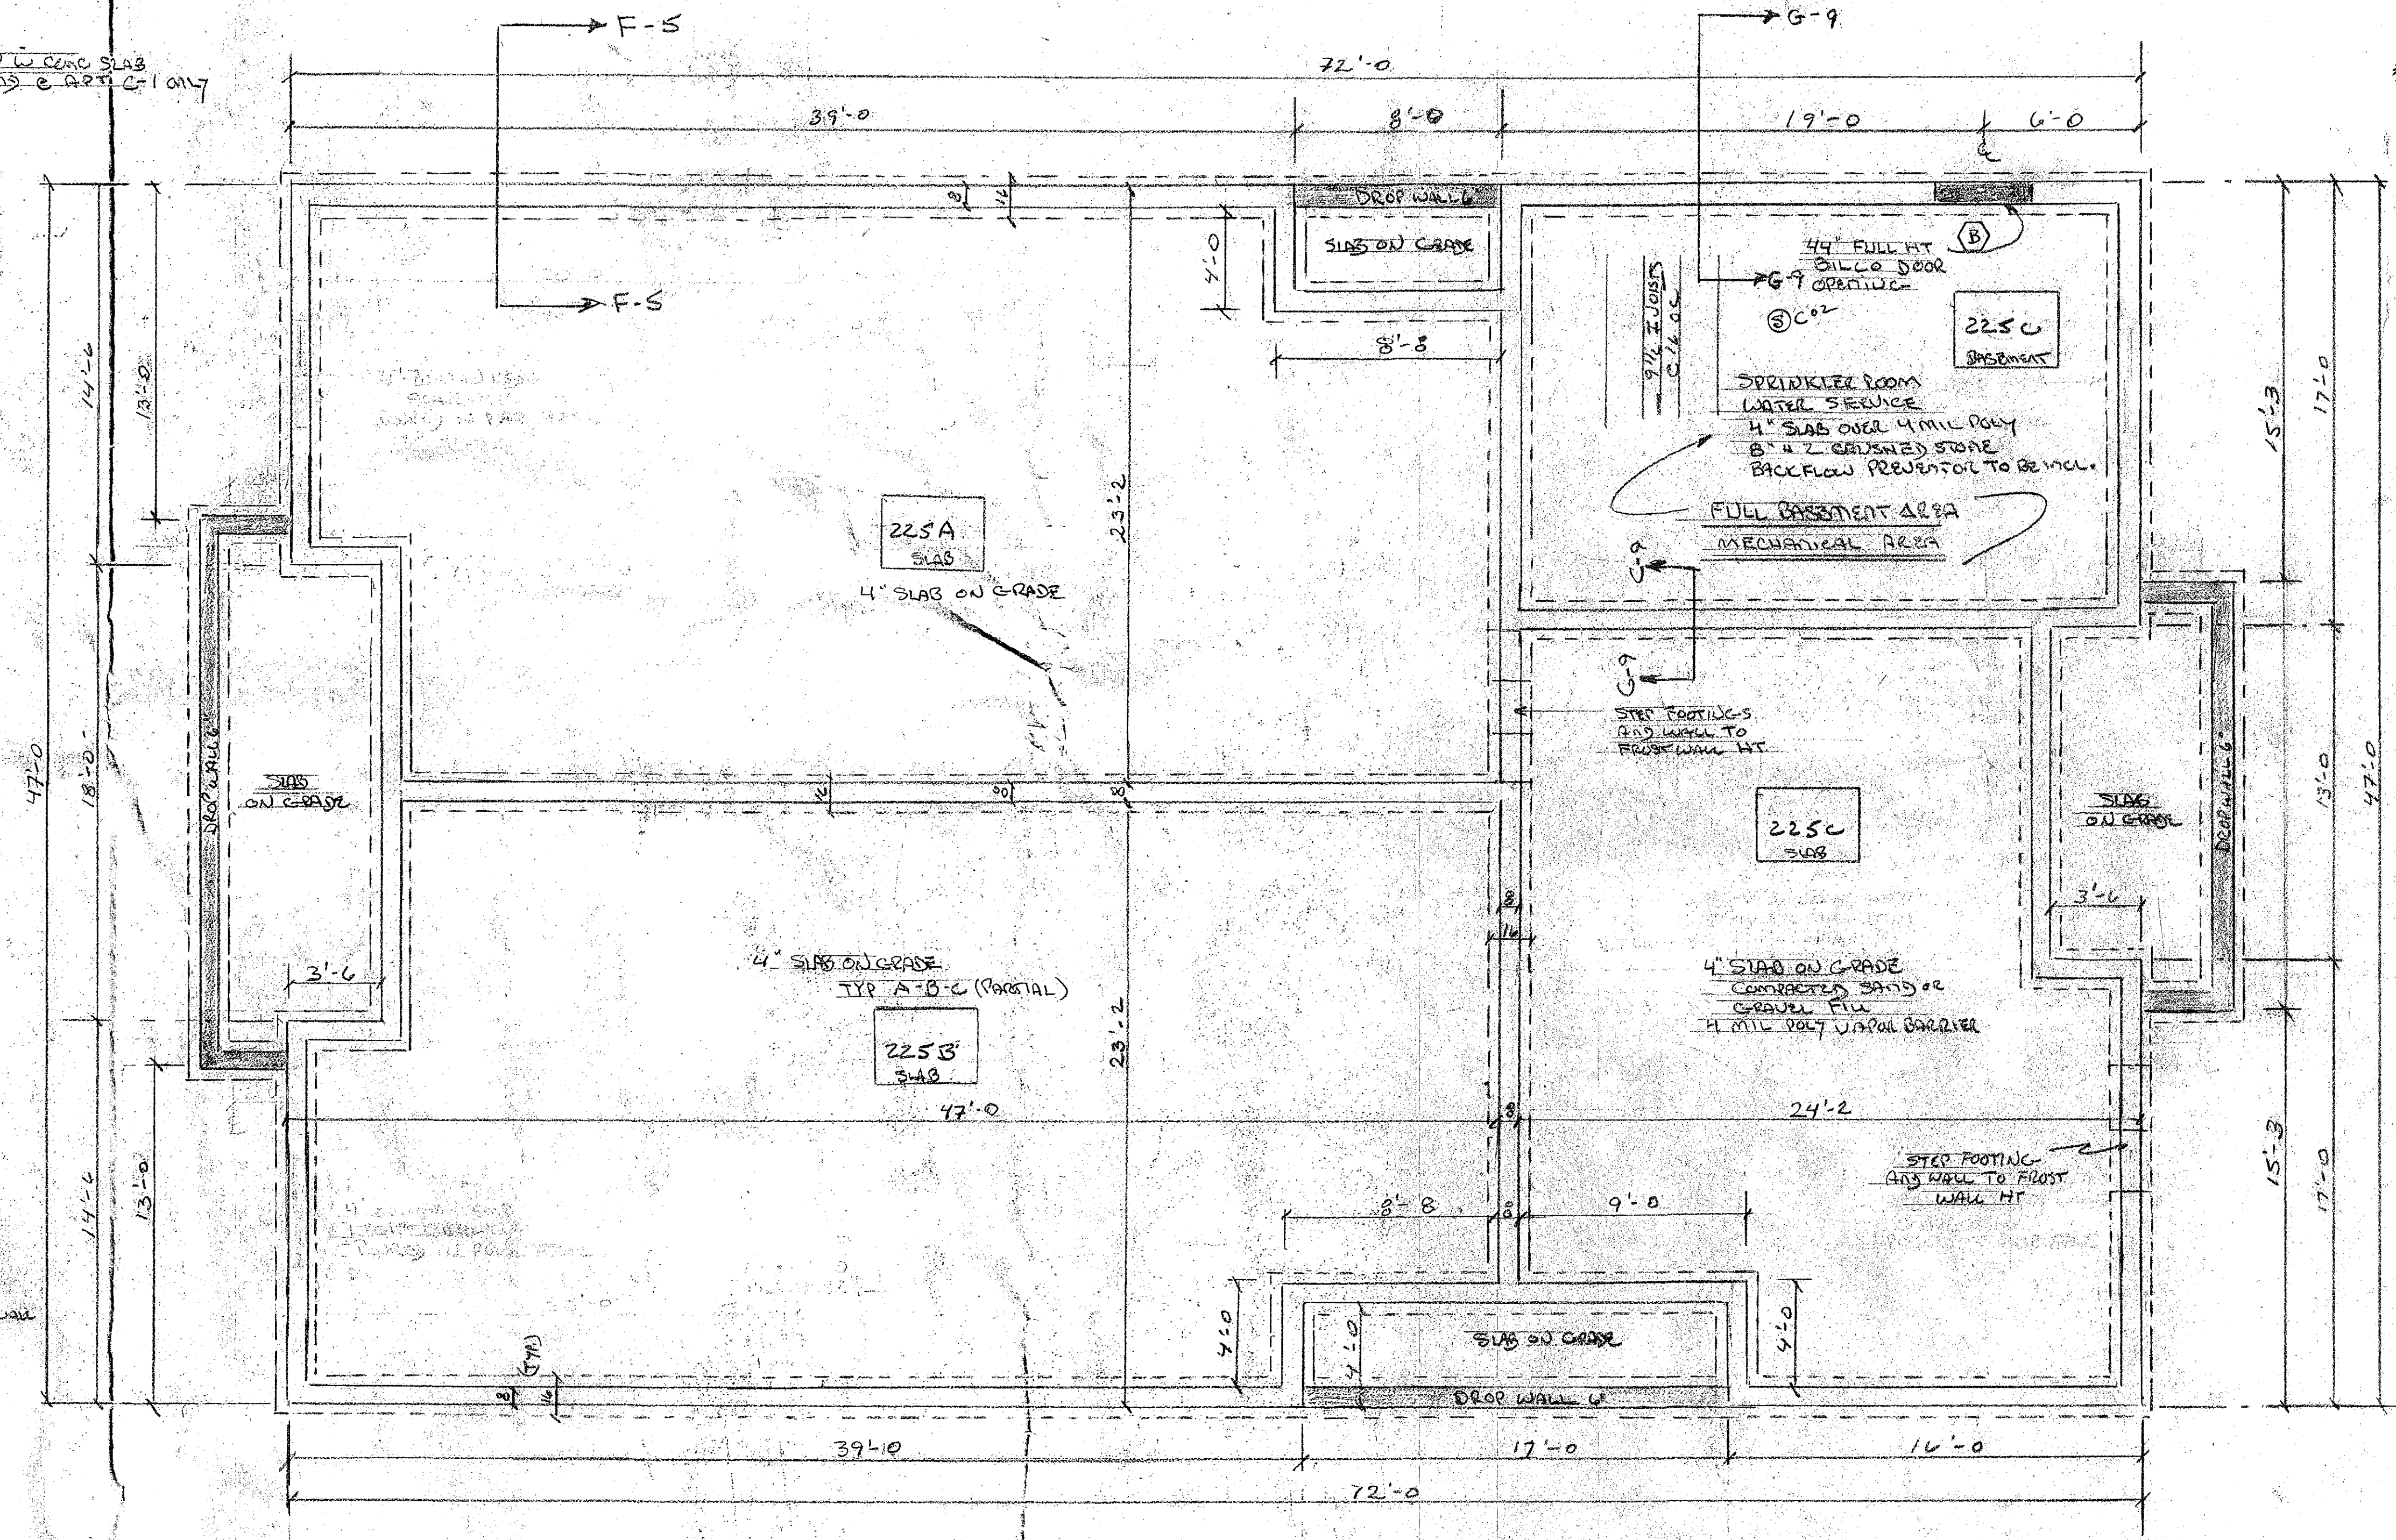
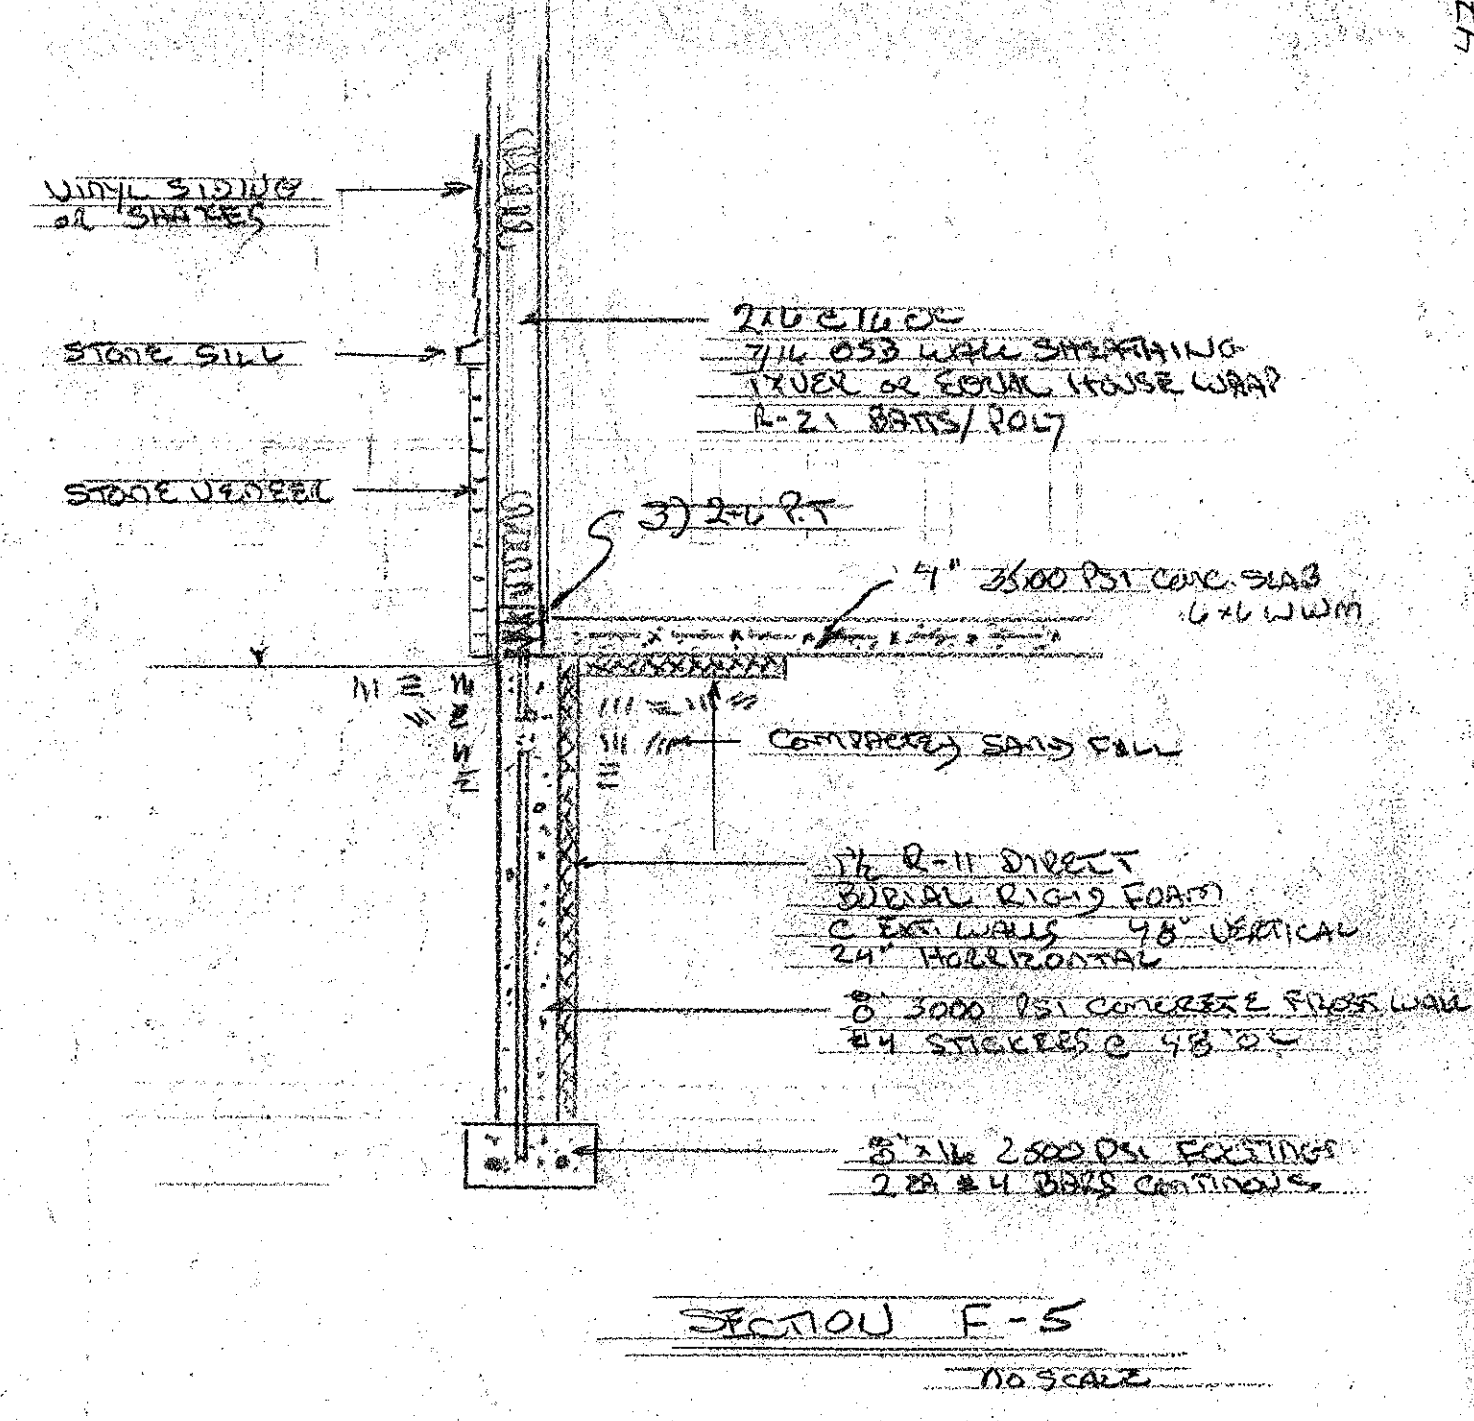


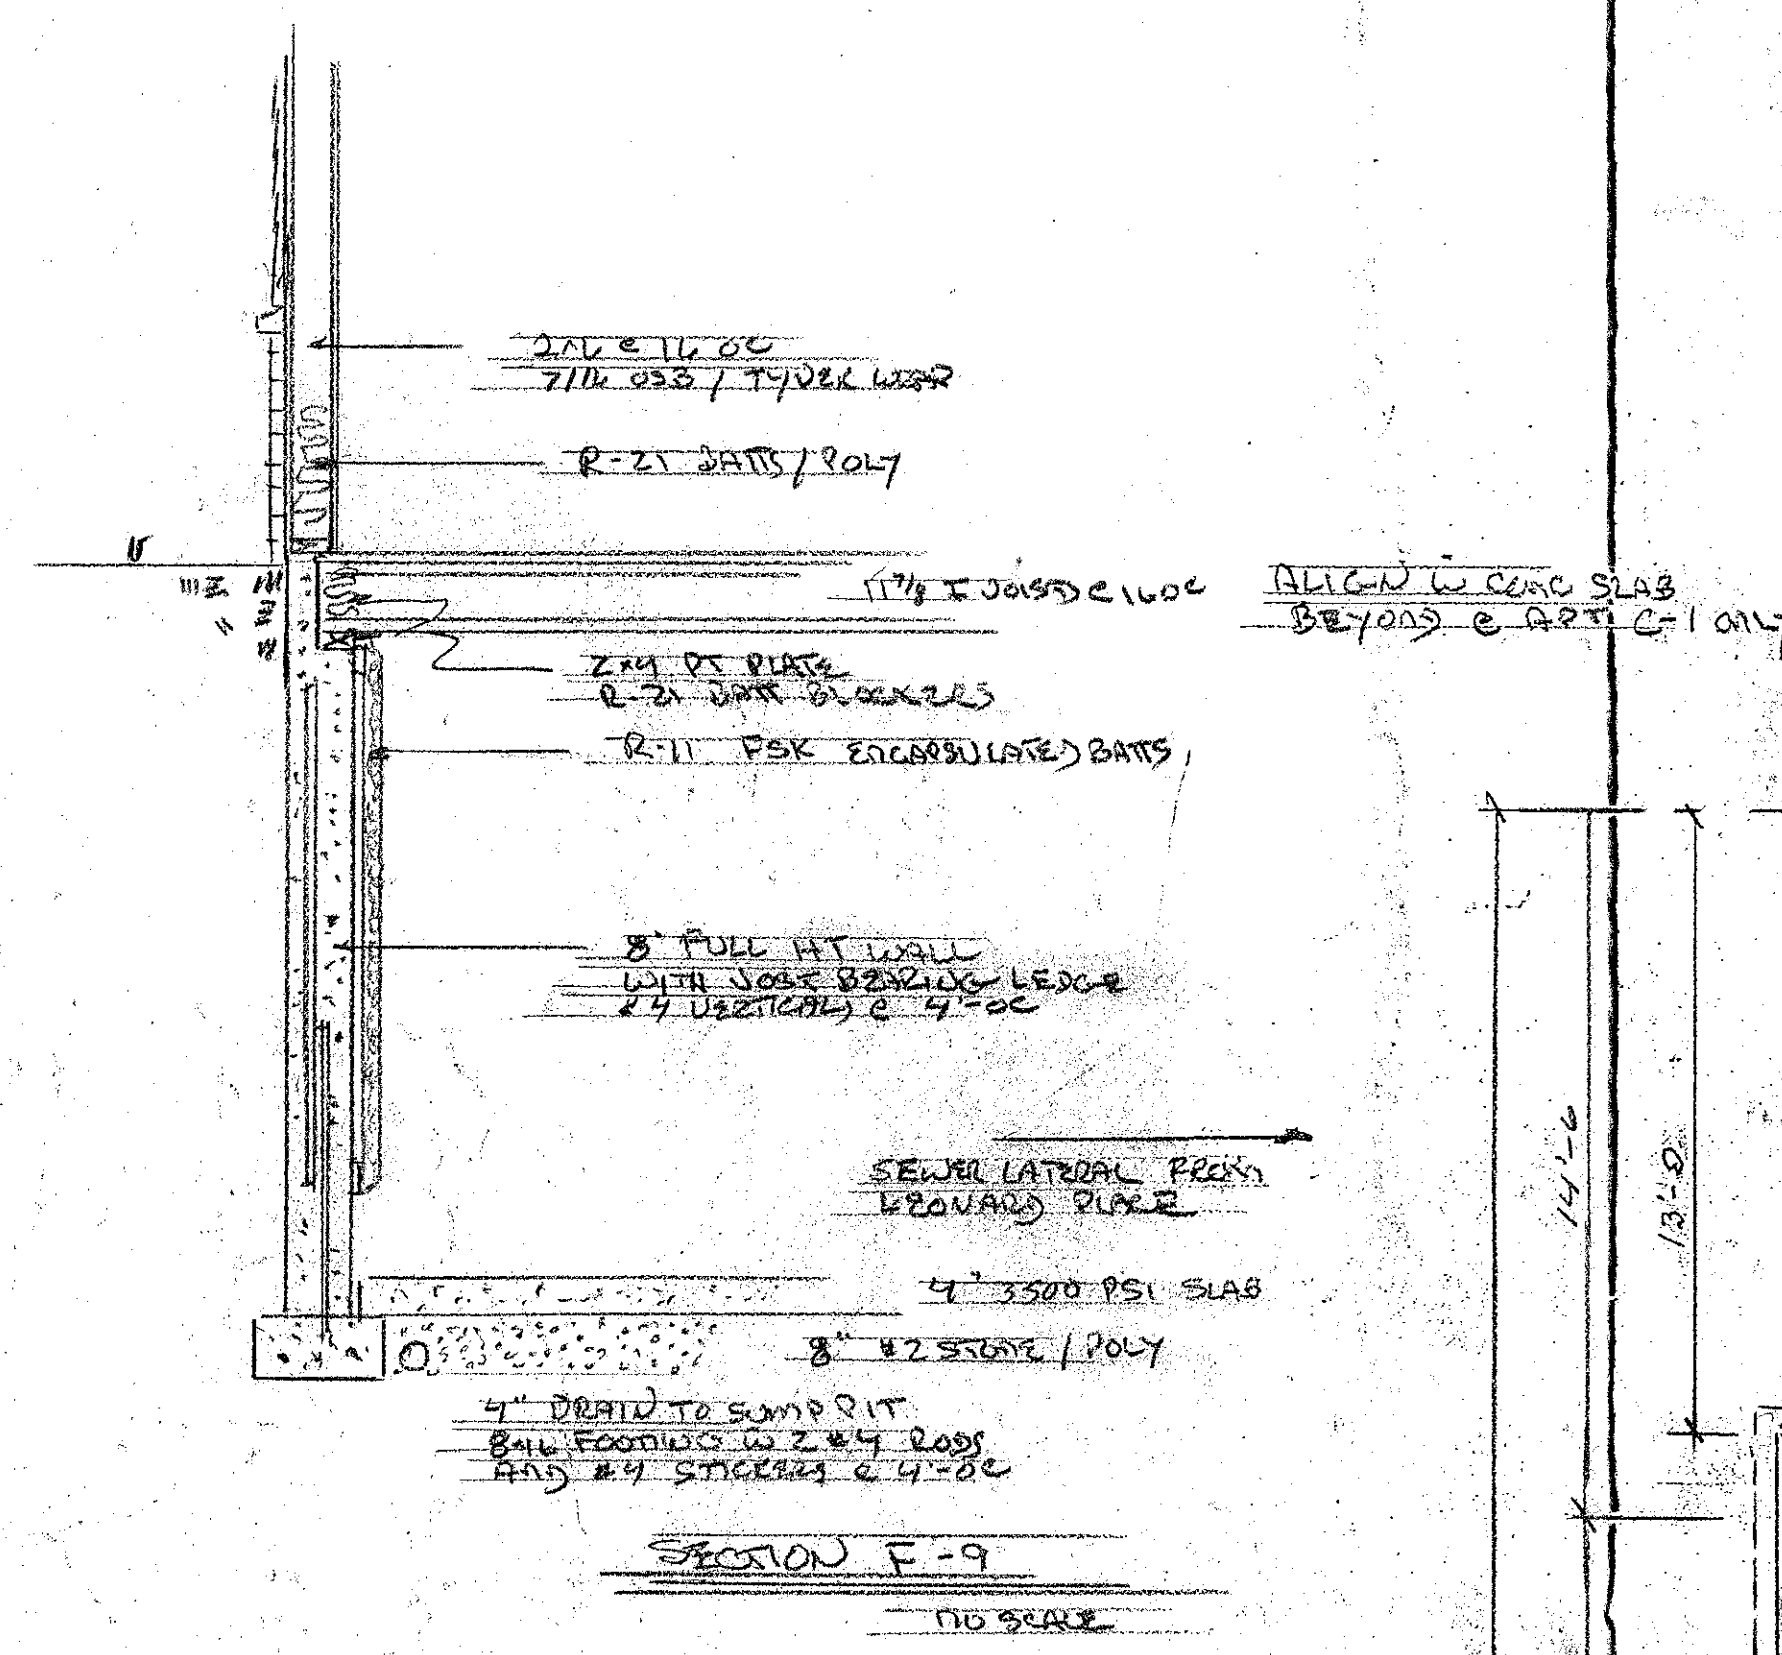


FOUNDATION PLAN
1/4" = 1'-0"

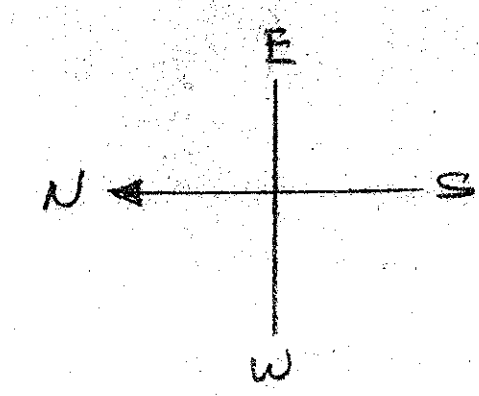

UNDERGROUND
ELECTRICAL SERVICE
FROM EXIST. POE

WATER SERVICE
FROM DELAWARE AVE

TOWN OF BETHLEHEM
PLANNING BOARD

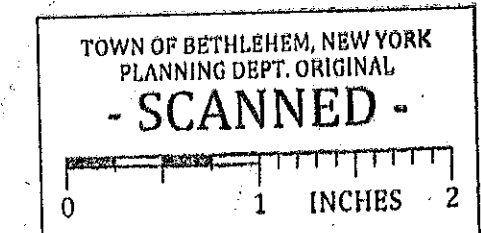

PLANNING BOARD
TOWN OF BETHLEHEM
ALBANY COUNTY, NEW YORK
By direction of the Chairman.
These drawings are hereby approved.
See sheet(s) 1 of 8
for date and signature.

KEYSTONE FIRST APARTMENTS 225 DELAWARE AVE DELMAR NY			
SCALE: 1/4" = 1'-0"	APPROVED BY:		DRAWN BY SM3
DATE: 10-16-15	REV 4-28-16		REVISED: 5-4-16
KEYSTONE BUILDINGS INC 5 ELM AVE DELMAR NY			
FOUNDATION PLAN misc DETAILS			DRAWING NUMBER 8 of 8