

LEGEND


CURB & SIDEWALK	
PAVED ROAD	
UNPAVED ROAD	
TRAIL & CULVERT	
INDIVIDUAL TREE	
TREE AREA	
DRAINAGE	
SWAMP	
BUILDING	
FENCE & HEDGE	
VERTICAL INTERVAL	
SPOT ELEVATION	
POST & MAIL BOX	
POLE	
PROPOSED MANHOLE	
EXISTING MANHOLE	
PROPOSED CATCH BASIN	
EXISTING CATCH BASIN	
SIGN	
EXISTING WATER VALVE	
SOIL BORING	
NEW VALVED HYDRANT	
NEW WATER MAINS	
NEW VALVE & VALVE BOX	
EXISTING VALVED HYDRANT	
EXISTING WATER MAINS	
EXISTING VALVE & VALVE BOX	
EXISTING GAS MAINS	
UNDERGROUND CABLE	
FORCE MAIN	
EXISTING SANITARY SEWER	
PROPOSED SANITARY SEWER	
EXISTING STORM SEWERS	
PROPOSED STORM SEWER	
PROPOSED UNDERDRAIN	
PROPOSED CURBING	
PROPERTY LINE	
RIGHT OF WAY OR EASEMENT FOR NEW WATER MAINS	

ALUM.	- ALUMINUM	JT.	- JOINT
APPROX.	- APPROXIMATE	L	- LENGTH
A.O.B.E.	- AS ORDERED BY ENGINEER	MFD.	- MANUFACTURED
ASSY.	- ASSEMBLY	MFR.	- MANUFACTURER
B.	- BASE LINE	MAX.	- MAXIMUM
B.W.	- BOTH WAYS	M.J.	- MECHANICAL JOINT
BOT.	- BOTTOM	MI.	- MILE (S)
B.V.	- BUTTERFLY VALVE	MIN.	- MINIMUM
B.F.	- BOTH FACES	NOM.	- NOMINAL
C.I.	- CAST IRON	N.T.S.	- NOT TO SCALE
C.I.P.	- CAST IRON PIPE	OS.	- OFFSET
CL.	- CLEARANCE	OC.	- ON CENTER
C.	- CENTER LINE	OP.	- OPERATOR
CONC.	- CONCRETE	O.G.	- ORIGINAL GRADE
CONN.	- CONNECTED	OH.	- OVERHEAD
CONT.	- CONTRACTOR	PERF.	- PERFORATED
CU	- COPPER	P.E.	- PLAIN END
CORP.	- CORPORATION	R	- PLATE STEEL
C.M.P.	- CORRUGATED METAL PIPE	PL.	- PLUMBING
CYL.	- CYLINDER	PVC	- POLYVINYL CHLORIDE
D	- DEPTH	P.S.I.	- POUNDS PER SQUARE INCH
DIA.	- DIAMETER	P.S.L.	- PRESSURE SENSING LINE
DIST.	- DISTRIBUTION	R	- PROPERTY LINE
D.G.V.	- DOUBLE GATE VALVE	R.	- RADIUS
D.I.	- DUCTILE IRON	REF. NO.	- REFERENCE NUMBER
D.I.P.	- DUCTILE IRON PIPE	REQ'D	- REQUIRED
E.C.	- ELECTRICAL CONTRACTOR	R.W.	- RESILIENT WEDGE GATE
ELEC	- ELECTRIC	SCH.	- SCHEDULE
EL.	- ELEVATION	SHT.	- SHEET
ENG'R.	- ENGINEER	SPEC.	- SPECIFIED
EQUIP	- EQUIPMENT	SQ.	- SQUARE
EXIST.	- EXISTING	STD.	- STANDARD
EXP.	- EXPANSION	T.W.L.	- TAILWATER LEVEL
EXT.	- EXTERIOR	TEL.	- TELEPHONE
FAB.	- FABRICATED	THD.	- THREAD
F.F.	- FINISHED FLOOR	T.G.	- TURBINE/GENERATOR
FLG.	- FLANGE	TYP.	- TYPICAL
FT.	- FOOT	V	- VALVE
GAL.	- GALLON	VERT.	- VERTICAL
GALV.	- GALVANIZED	W.	- WIDTH
G.C.	- GENERAL CONTRACTOR	W/	- WITH
GEN.	- GENERATOR		
H.V.	- HEATING & VENTILATION CONTRACTOR		
H.	- HEIGHT		
HORIZ.	- HORIZONTAL		
H.P.	- HORSEPOWER		
HYD.	- HYDRAULIC		
INV.	- INVERT		

STANDARD ABBREVIATIONS

INDEX

- COVER SHEET
- LEGEND, INDEX & ABBREVIATIONS
- PROJECT SITE PLAN-SOUTH SECTION
- PROJECT SITE PLAN-NORTH SECTION
- PLAN-SAGE LANE & FOXFIRE LANE
- PLAN-FIELDS END DRIVE & COLUMBINE DRIVE
- PLAN-FIELDS END DRIVE & COLUMBINE DRIVE
- PLAN-LOWER BOUNDARY
- PLAN-WALDEN COURT & PASTURE GATE LANE
- PLAN-UPPER LOTS
- PROFILE-PASTURE GATE LANE
- PROFILE-WALDEN COURT & SAGE LANE
- PROFILE-COLUMBINE DRIVE
- PROFILE-COLUMBINE DRIVE & FIELDS END DRIVE
- PROFILE-FIELDS END DRIVE
- PROFILE-SANITARY SEWER
- PROFILE-THISTLE LANE, STORM SEWER EASEMENT
- WALDEN CT. OUTFALL PROFILES-SANITARY & STORM
- PROFILES-STORM SEWER OUTFALL
- PROFILES-STORM SEWER OUTFALL
- HEADWALL DETAILS, COLONIAL ACRES INTERCONNECTION
- TOWN OF BETHLEHEM WATER DISTRIBUTION
- TOWN OF BETHLEHEM STORM DRAINAGE & HIGHWAY DETAILS
- TOWN OF BETHLEHEM SANITARY SEWER DETAILS
- SPECIFICATIONS
- SPECIFICATIONS

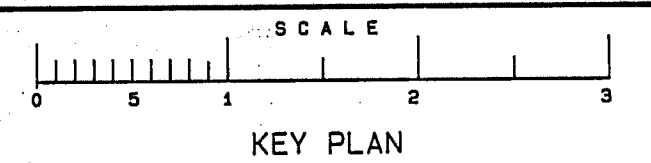

NOTES


UNAUTHORIZED ALTERATIONS OR ADDITIONS TO THIS DOCUMENT IS A VIOLATION OF SECTION 7209 SUBDIVISION 2 OF THE NEW YORK STATE EDUCATION LAW

DATE	BY	DESCRIPTION	SYMBOL

J. KENNETH FRASER
AND ASSOCIATES, P.C.
CONSULTING ENGINEERS
RENSSELAER, NEW YORK

R & R
ASSOCIATES

THE MEADOWS
SUBDIVISION

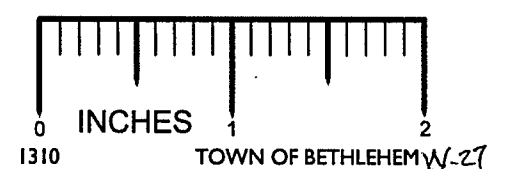

TOWN OF BETHLEHEM
NEW YORK

SCALE: AS NOTED



PROJ. ENG'R: JFB
DRAWN BY: HLW
ASSEMBLED BY: EUS
CHECKED BY: JKF

REF. NO. 238645.002

SHEET TITLE: LEGEND,
INDEX & ABBREVIATIONS

DATE: JANUARY 1987 SHEET 2 OF 26