


WINDOW SCHEDULE				
NO.	W	H	REMARKS	MANUFACT.
1			DBL HUNG	PELLA
2	33-5/16"	19/16"	HALF ROUND	IROQUIS
3	1'-4"		HALF ROUND	IROQUIS #256 (2 REQ'D)

DOOR SCHEDULE							
#	SIZE			DOOR MAT'L	TYPE	FRAME MAT'L	H'WARE
1	3'-0"	7'-4"	13/4"	STEEL	A	STEEL	1, 2


PIPING SCHEDULE				
NO.	SIZE	JOINT	DESCRIPTION	QTY.
1	16"	FL	PRESSURE REDUCING VALVE	1
2	16"	FL	BUTTERFLY VALVE	3
3	16" X 10"	FL	TEE	2
4	16"	FL	90° BEND	2
5	10"	FL	LONG RADIUS 90° BEND	2
6	10"	FL	PRESSURE REDUCING VALVE	1
7	10"	FL	BUTTERFLY VALVE	2
8	10"	FL	SPOOL PIECE	2
9	16"	FL	TEE	2
10	16"	FL	SPOOL PIECE	2
11	16"	MJ	WALL SLEEVE	2
12	16"	MJ	METAL PIPE SUPPORTS	4
13	3/4"	TAP	PRESSURE GAGES	2

NOTE:
1 LINTEL OVER ALL OPENINGS
FOR C.M.U., 2L'S-6X4X3/8"
X (OPENING + 1')
2. LEXAN VANDEL PROOF STORMS
AND VINYL SHUTTERS
FOR ALL WINDOWS

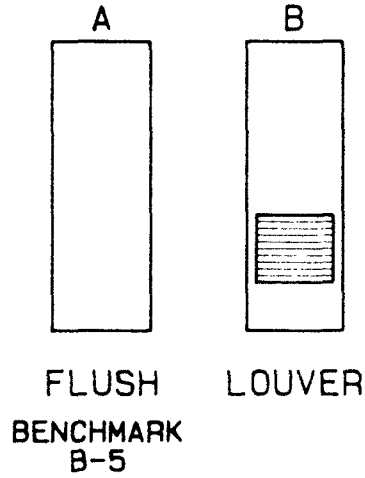

HARDWARE
1-EXIT PANIC DEVICE
2-CYLINDER LOCKS
3-
4-
5-

ALL DOORS
S.D.I. TYPE 11-18 GA.
16GA. GAL. FRAME
ALUM. THRESHOLD
1-1/2 PR. BUTT HINGES
EXTERIOR WEATHERSTRIPPING

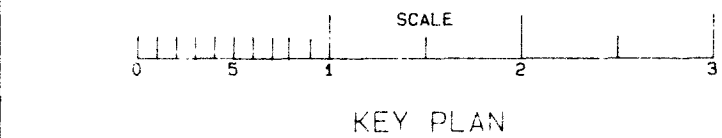

NOTES
1. ALL CONC. FLOORS SHALL USE SILICA QUARTZ POWDER HARDNER AT 40 LBS/100 S.F.
2. PROVIDE PIPED DRAINAGE FROM BOTH P.R.V.'S TO SUMP. USE 1-1/2" SCH. 40 PVC.


UNAUTHORIZED ALTERATIONS OR ADDITIONS TO THIS DOCUMENT IS A VIOLATION OF SECTION 7209 SUBDIVISION 2 OF THE NEW YORK STATE EDUCATION LAW

DATE	BY	DESCRIPTION	SYMBOL

J. KENNETH FRASER
AND ASSOCIATES, P.C.
CONSULTING ENGINEERS
RENSSELAER, NEW YORK

TOWN OF BETHLEHEM
ALBANY COUNTY NEW YORK
PUMP STATION AND
PRESSURE REDUCING
VALVE STATION

CONTRACT NO. 3G
GENERAL CONSTRUCTION
AND/OR
CONTRACT NO. 3E
ELECTRICAL WORK


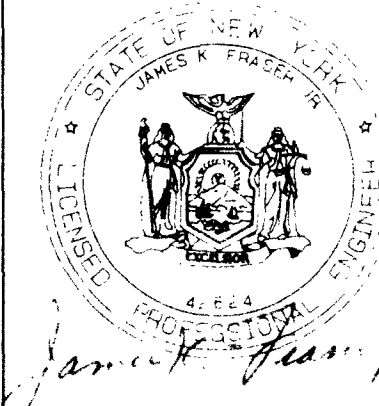


DESIGNED BY JKF
DRAWN BY BGG
CHECKED BY BGG
APPROVED BY JKF



REV. NO. 001
REV. DATE 12/84

PRV STATION
FOUNDATION & FLOOR PLAN

 APRIL 1985

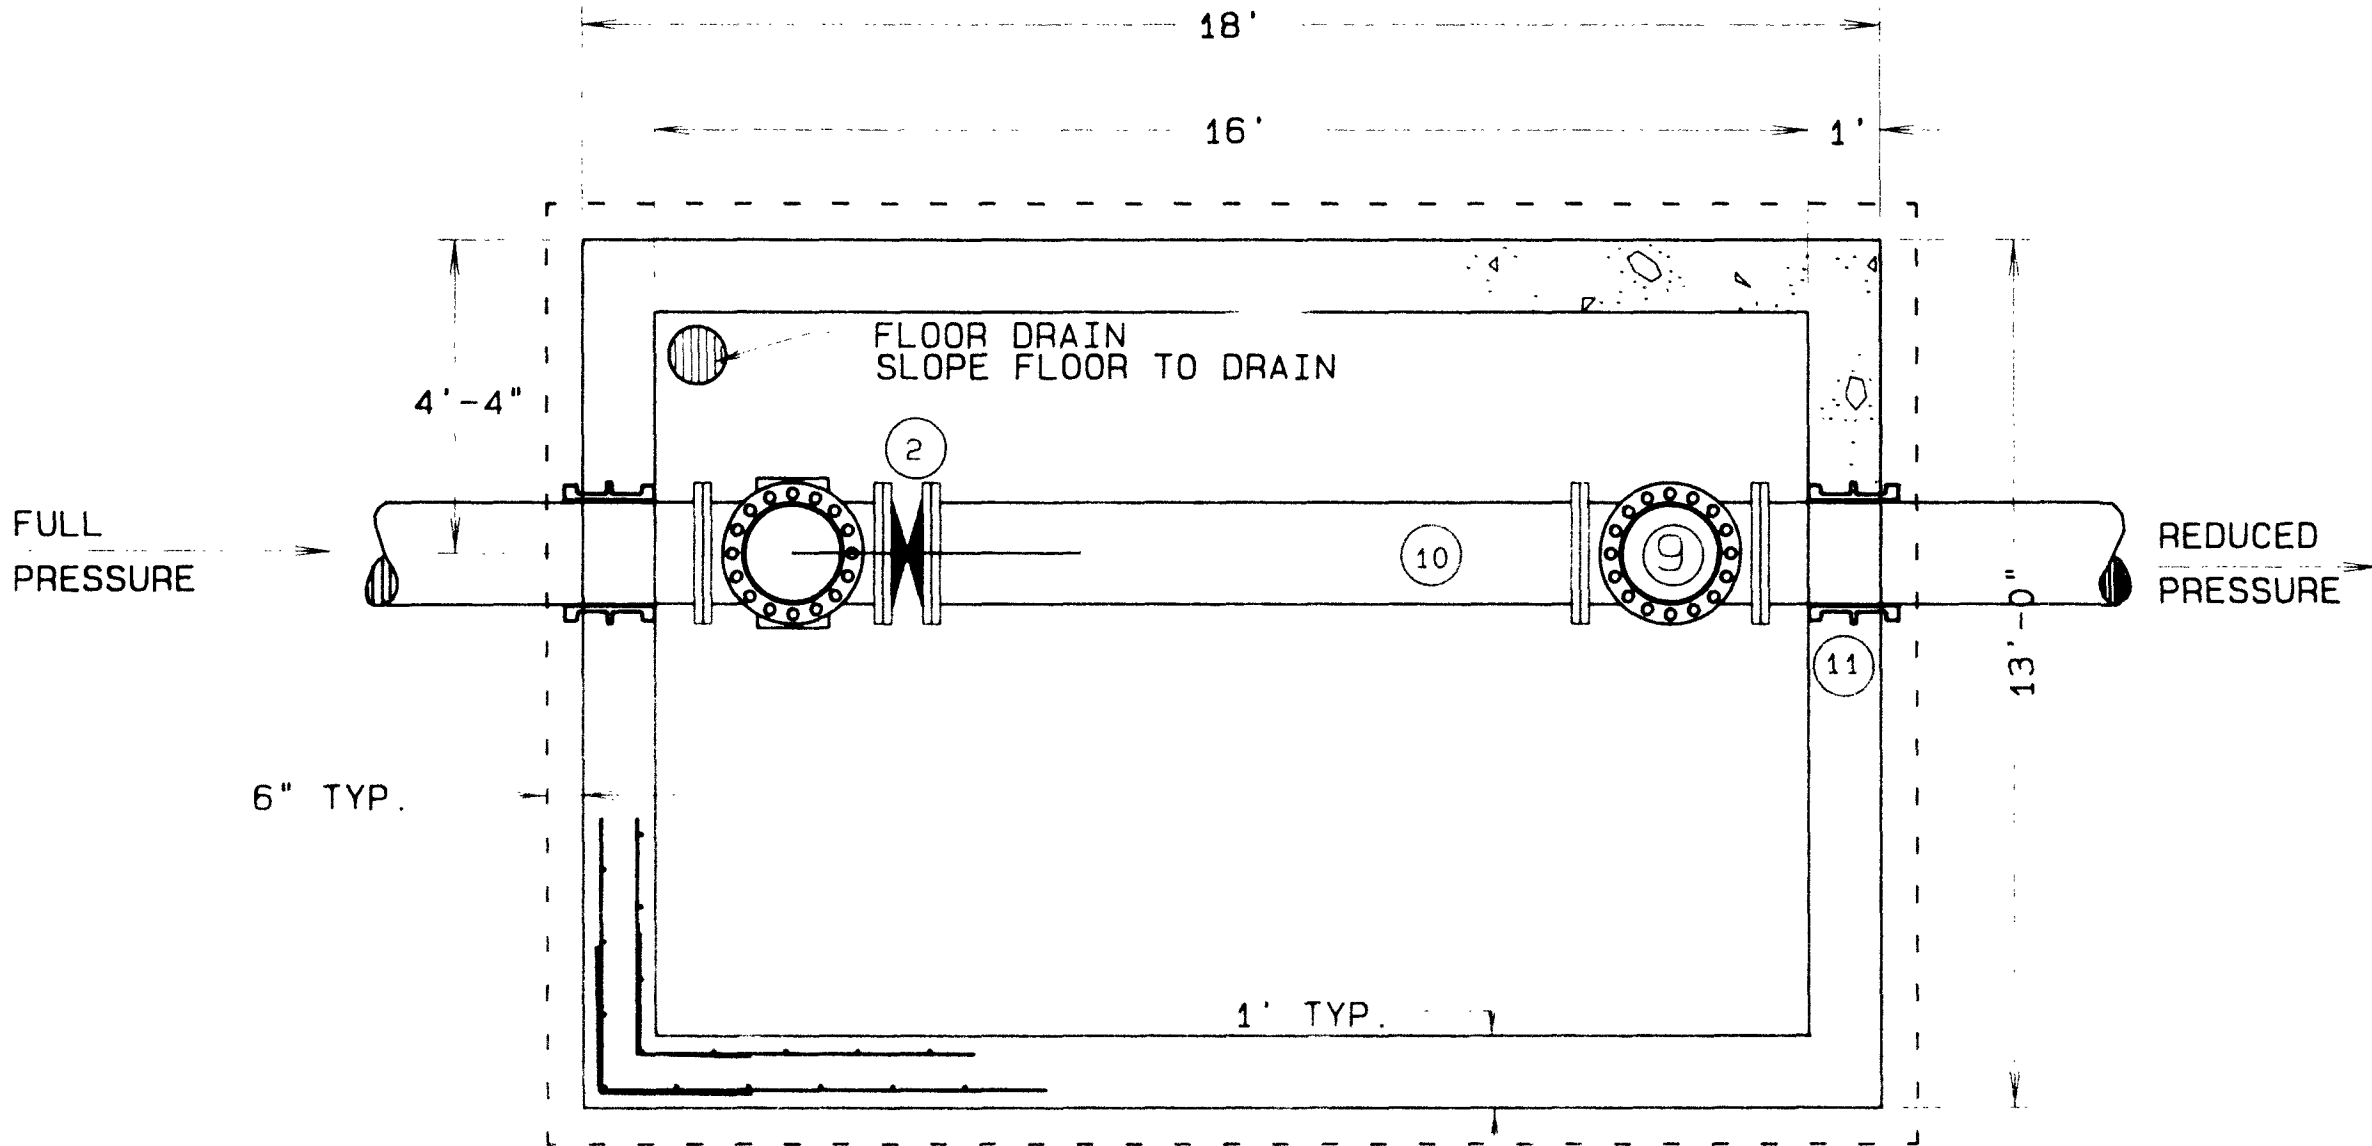

 PRV STATION FOUNDATION PLAN
SCALE: 3/8"=1'-0"

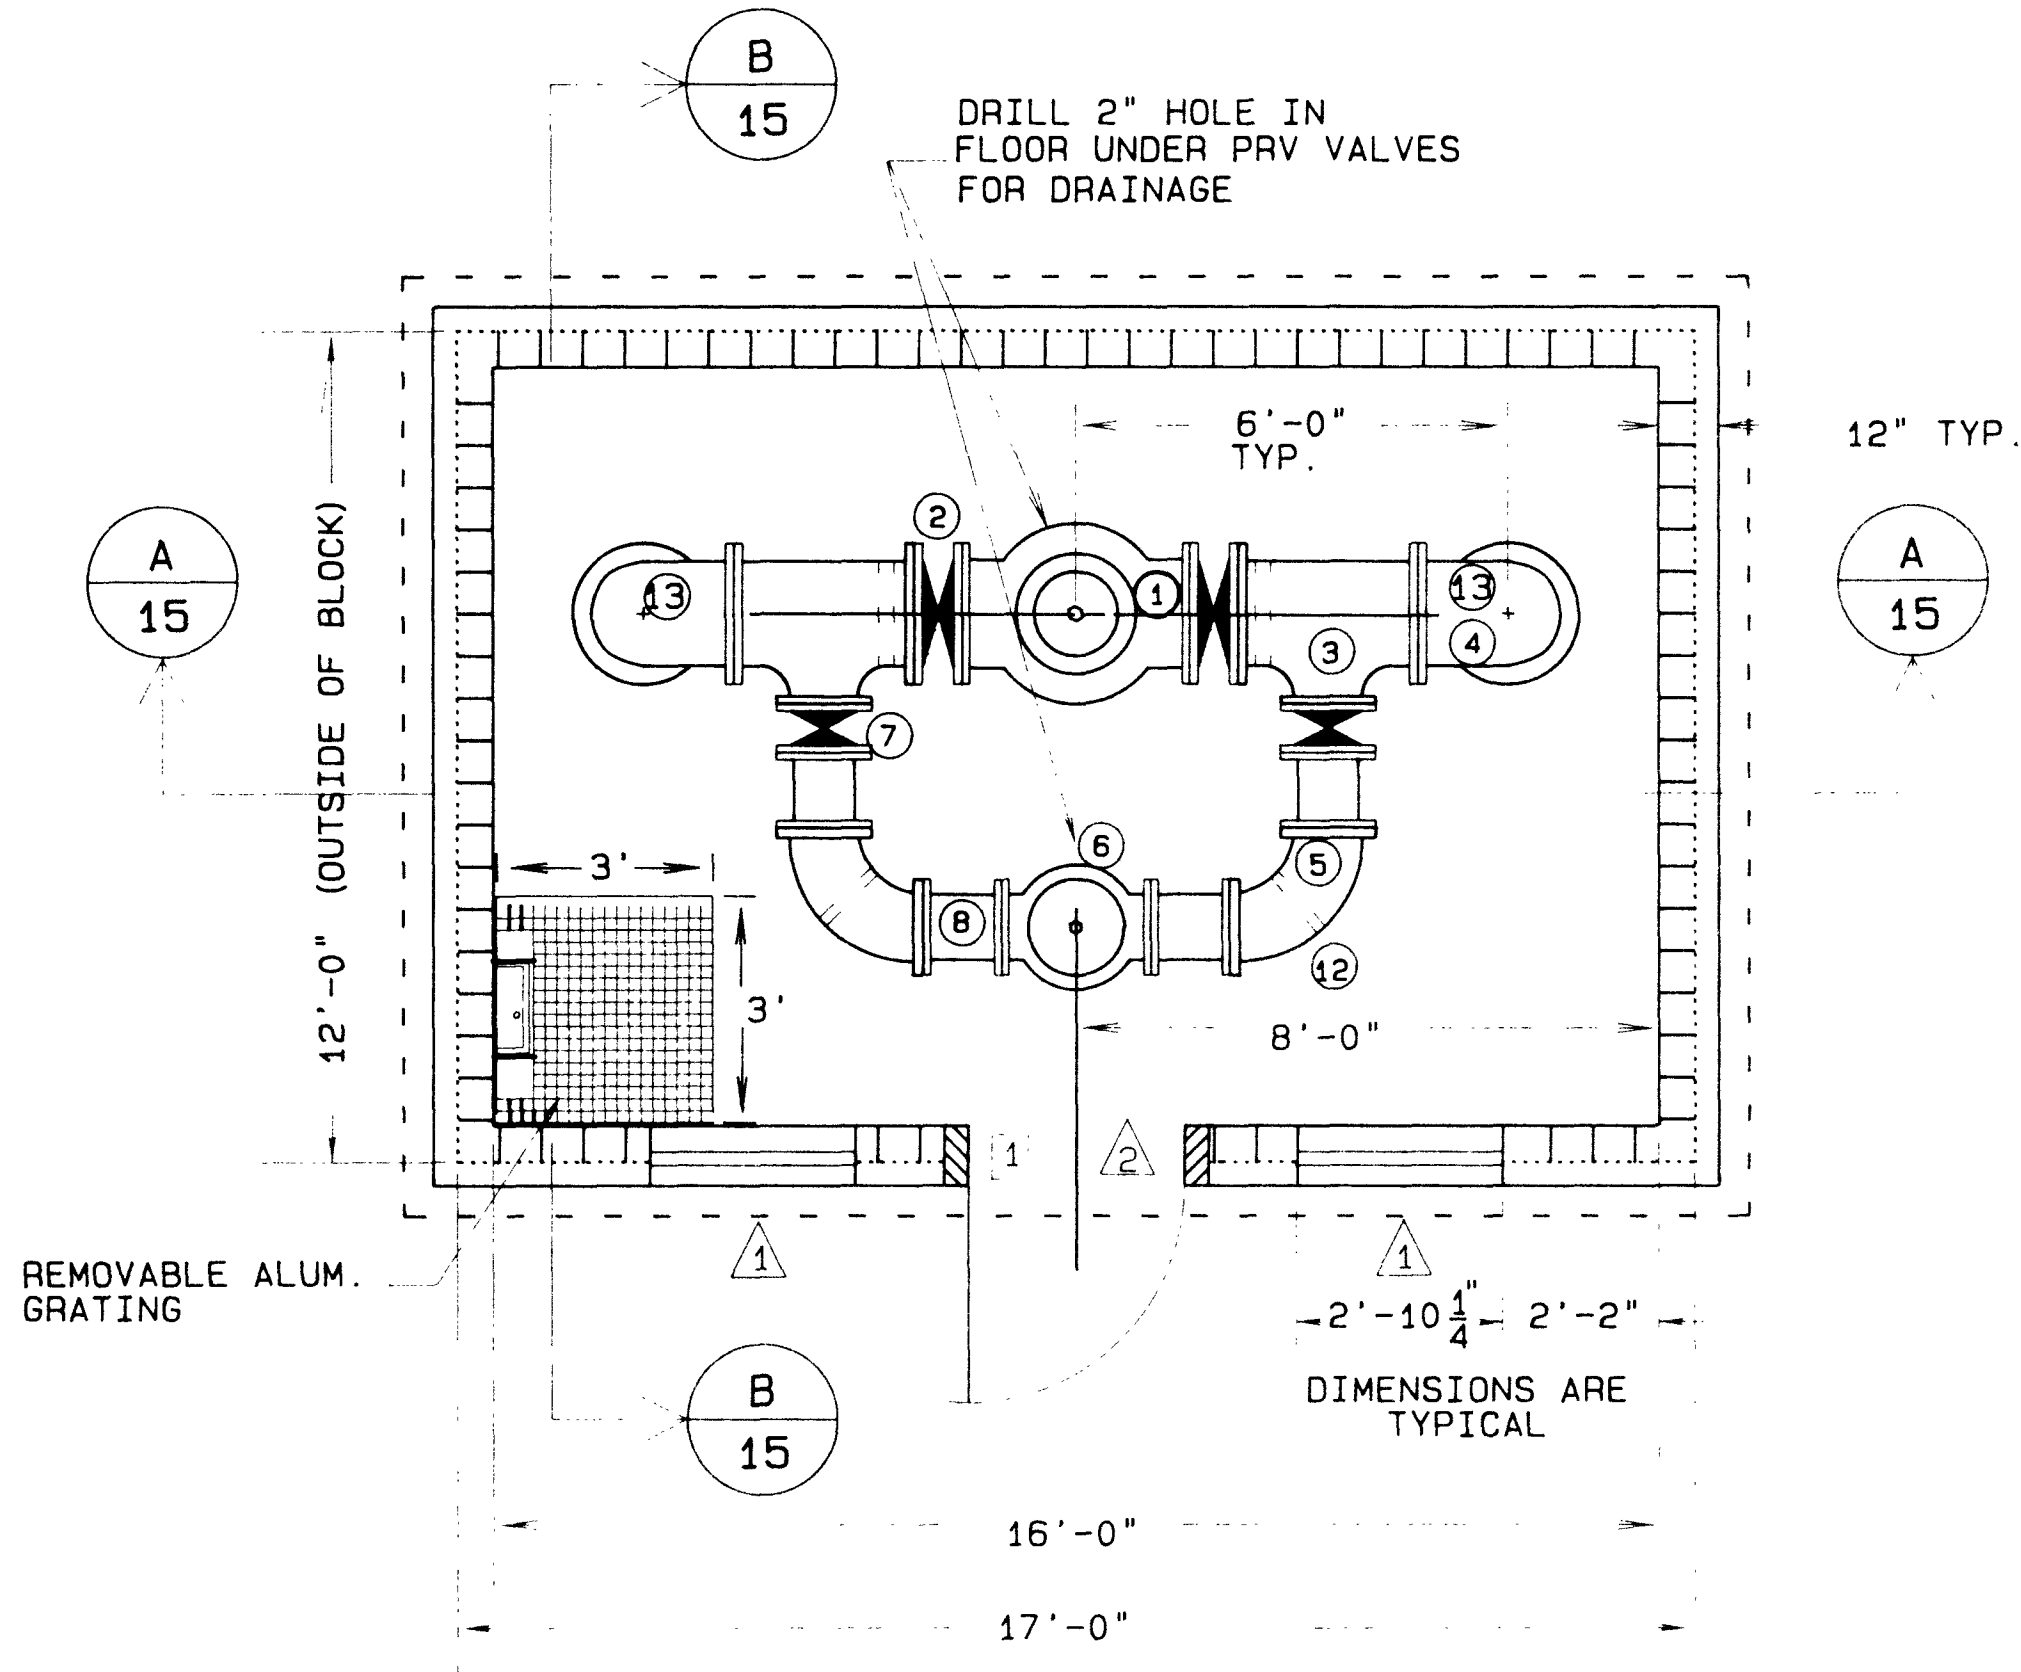

PRV STATION PLAN
SCALE: 3/8"=1'-0"

