


ELM AVENUE PARK POOL COMPLEX

FACILITY UPGRADE


TOWN OF BETHLEHEM, NEW YORK

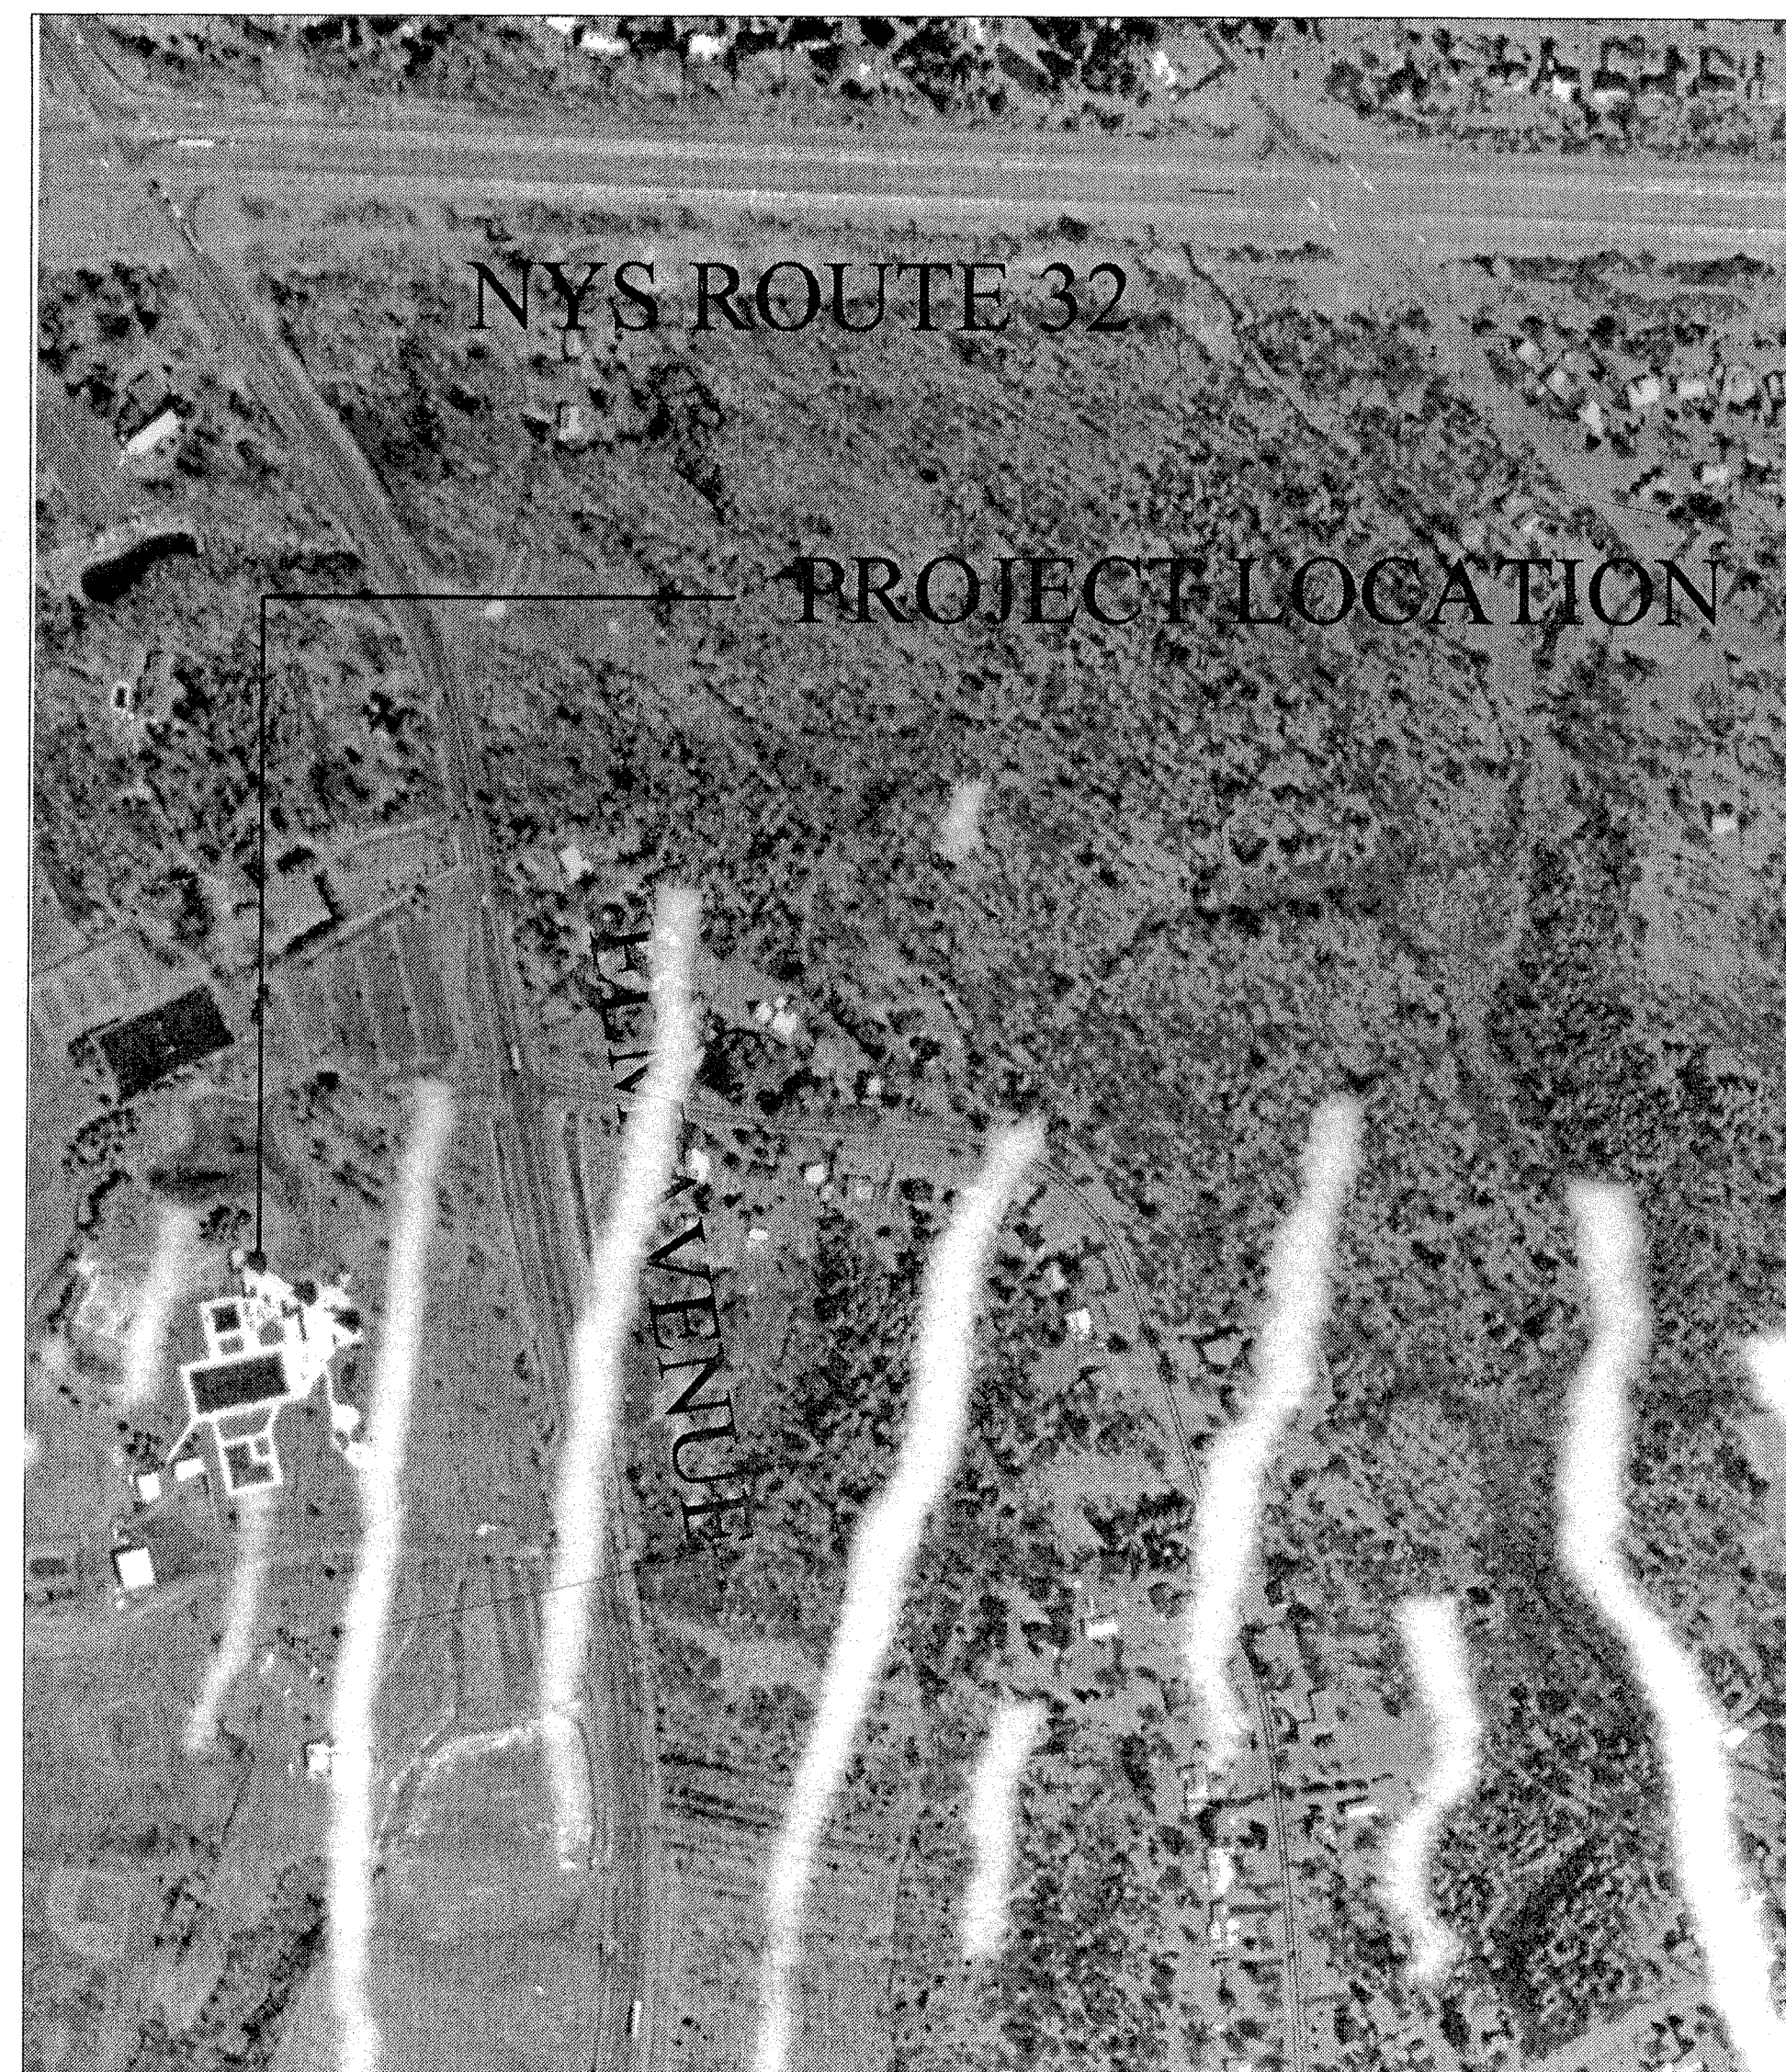

SITE LOCATION MAP
NOT TO SCALE


SHEET INDEX

SHEET TITLE	DRAWING NO.
TITLE SHEET	T-1
LEGEND	L-1
DEMOLITION PLAN	C-1
LAYOUT PLAN	C-2
GRADING PLAN	C-3
UTILITY PLAN	C-4
ANCHOR PLAN	C-5
ELECTRICAL SITE PLAN - DEMOLITION	E-1
ELECTRICAL SITE PLAN - POWER & LIGHTING	E-2
ELECTRICAL SITE PLAN - BONDING	E-3
DETAILS & DIAGRAMS	E-4
DETAIL SHEET	D-1
DETAIL SHEET	D-2

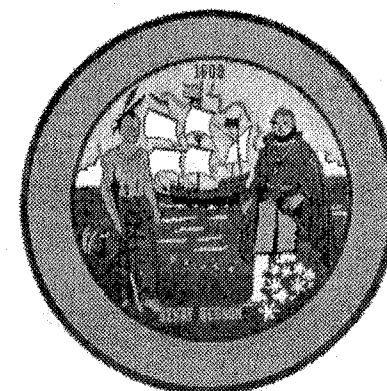

PREPARED FOR:
TOWN OF BETHLEHEM
PARKS AND RECREATION DEPARTMENT
261 ELM AVENUE
DELMAR, NEW YORK 12054
(518) 439-4131

JULY 2, 2003

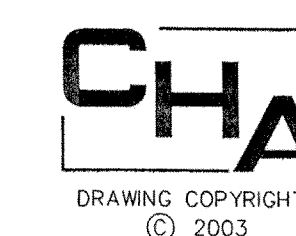

CLOUGH, HARBOUR & ASSOCIATES LLP
ENGINEERS, SURVEYORS, PLANNERS
& LANDSCAPE ARCHITECTS
III WINNERS CIRCLE - ALBANY, NEW YORK - 12205
P.O. BOX 5269 518-453-4500
www.cloughharbour.com

CHA Project No. 12372.1000.1103

Drawing No.

T-1
2-27