

 


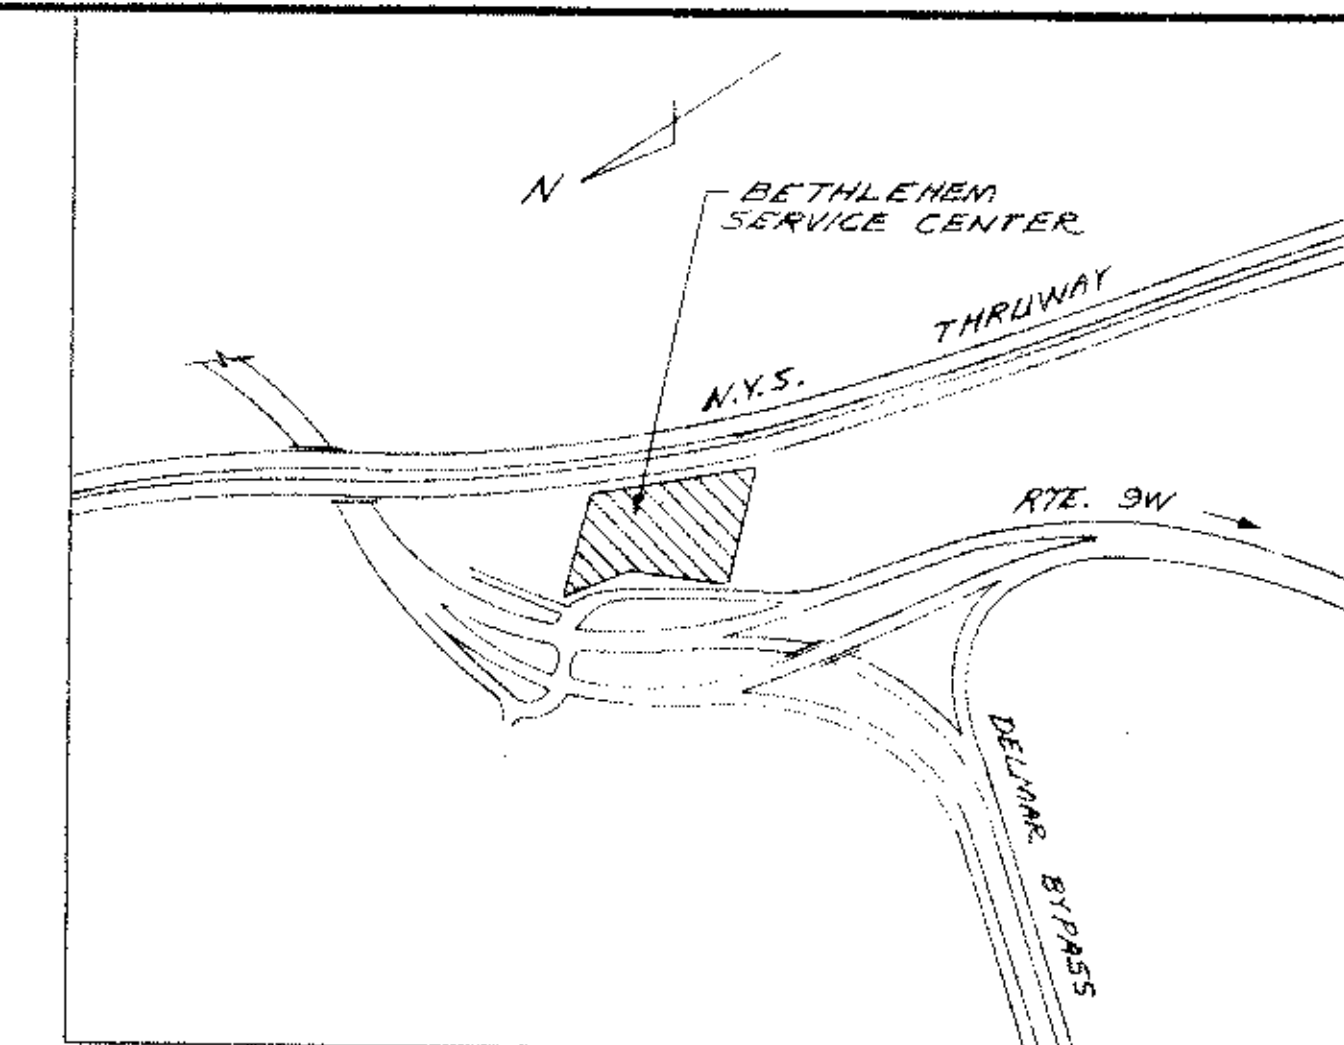

LOCATION PLAN
SCALE: 1" = 600' APPROX.

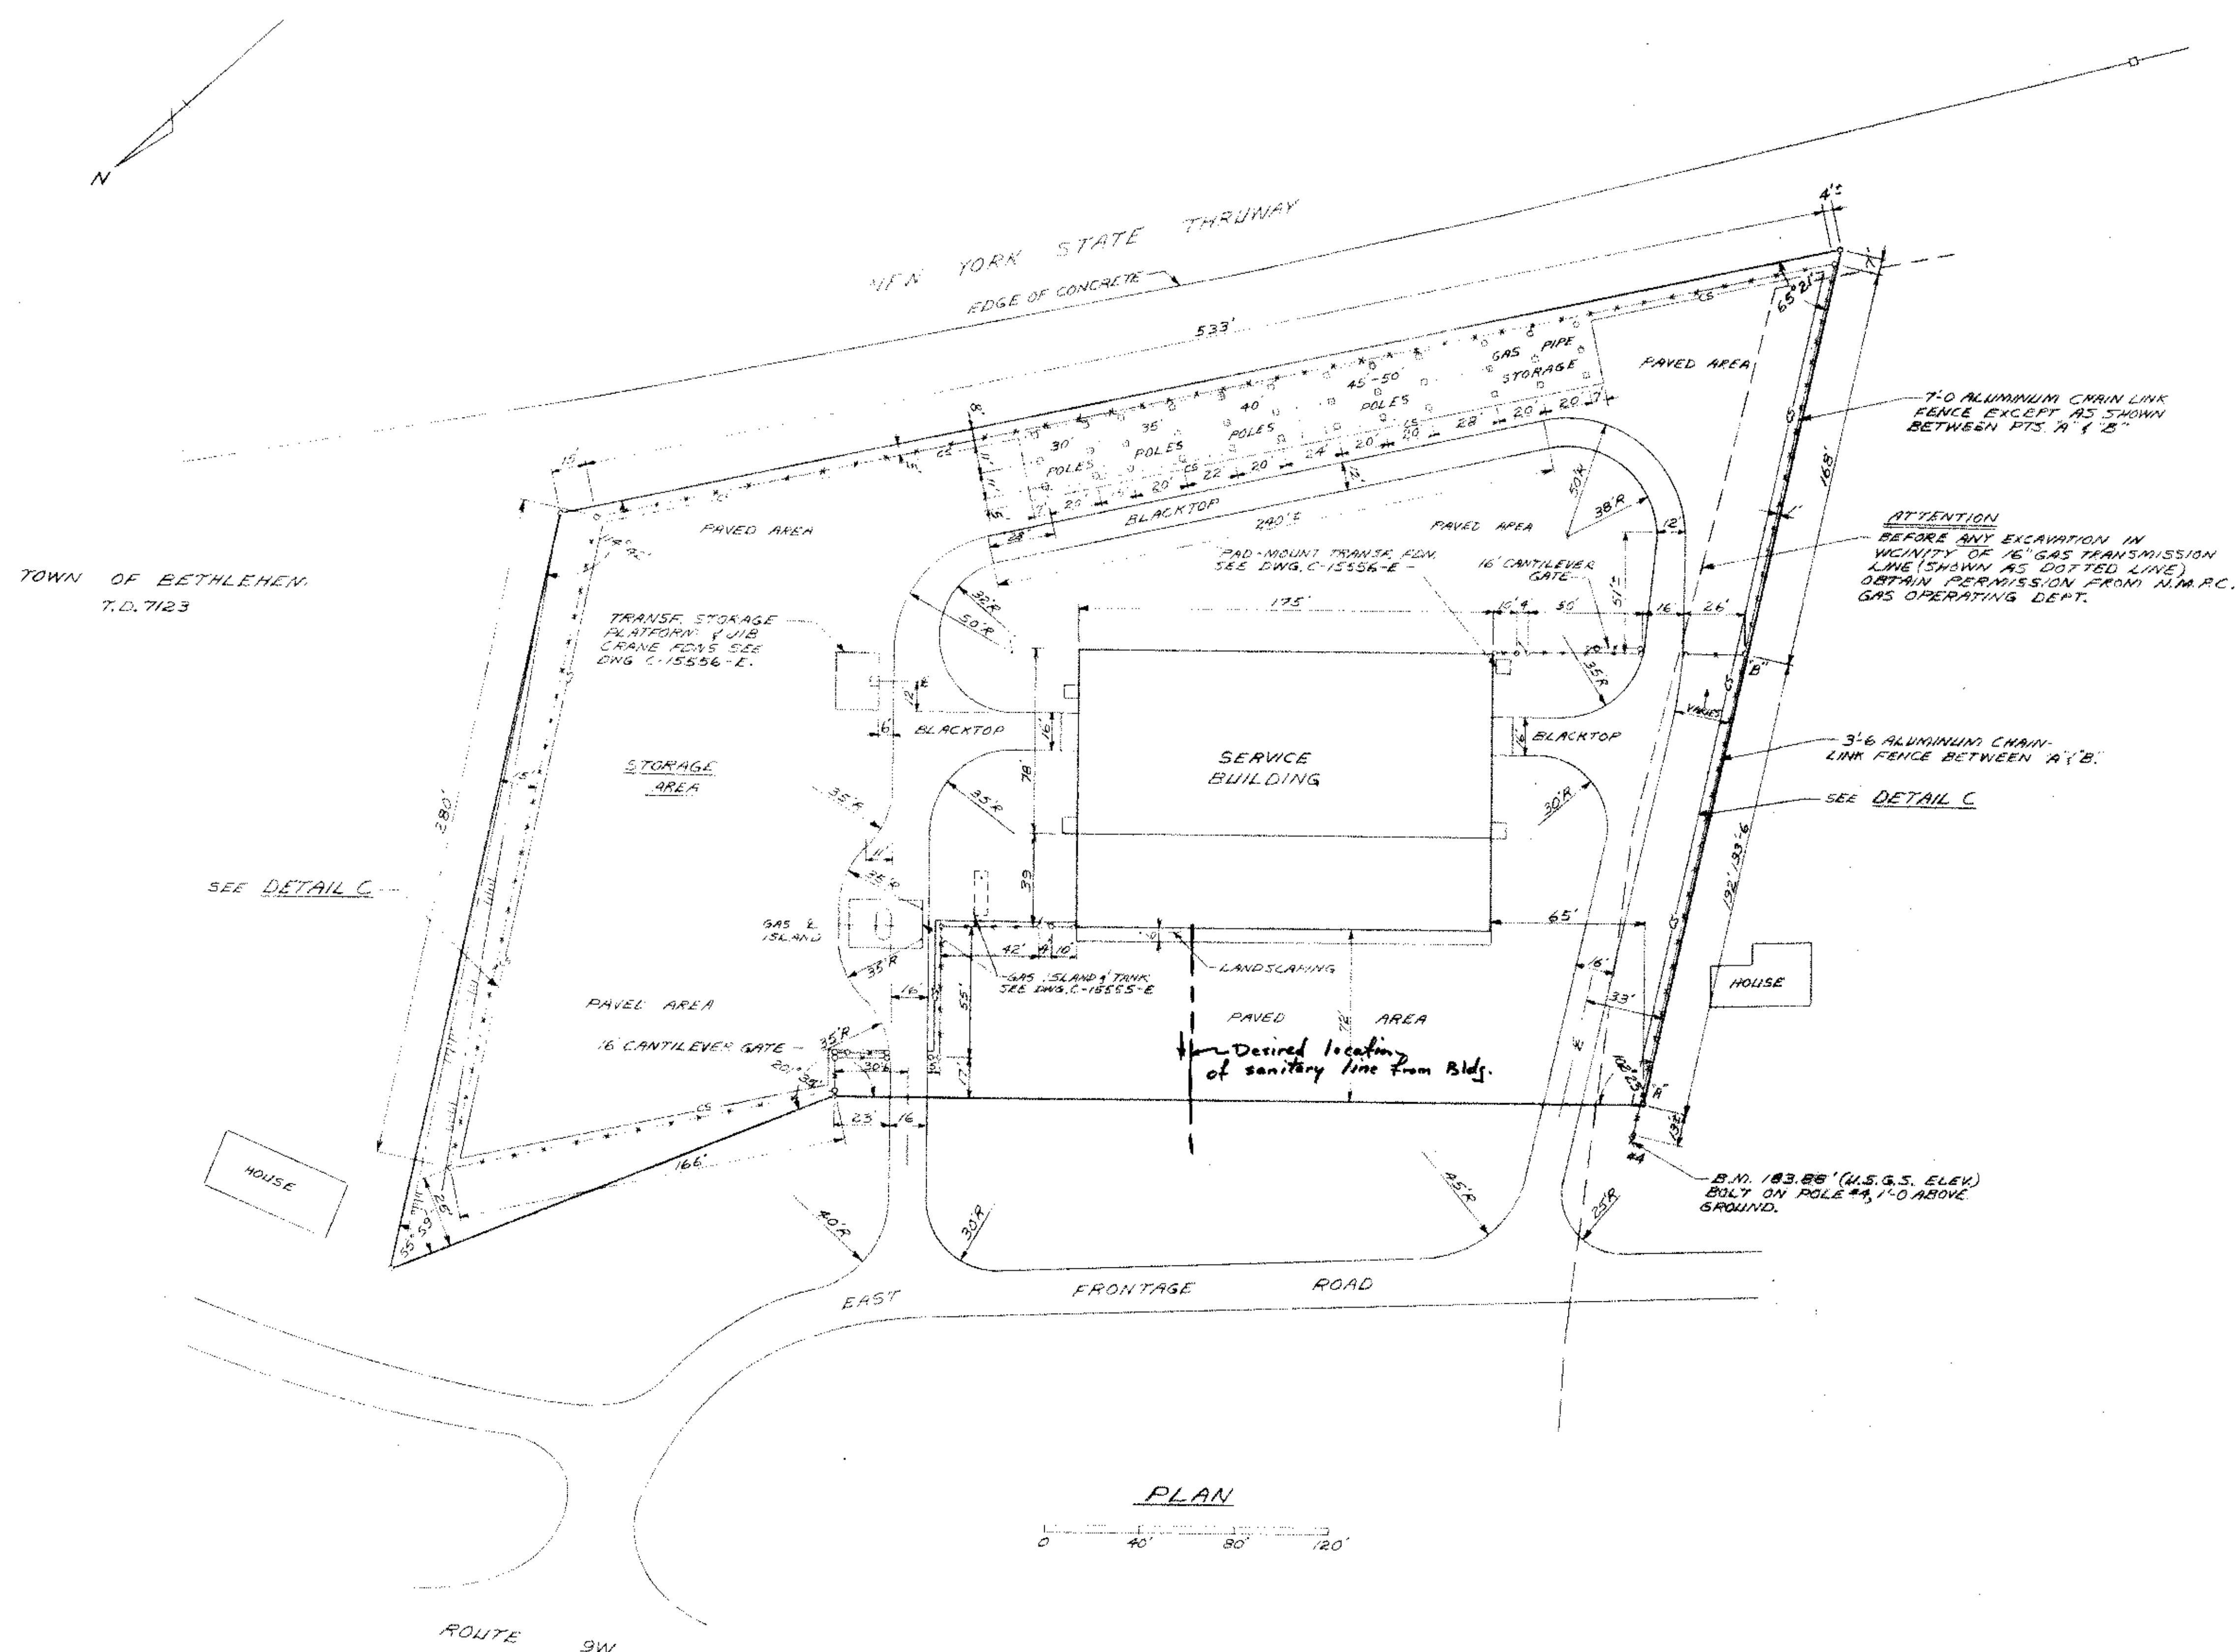

PLAN



- NOTES:
1. GRADING: ALL GRADING IS TO BE AS SHOWN ON "GRADING PLAN" DWG. C-15540-E; LANDSCAPING PLAN AND DETAILS, DWG. C-15543-E AND AS IN SPECIFICATIONS.
 2. FENCE: PERIMETER STONE SURROUNDING BLACKTOP/PAVED AREAS - ALL OF THESE ITEMS ARE TO BE AS SHOWN ON THIS DRAWING AND AS PER SPECIFICATIONS.
 3. UTILITIES: SANITARY SYSTEM, DRYWELLS, DRAINS, WATER LINES, CONDUITS, YARD LIGHTS, GAS LINE & PLUMBING ARE SHOWN ON DWG. C-15540-E.

PRELIMINARY



STR. 6032

NIAGARA MOHAWK

NIAGARA MOHAWK POWER CORPORATION
SYRACUSE, N.Y.

GLENMONT SERVICE CENTER
SITE PLAN

GRADING PLAN	C-15540-E	BUILDING CROSS SECTION	C-15551-E
UTILITIES PLAN	C-15542-E	TYR WALL SECTIONS & DETAILS	C-15552-E
LANDSCAPING PLAN	C-15543-E	HEATING & LIGHTING PLANS	C-15553-E
FOUNDATION PLAN	C-15544-E	ELECTRICAL PLAN	C-15554-E
STEEL FRAMING PLAN	C-15545-E	GASOLINE ISLAND INSTALLATION	C-15555-E
STEEL DETAILS	C-15546-E	JIB CRANE STORAGE PLATFORM, ETC.	C-15556-E
FLOOR PLAN	C-15547-E	POLE SKIDS	C-15557-E
ENLARGED FLOOR PLAN	C-15548-E	MISC. SECT. & DETAILS	C-15558-E
ROOF PLAN	C-15549-E		
WALL ELEV., DOOR & WINDOW DETAILS	C-15550-E		
REFERENCE DESCRIPTION	DWG. NO.	REFERENCE DESCRIPTION	DWG. NO.

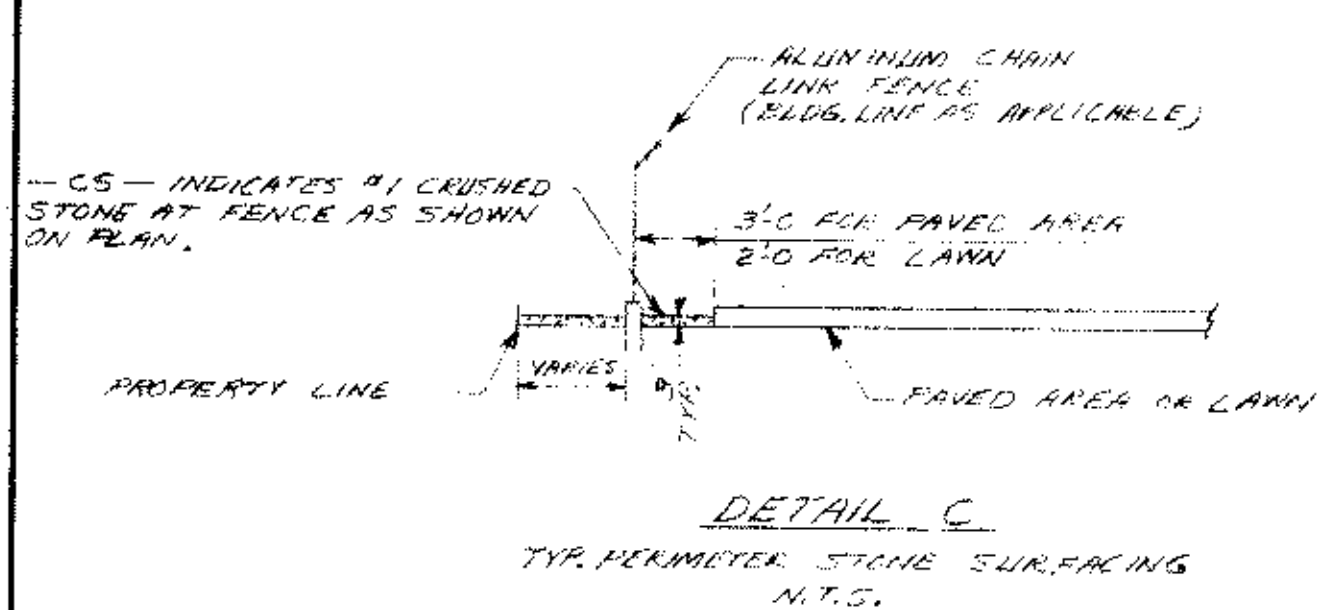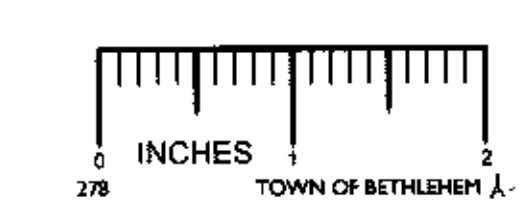

DES.	DR.	MTS.	TR.	CK.	DATE	SCALE AS SHOWN
APP.				APP.		INDEX 20.3-41.1
APP.				APP.		No. C-15541-E

REC'D JUNE 1970 FRO. MKA.