

NEW OFFICE BUILDING FOR INDEPENDENT MUTUAL INSURANCE AGENTS ROUTE 9W BETHLEHEM, NEW YORK

LIST OF DRAWINGS

GENERAL CONSTRUCTION

- C-1 SITE PLAN
- C-2 BASEMENT PLAN
- C-3 FIRST FLOOR PLAN
- C-4 SECOND FLOOR PLAN
- C-5 ELEVATIONS, WINDOW & FASCIA DETAILS
- C-6 SECTIONS & MISCELLANEOUS DETAILS
- C-7 WALL SECTIONS
- C-8 STAIR & TOILET DETAILS
- C-9 ROOF PLAN & EXTERIOR DETAILS
- C-10 ROOM FINISH & DOOR SCHEDULE
- S-1 FOUND. & FIRST FLOOR FRAMING & DETAILS
- S-2 SECOND FLOOR & ROOF FRAMING & COLUMN SCHEDULE

PLUMBING

- C-1 SITE PLAN
- SD-1 SEWAGE DISPOSAL
- P-1 BASEMENT PLUMBING PLAN
- P-2 FIRST FLOOR PLUMBING PLAN
- P-3 SECOND FLOOR PLUMBING PLAN
- C-2 BASEMENT PLAN
- C-3 FIRST FLOOR PLAN
- C-4 SECOND FLOOR PLAN
- C-6 SECTIONS

HEATING & AIR CONDITIONING

- C-1 SITE PLAN
- H-1 BASEMENT PLAN
- H-2 FIRST FLOOR PLAN
- H-3 SECOND FLOOR PLAN
- H-4 ROOF PLAN & DETAILS
- C-2 BASEMENT PLAN
- C-3 FIRST FLOOR PLAN
- C-4 SECOND FLOOR PLAN
- C-6 SECTIONS


ELECTRIC

- C-1 SITE PLAN
- E-1 RISE DIAGRAM, SYMBOLS, ETC.
- E-2 BASEMENT PLAN
- E-3 FIRST FLOOR PLAN
- E-4 SECOND FLOOR PLAN
- E-5 BASEMENT PLAN LIGHTING
- E-6 FIRST FLOOR PLAN LIGHTING
- E-7 SECOND FLOOR PLAN LIGHTING
- E-8 SITE PLAN DETAILS
- C-2 BASEMENT PLAN
- C-3 FIRST FLOOR PLAN
- C-4 SECOND FLOOR PLAN
- C-6 SECTIONS

Note: Two Residences on NW Side Highway
are connected, for water and gas,
to exist mains on Frontage Road East.


May 1970 - 6" WATER MAIN INSTALLED
1' EAST OF EAST ELP - @ CROSSING OF
A.T. & T. - T/C CONC SLAB 6" BELOW EXISTING ELP
T/WATER MAIN 48" BELOW ELP

LOCATION MAP
SCALE: 1" = 1000'

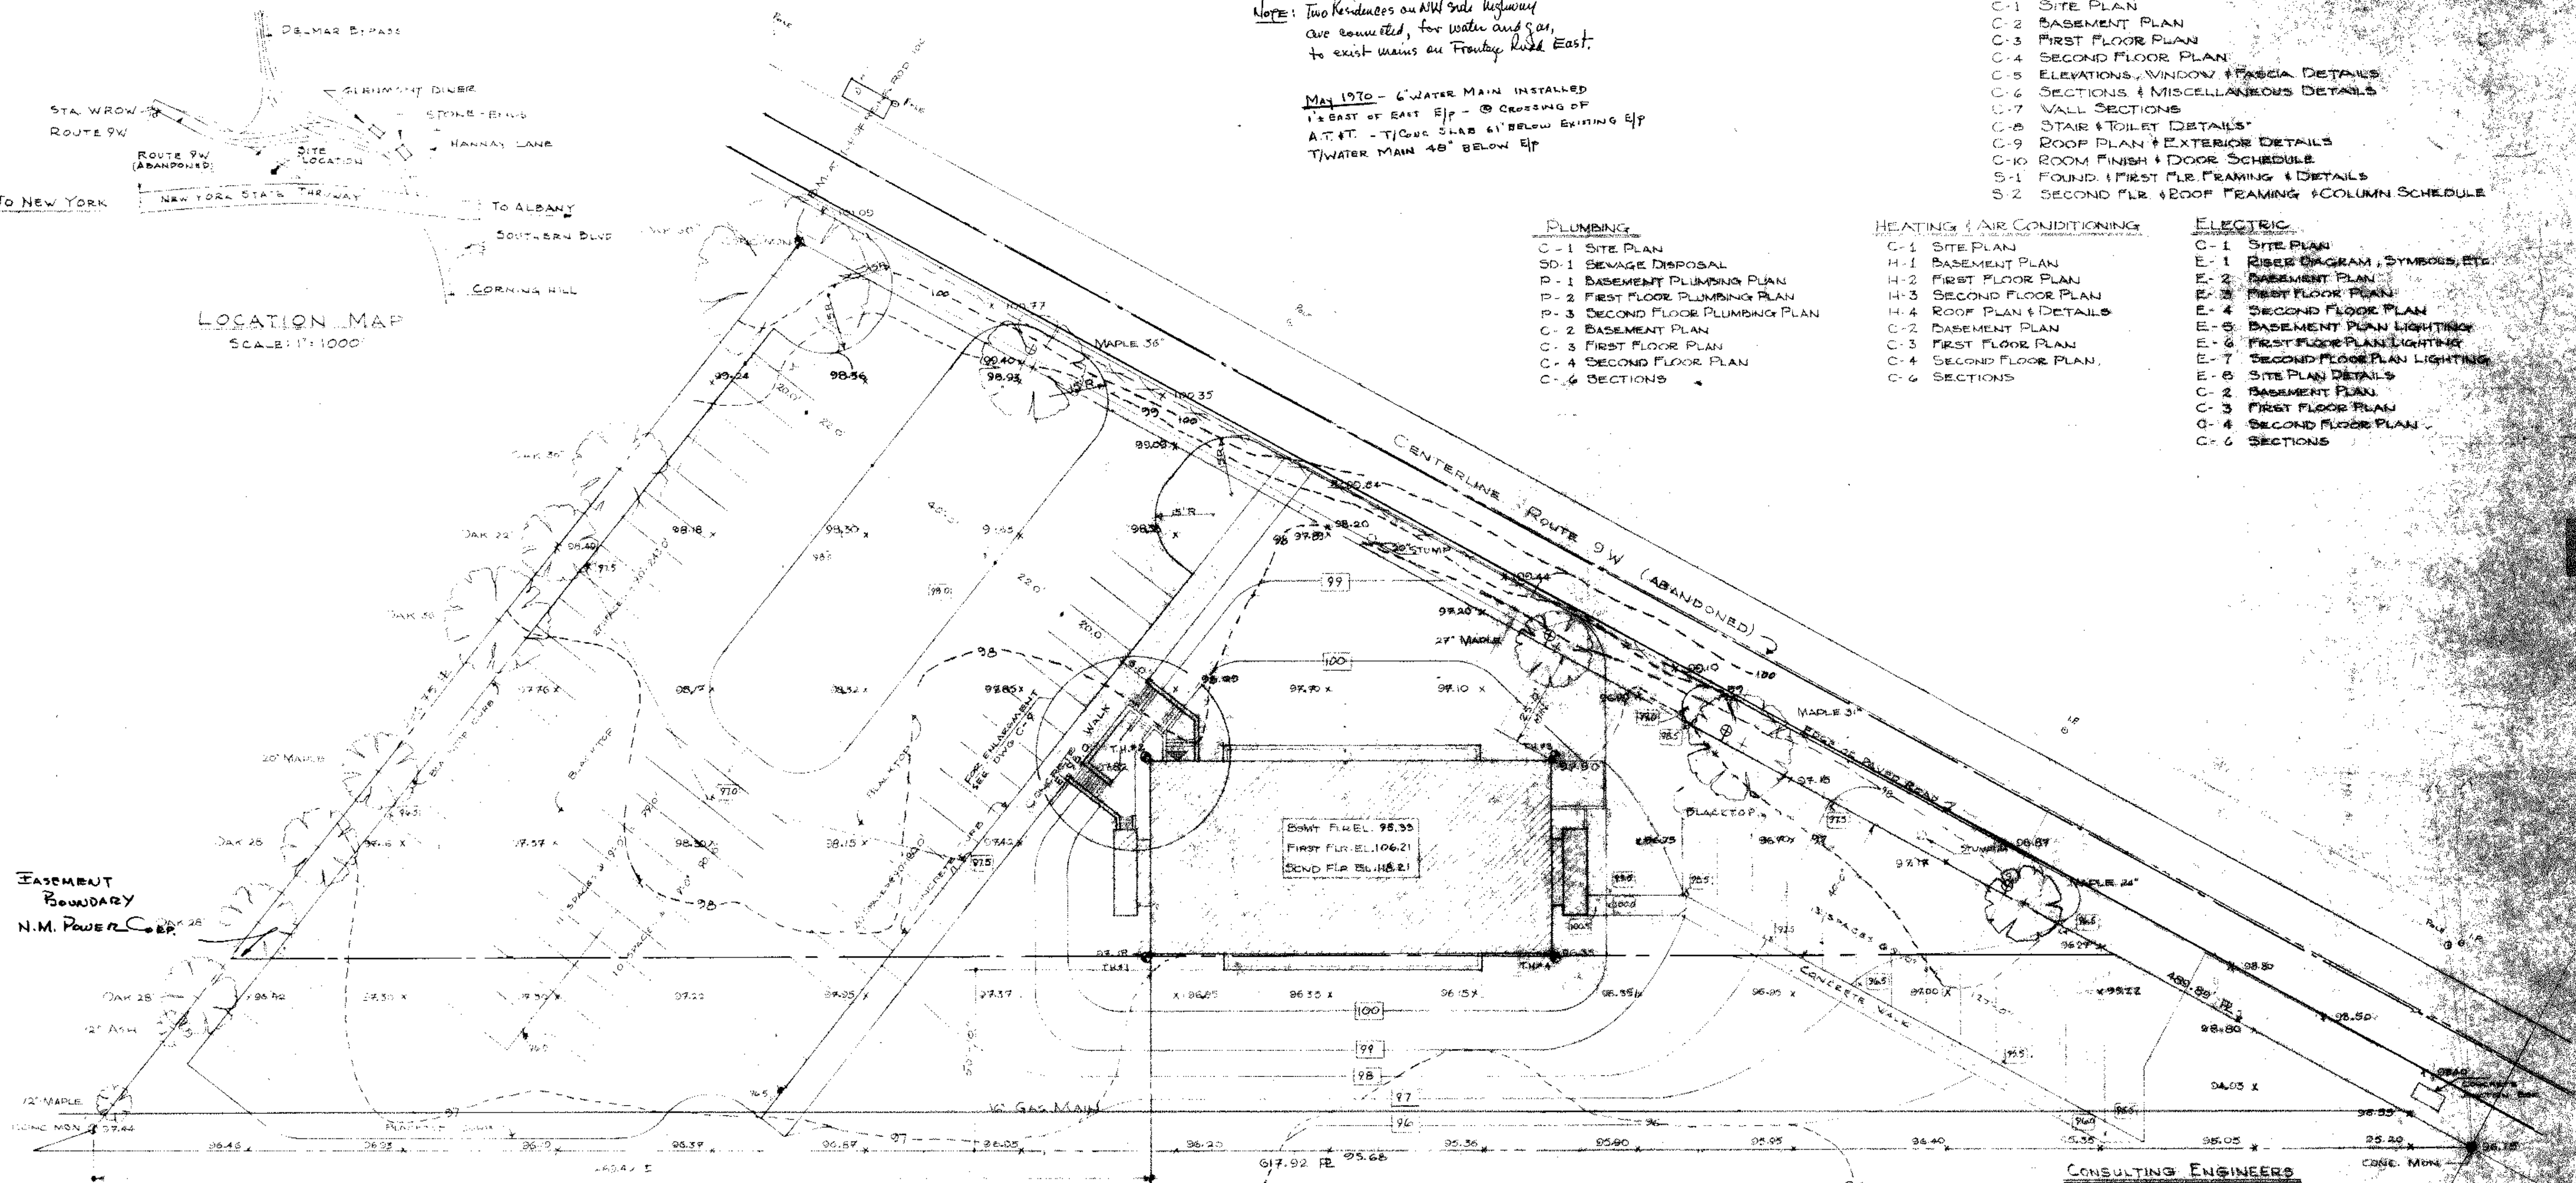

BASEMENT
Boundary
N.M. POWER CORP.

* 4 BAR - CONT.

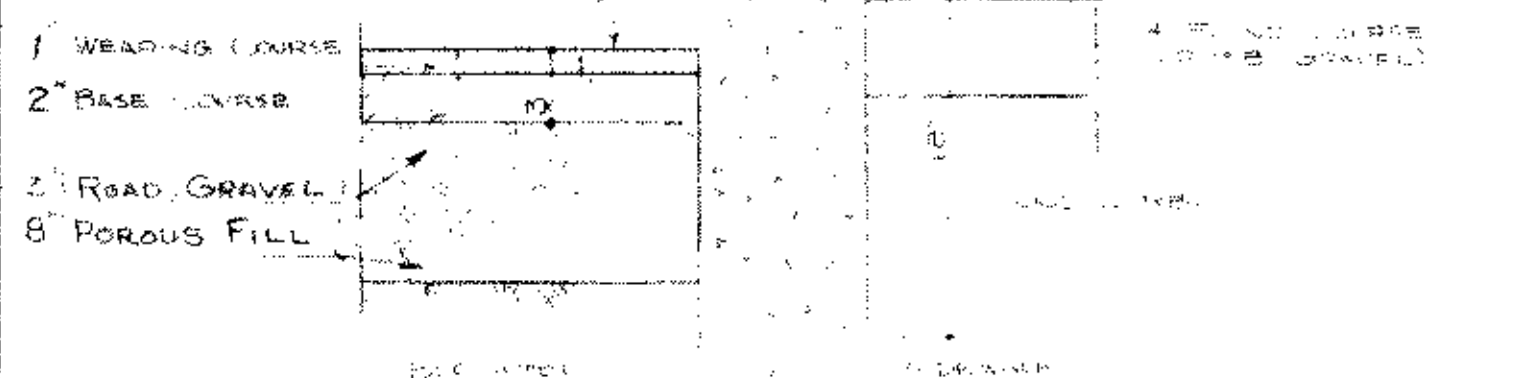

SITE PLAN
SCALE: 1" = 20' - 0"

ELEVATIONS SHOWN IN RECTANGLE ARE YEAR ELEVATIONS



0 INCHES
277 TOWN OF BETHLEHEM

CONSULTING ENGINEERS

HEATING, PLUMBING, AIR CONDITIONING - FREDERICK H. DUNN
ELECTRICAL - WALTER S. STEINMAN

INDEPENDENT MUTUAL INSURANCE AGENTS
ROUTE 9W

SITE PLAN

LUX AND QUACKENBUSH
ARCHITECTS
ALBANY, NEW YORK