



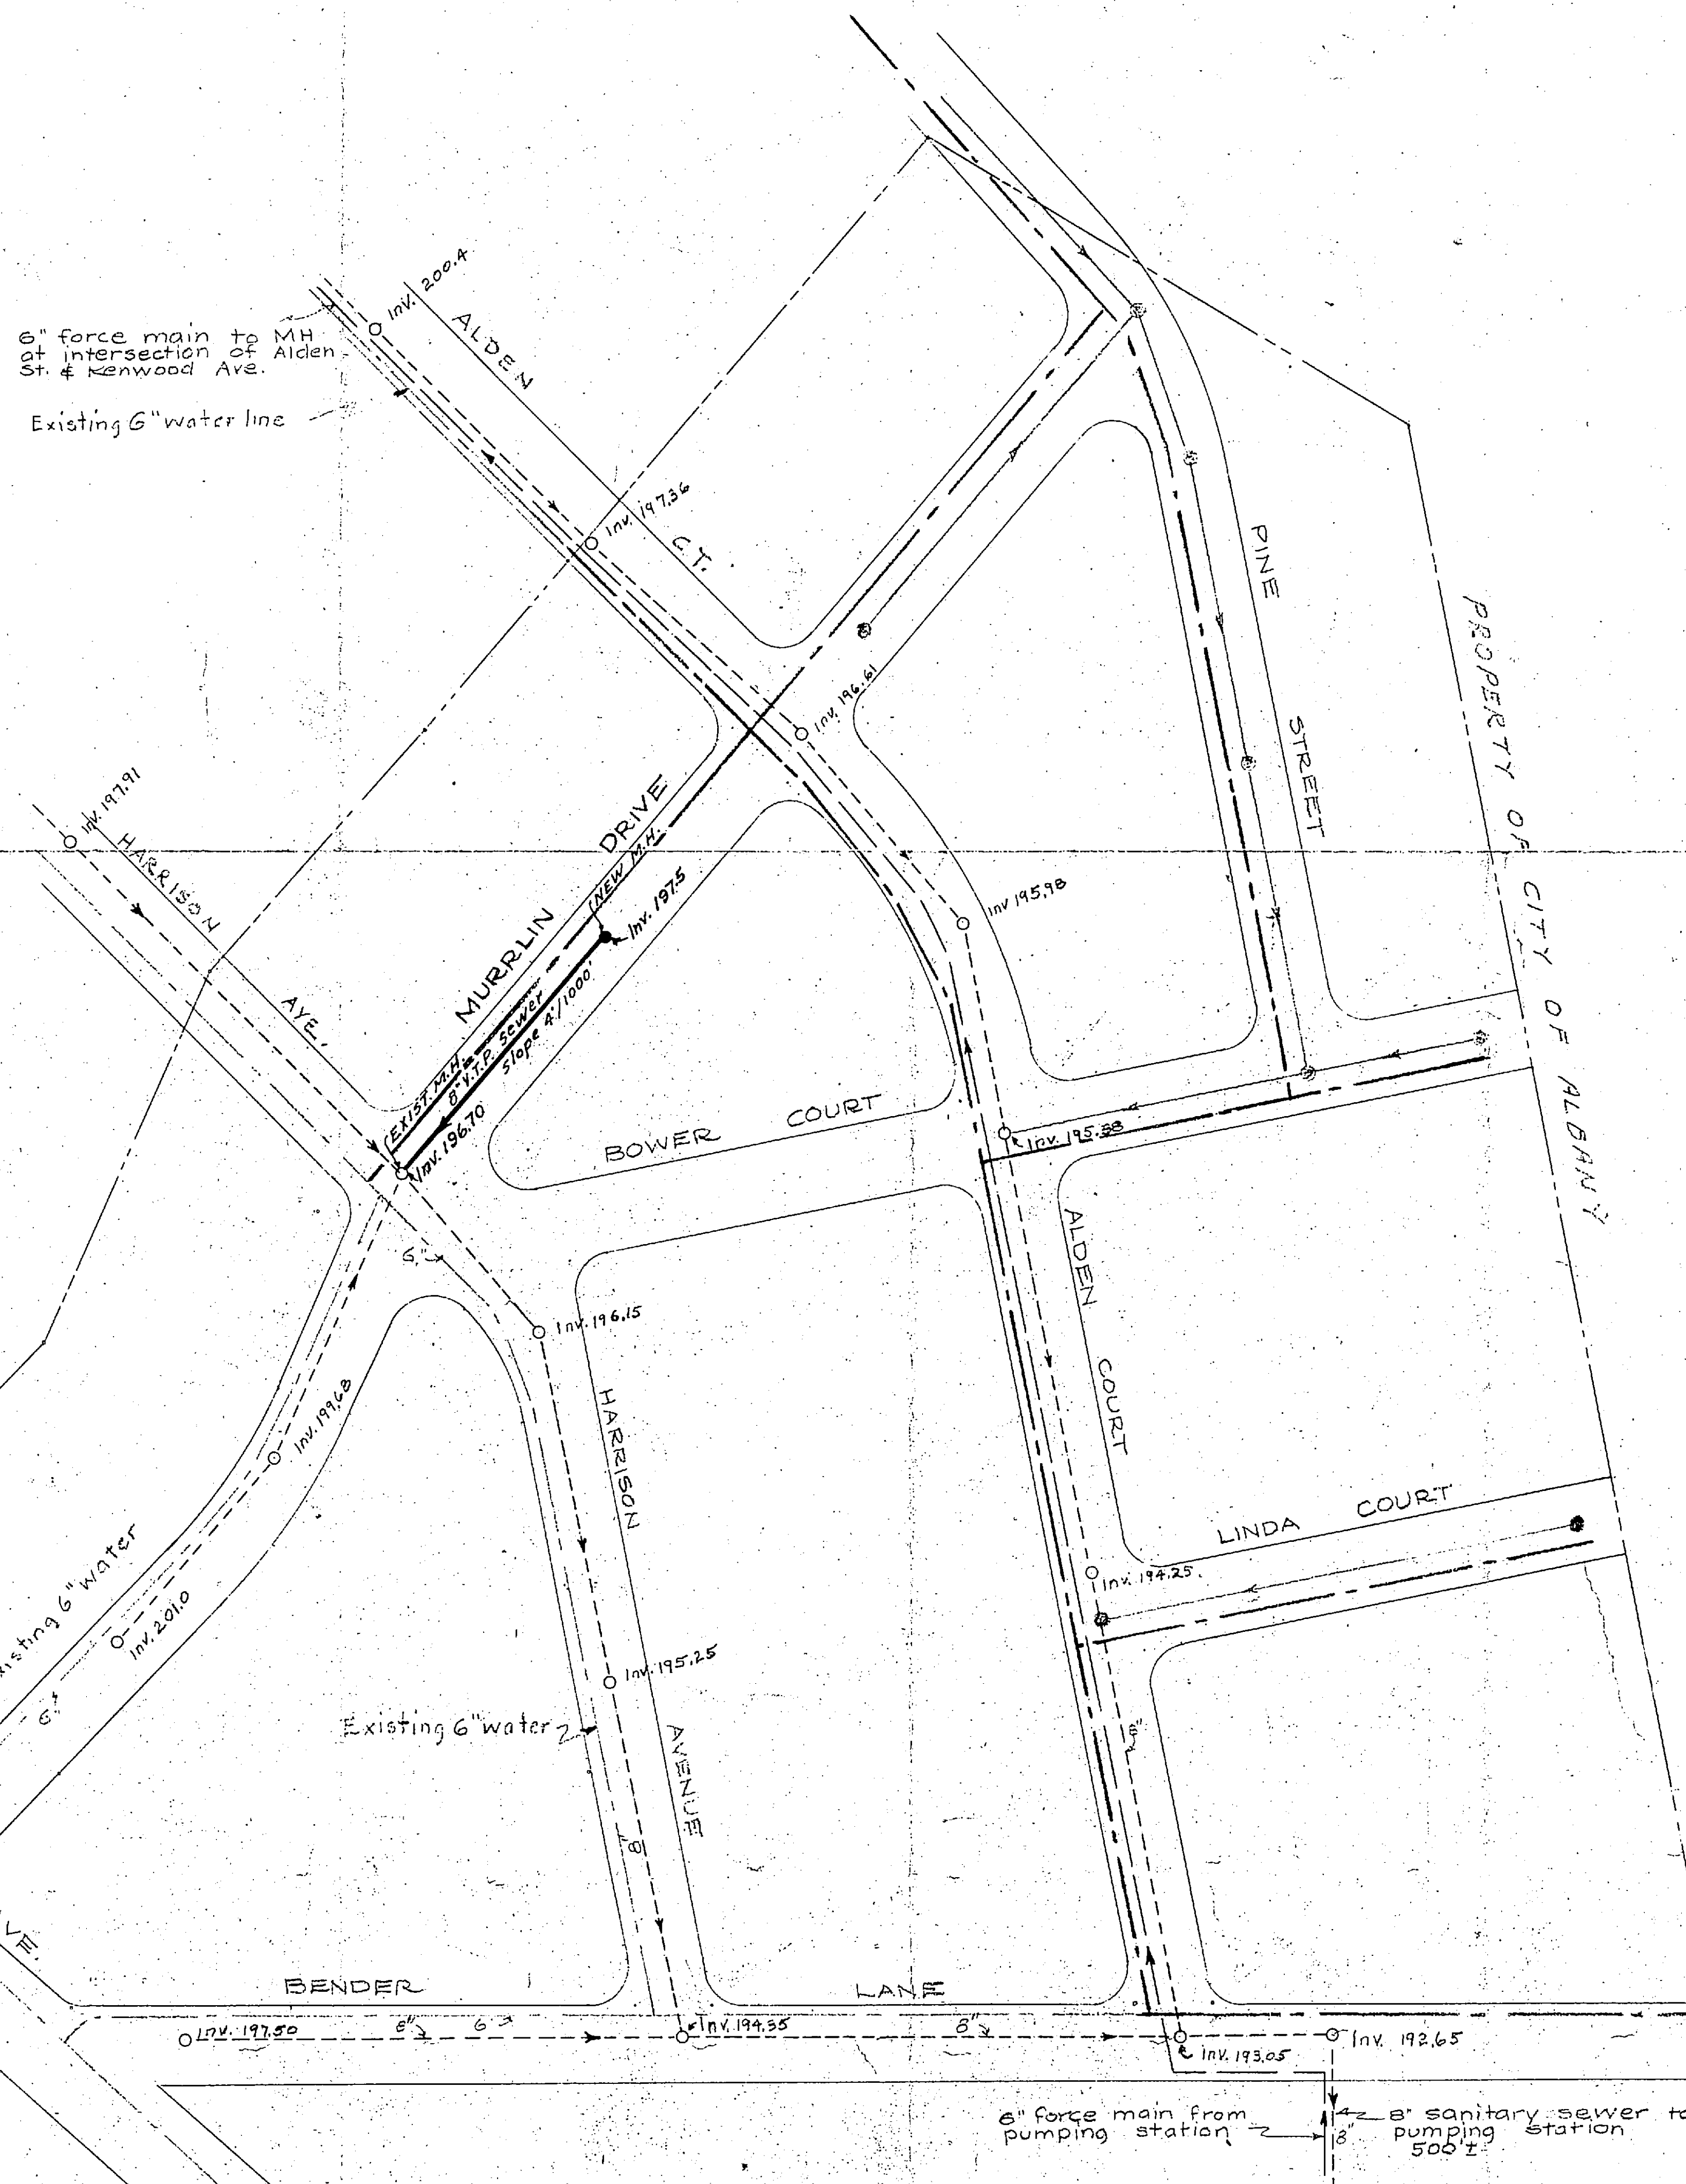

LEGEND

- Existing Sewer Line
- Proposed Sewer Line
- Existing Force Main
- Existing Water Line
- Proposed " "

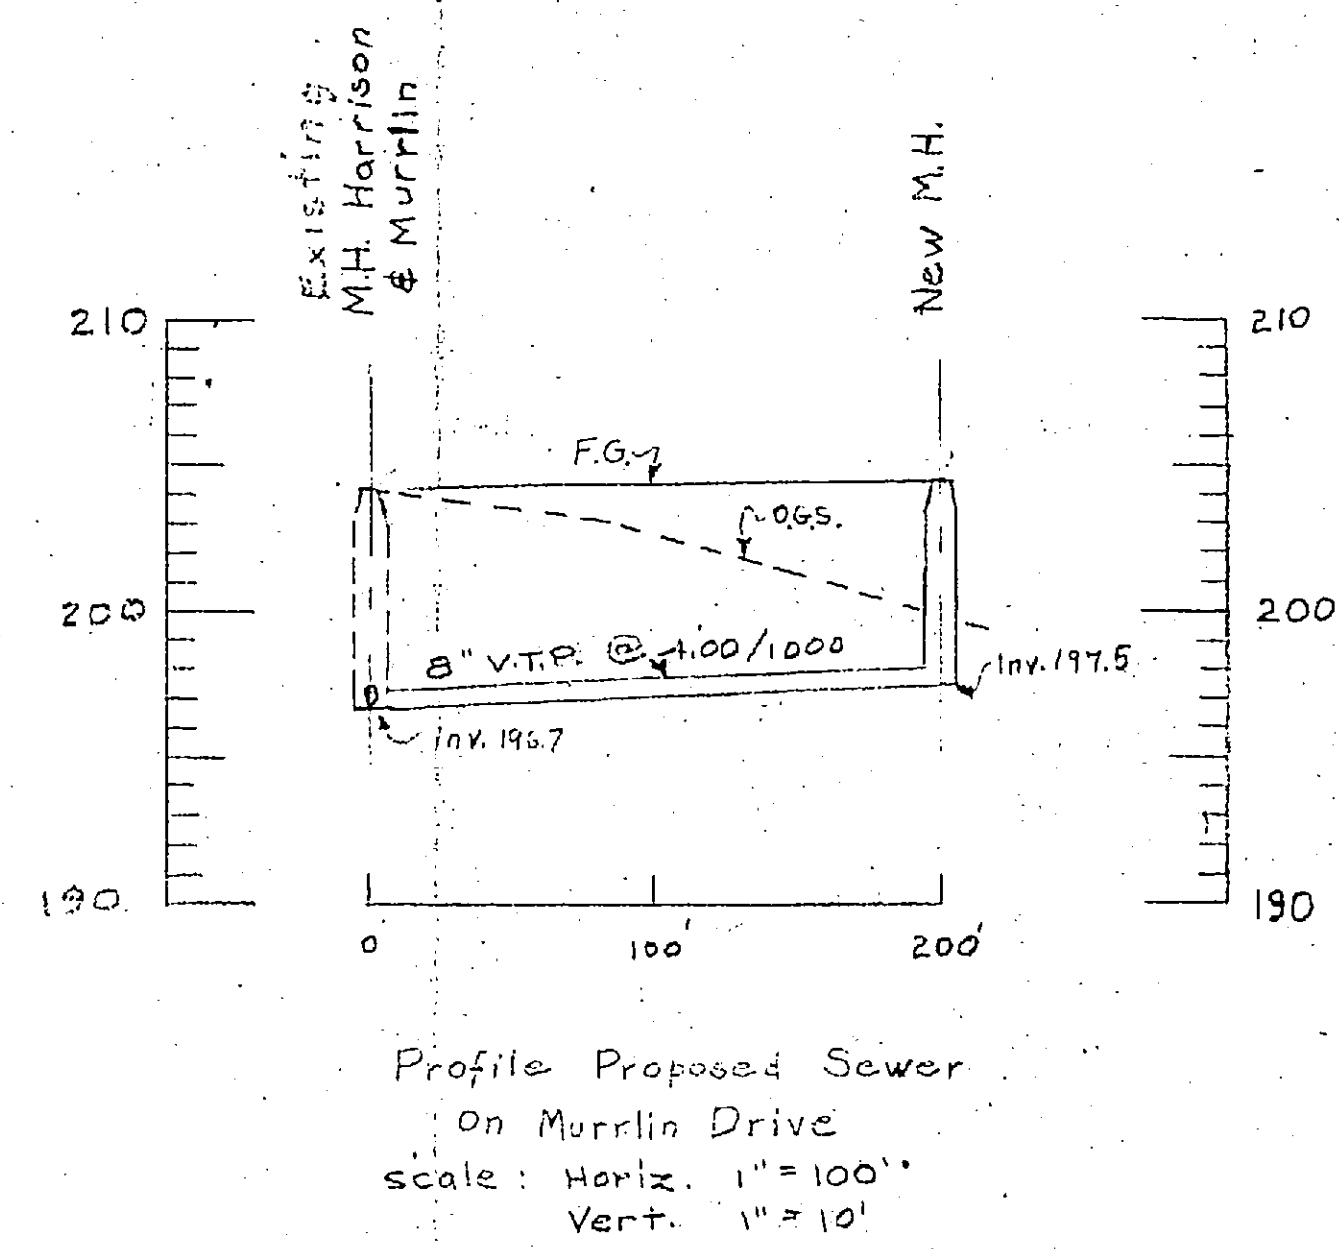

DELMAR ELSMERE SEWER DIST.
TOWN OF BETHLEHEM
ALBANY COUNTY, N.Y.
MAP SHOWING PROPOSED SEWER
ON MURRLIN DRIVE

SCALE: 1" = 100'
NOVEMBER, 1948

BARKER & WHEELER, ENGINEERS
36 STATE STREET, ALBANY, N.Y.
11 PARK PLACE, NEW YORK CITY.

NOTE:-

Plan and profile of sewer on Murrin
has been approved by the N.Y.S. Dept. of
Health on plans filed by others.

Drawn By E.W.D.-R.G.
CK'd. By J.K.F.