
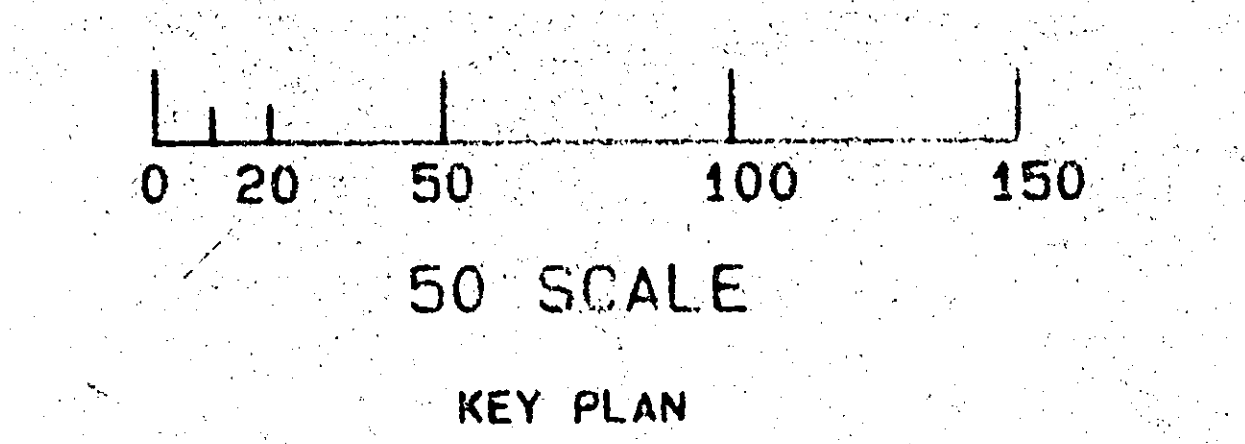


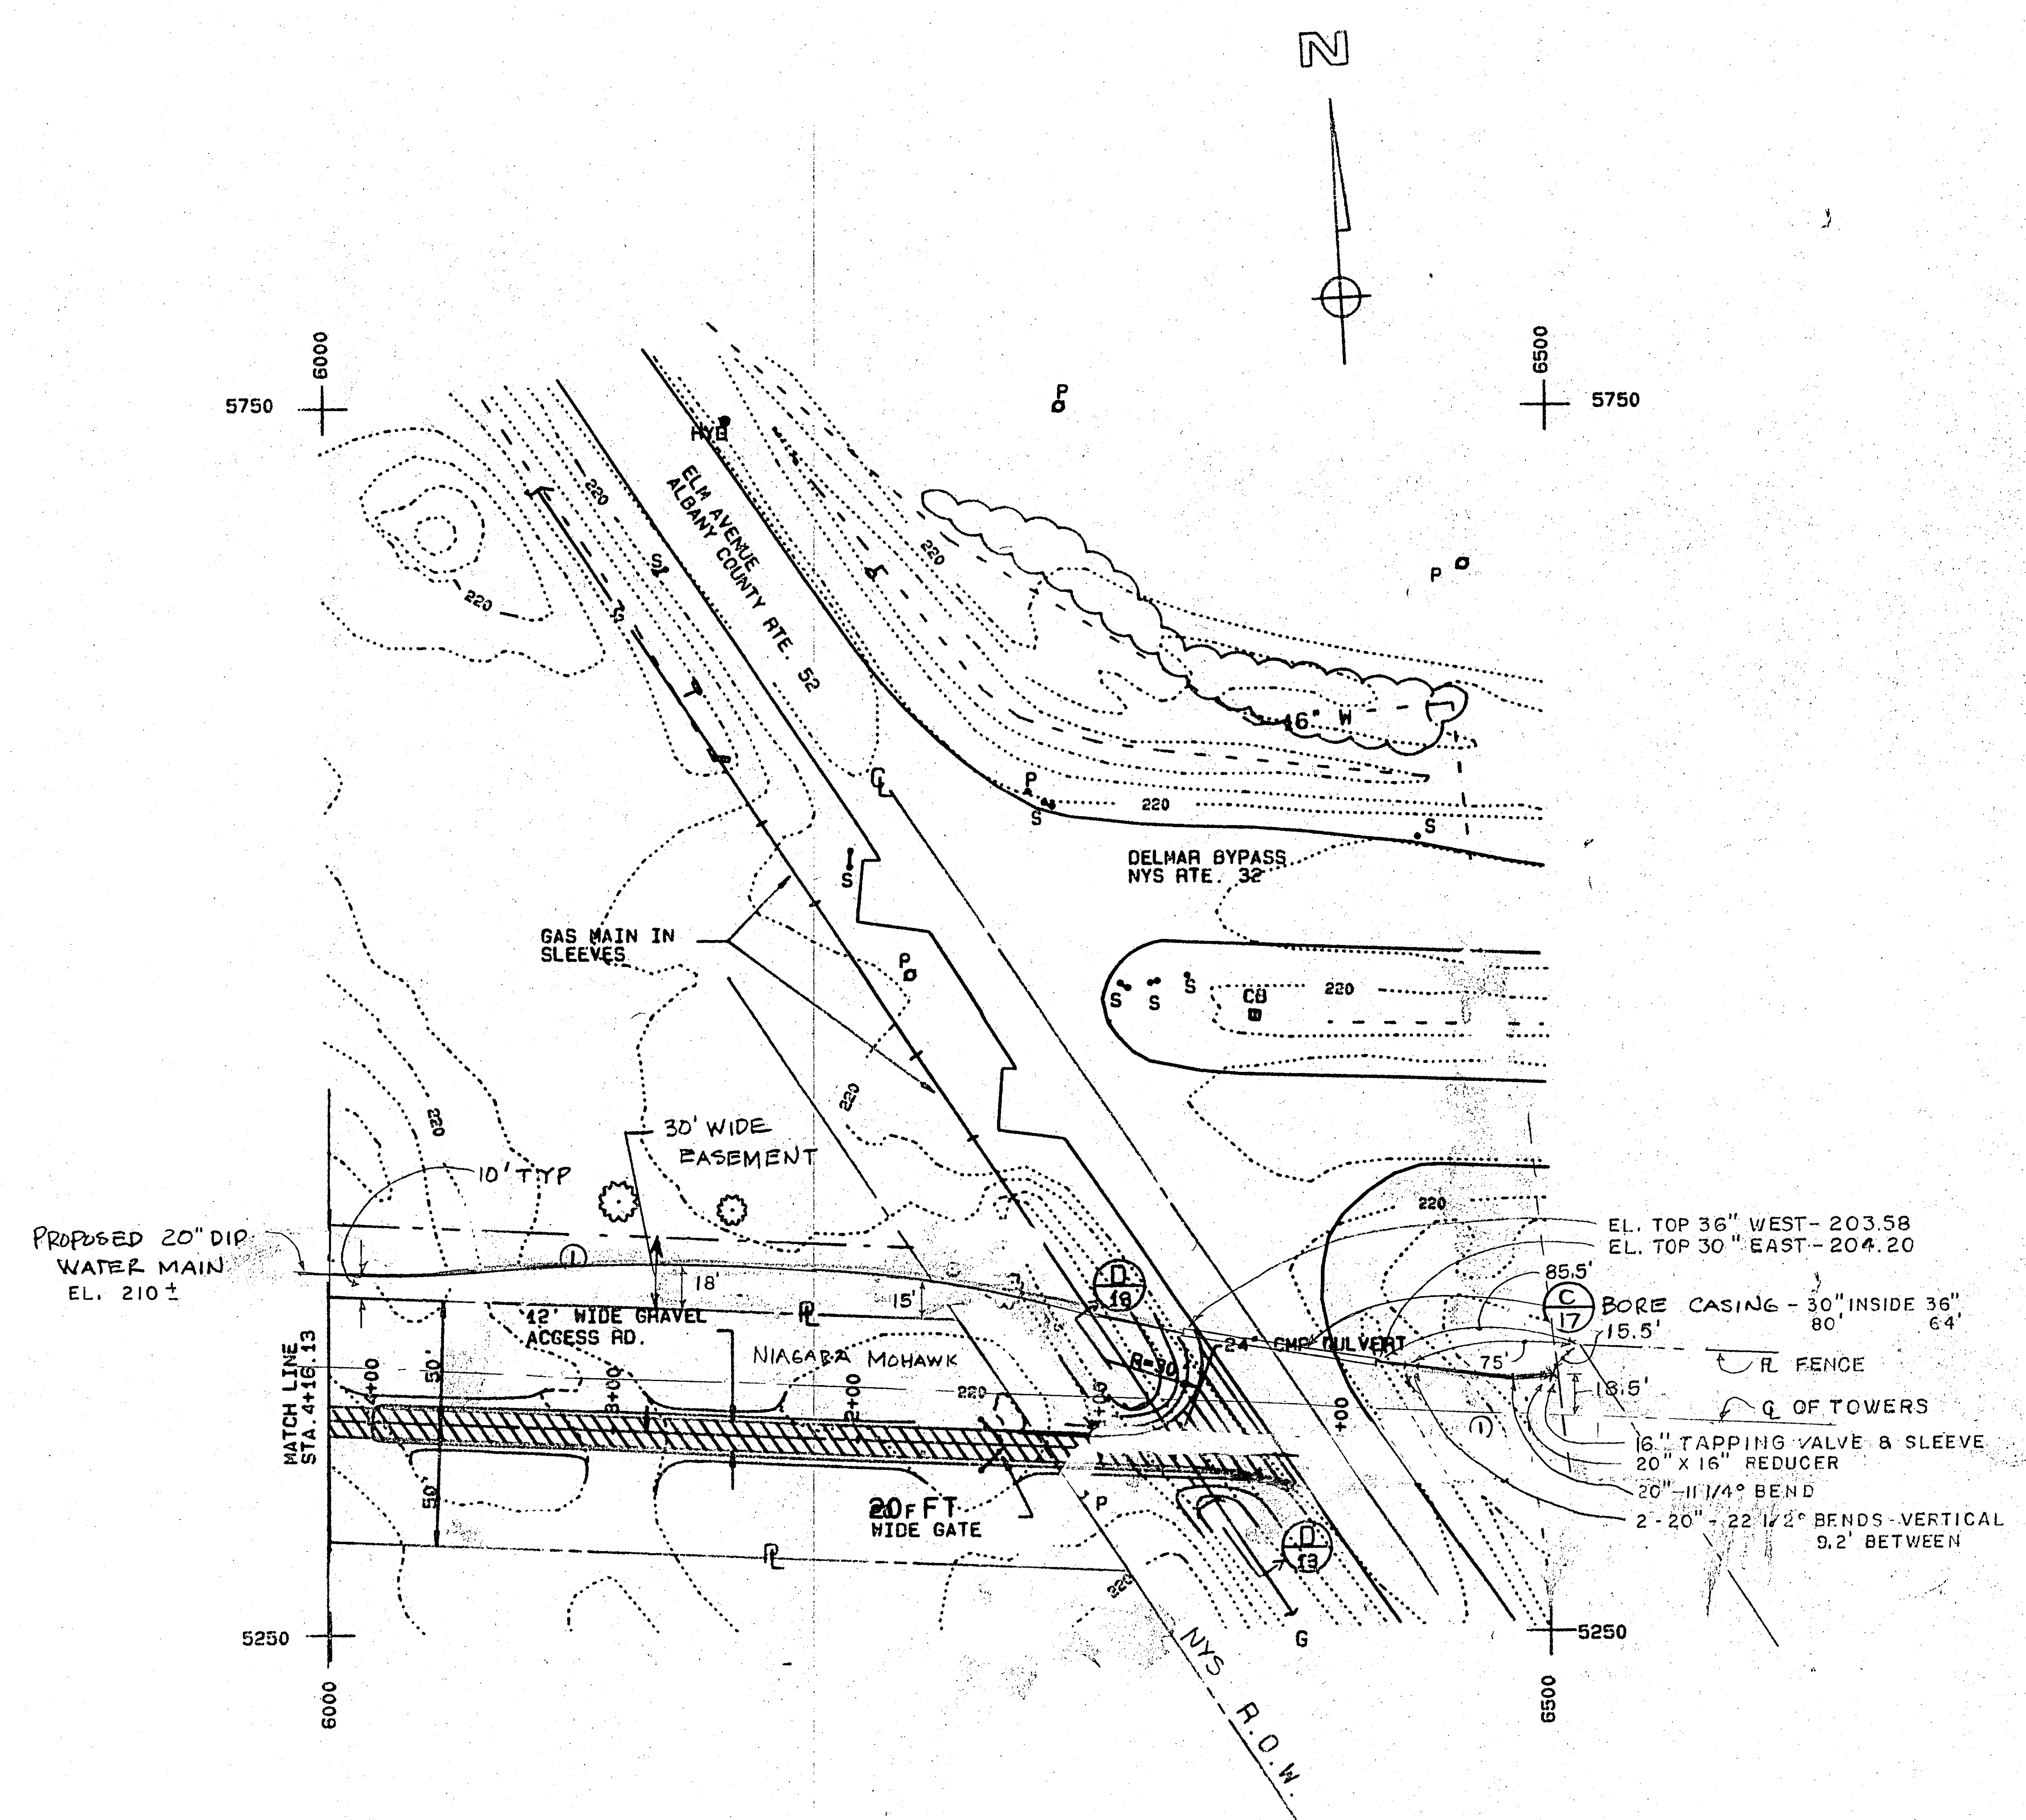

1. THESE RECORD PLANS HAVE BEEN PREPARED UTILIZING INFORMATION COMPILED BY THE ENGINEER AND OTHER SOURCES. INFORMATION SHOWN IS REPRESENTATIVE OF ACTUAL CONDITIONS BUT SHOULD BE VERIFIED PRIOR TO ITS USE FOR FUTURE DESIGNS OR BEFORE EXCAVATIONS AND/OR REPAIRS ARE MADE. THE ENGINEER WILL NOT BE RESPONSIBLE FOR THE ERRORS OR OMISSIONS OF OTHERS OR FOR DAMAGES WHICH MAY RESULT FROM THE UNVERIFIED USE OF THIS RECORD INFORMATION.

UNAUTHORIZED ALTERATIONS OR ADDITIONS TO THIS DOCUMENT IS A VIOLATION OF SECTION 205 AND ARTICLE 2 OF THE NEW YORK STATE EDUCATION LAW.

REVISIONS			
DATE	BY	DESCRIPTION	SYMBOL
12/18/84	DCC	MOVED WATER MAIN	①

J. KENNETH FRASER
AND ASSOCIATES, P.C.
CONSULTING ENGINEERS
RENSSELAER, NEW YORK

WATER STORAGE
IMPROVEMENT PROJECT

TOWN OF BETHLEHEM
ALBANY COUNTY, NEW YORK

CONTRACT NO. 1
SITE WORK


CONTRACT NO. 2
STEEL WATER STORAGE RESERVOIR

PROJ. ENG'R: DCC
DRAWN BY: BDB
ASSEMBLED BY: BDB
CHECKED BY: JKF

REF. NO. 5630R

SHEET TITLE:
DISTRIBUTION RESERVOIR
SITE PLAN

DATE: SEPT. 1984 SHEET 11 OF 17

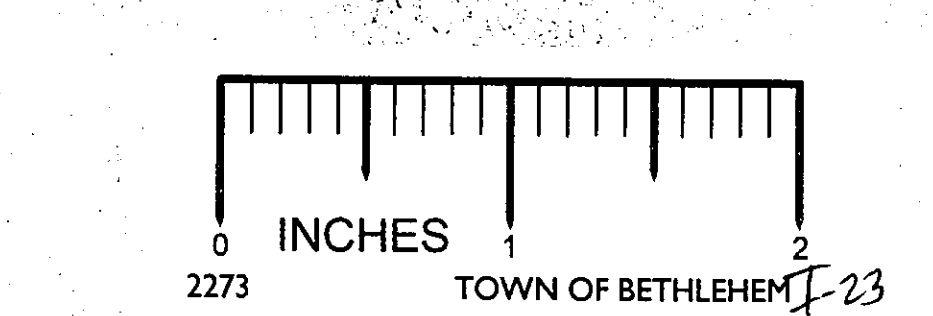

RECORD PLAN