

PLANT LIST

SYMBOL	BOTANIC NAME	COMMON NAME	SIZE	QUAN.	REMARKS
+	GLADITSIA TRICANTHOS HERMIS	THORNLESS HONEYLOCUST	8'-10' HT.	6	B+5
+	PHUS NIGRA	AUSTRIAN PINE	2'-3' HT.	13	B-13
○	JUNIPERUS CHINENSIS FITZGERALDI	REITER JUNIPER	2'-3' HT.	3	F+13

NOTES

1. STRIP & STOCKPILE TOPSOIL FOR ALL AREAS OF CONSTRUCTION. SPREAD TOPSOIL ON ALL DISTURBED GROUND. FINE GRADE, REMOVE FOREIGN OBJECTS (STICKS, STONES, DEBRIS) FERTILIZE, LIME & SEED. & MULCH.
FERTILIZER: 10-10-10 @ 50 LBS PER ACRE (15 LBS/1000 SQ FT).
LIME: APPLY AS REQ. TO BRING SOIL TO BETWEEN 5.5 PH AND 6.5 PH.
SEED: 1/2 TALL FESCUE (70%) PERENNIAL RYE (30%) - 3 LBS PER 1000 SQ FT.
MULCH: STRAW - 5 TONS PER ACRE - ALL LAWN AREAS.
GRASS: BIODEGRADABLE ON ALL SLOPES 5:1 & STEEPER.
JUTE MESH: IN ALL SWALES, ON FLOORS & MIN. 1' UP SIDE SLOPES.
2. PLACE ALL NATIVE FILL IN 12" LOOSE LIFTS AND COMPACT EACH UNDER PAVEMENT TO 95% MODIFIED PROCTOR DENSITY.
3. AT THE CONCLUSION OF CONSTRUCTION, COMPLETELY CLEAN AND RESTORE ALL AREAS OF CONSTRUCTION ACTIVITY.
4. REMOVE ALL SILT, DEBRIS, ETC. FROM ALL STORM DRAINAGE FACILITIES AT THE CONCLUSION OF CONSTRUCTION.
5. BOUNDARY & TOPOGRAPHIC INFORMATION OBTAINED FROM A DRAWING BY EDWARD W. BOUTELLE & SON AT 1"=30' SCALE, DATED FEBRUARY 1985, ENTITLED "P. DRESCHER CO., INC."

6. APPROXIMATE LOCATION OF WELL SHOWN ON THIS DRAWING IS BASED ON INFORMATION PROVIDED BY HALL & COMPANY, INC.
7. STATE SANITARY DEPARTMENT SYSTEM HAS BEEN DESIGNED BY EDWARD W. BOUTELLE & SON.

SCHEDULE OF DRAWINGS


1. SITE PLAN
2. FOUNDATION PLAN
3. ANCHOR BOLT PLAN
4. FOUNDATION DETAILS & FRAMING PLAN
5. FLOOR PLANS
6. ENLARGED FLOOR PLANS
7. ROOM FINISH SCHEDULE
8. WALL SECTIONS & DETAILS
9. BUILDING ELEVATIONS & SECTIONS
10. H.V.A.C. & PLUMBING PLAN
11. ELECTRICAL PLAN (OFFICE)
- 12.

ENERGY NOTES:

1. FOUNDATION INSULATION TO BE 1" THICK STYROFOAM SM R-5.5
2. WAREHOUSE
ACTUAL WALLS: 4" P.E.B. INSULATION WITH FOIL BARRIER R-17
ACTUAL ROOF: 6" P.E.B. INSULATION WITH FOIL BARRIER R-25
3. OFFICE
ACTUAL WALLS: 1 1/2" THICK STYROFOAM 88' GYP. BR. R-8.15
ACTUAL ROOF: 6" P.E.B. INSULATION WITH FOIL BARRIER R-25

STRUCTURAL NOTES


1. MEZZANINE: 200 PSF TOTAL LOAD
2. ROOF:
50 PSF LIVE LOAD
15 PSF DEAD LOAD
65 PSF TOTAL LOAD
3. WIND LOAD: 20 PSF

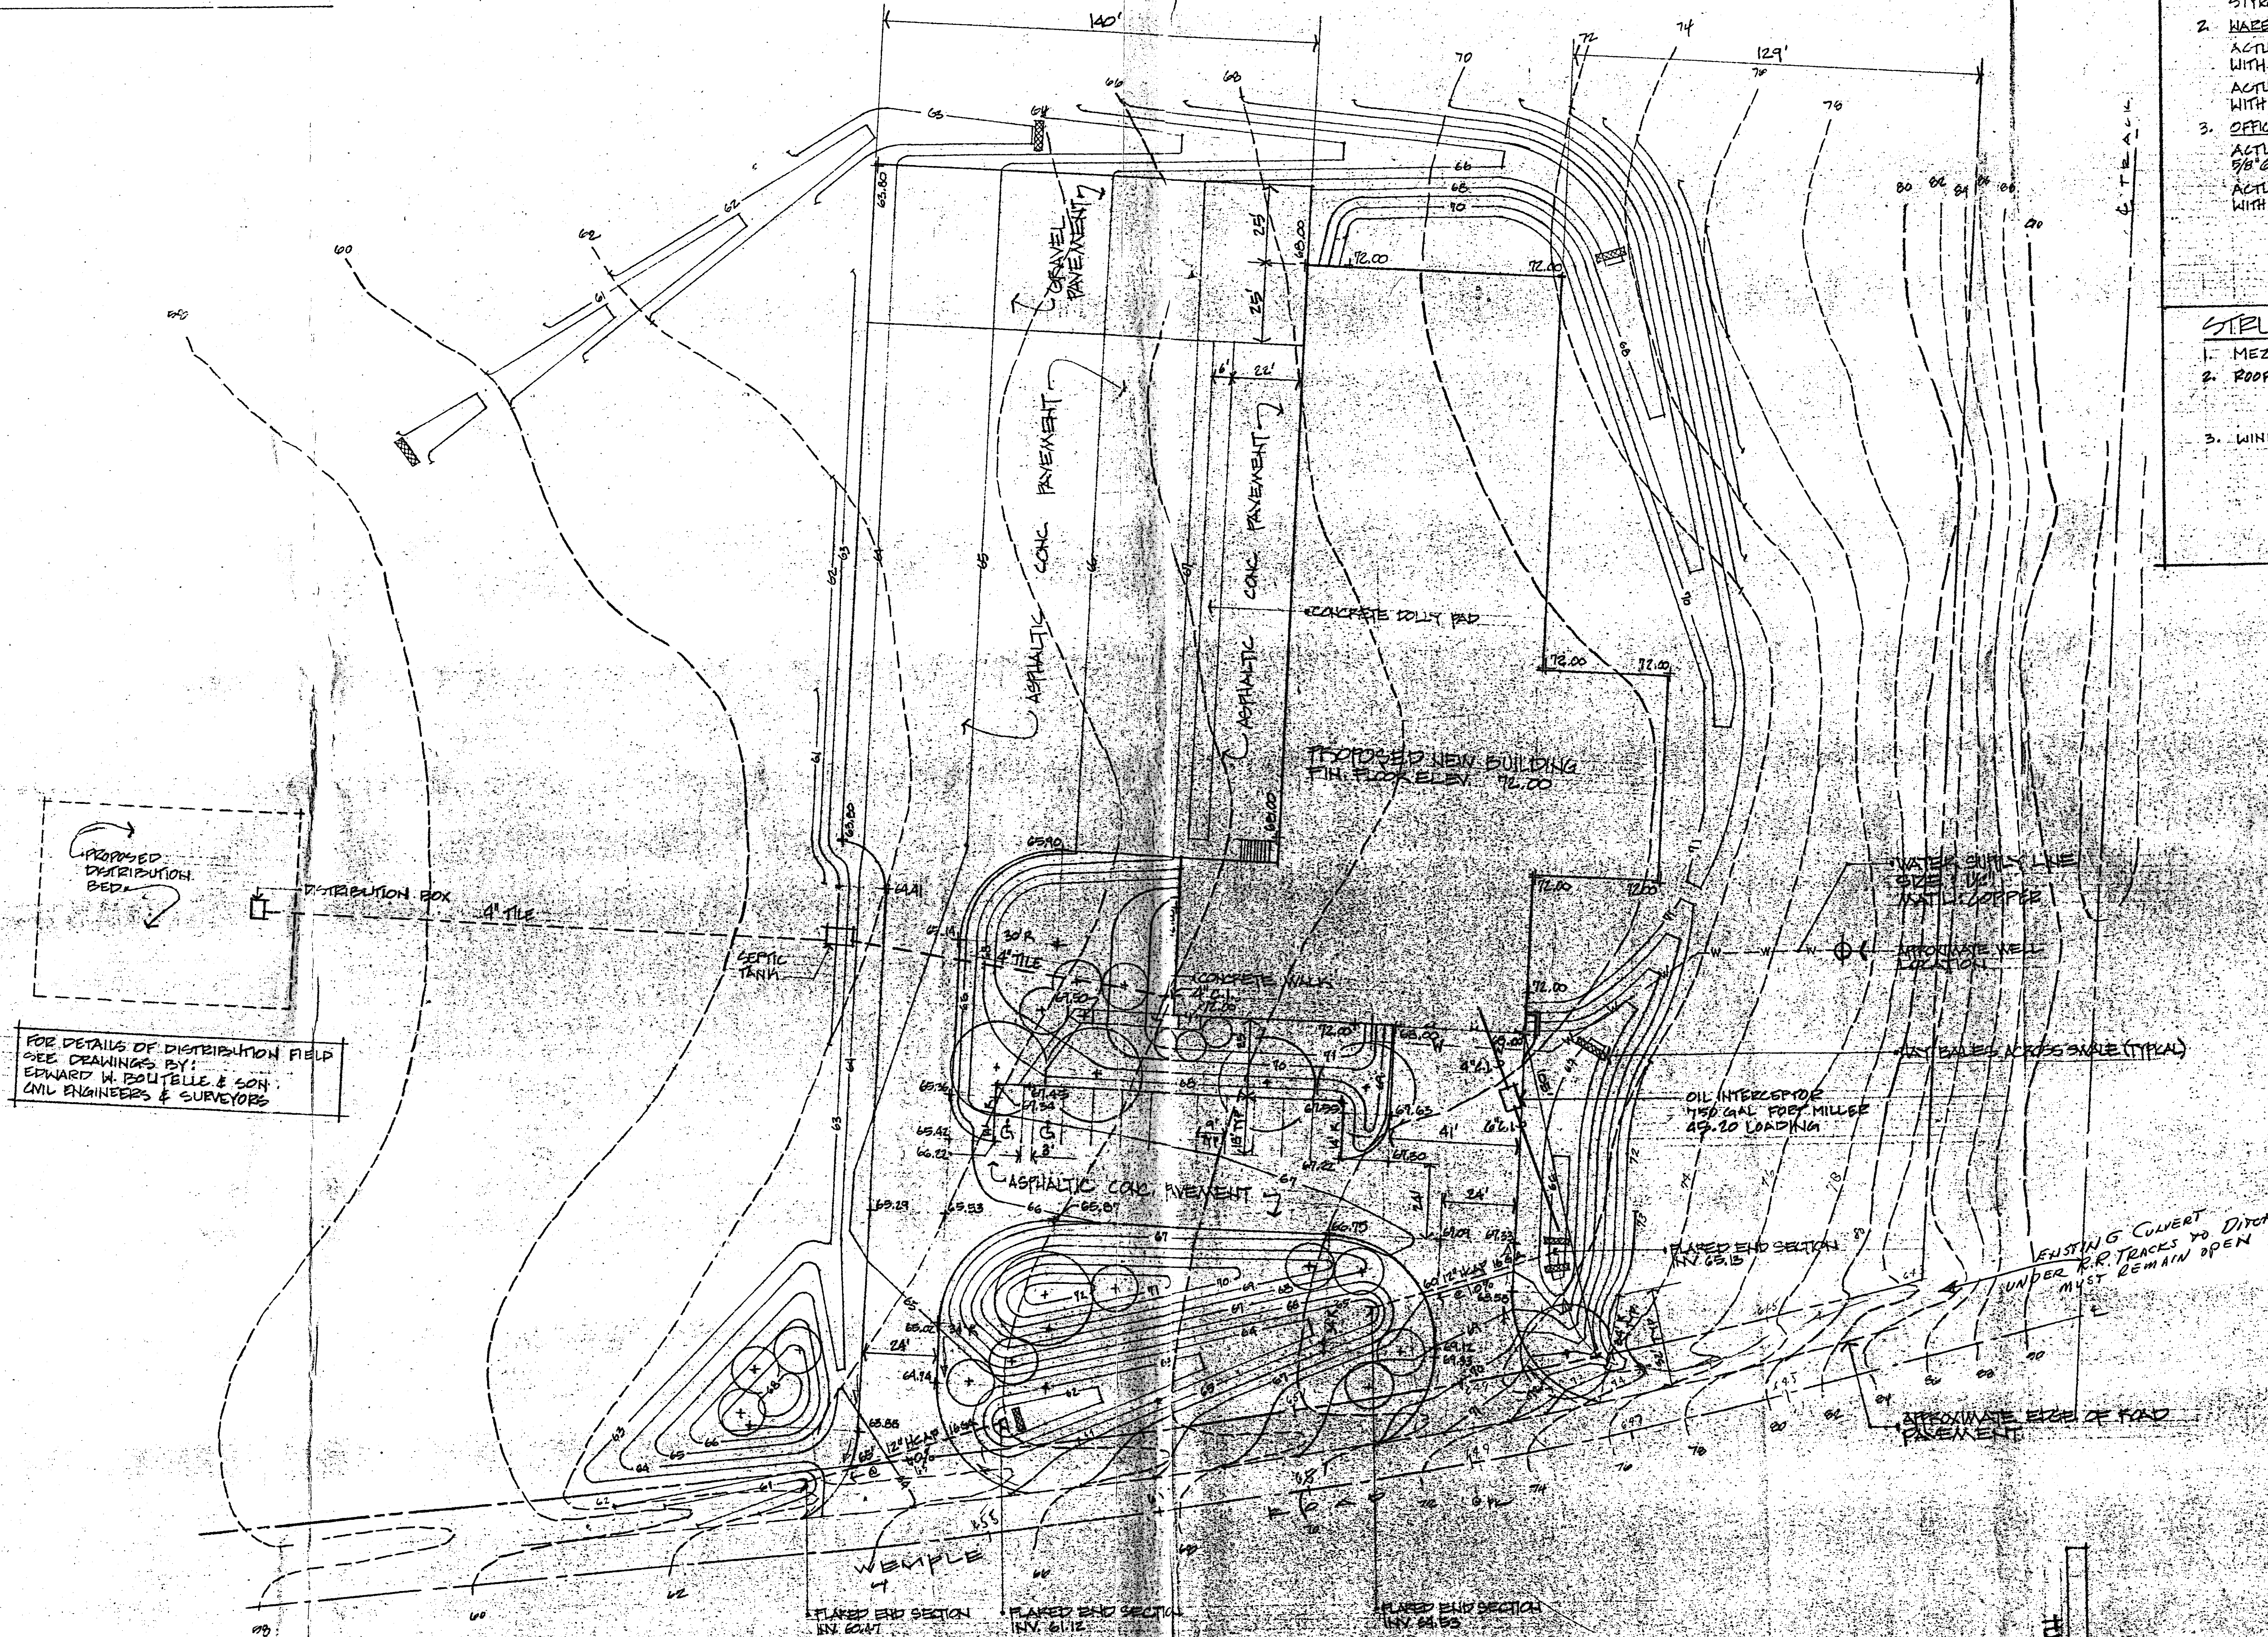

FOR DETAILS OF DISTRIBUTION FIELD SEE DRAWINGS BY: EDWARD W. BOUTELLE & SON, CIVIL ENGINEERS & SURVEYORS

SITE PLAN

EASTERN INGREDIENTS
645 WEMPLE ROAD
GLENMONT, NEW YORK

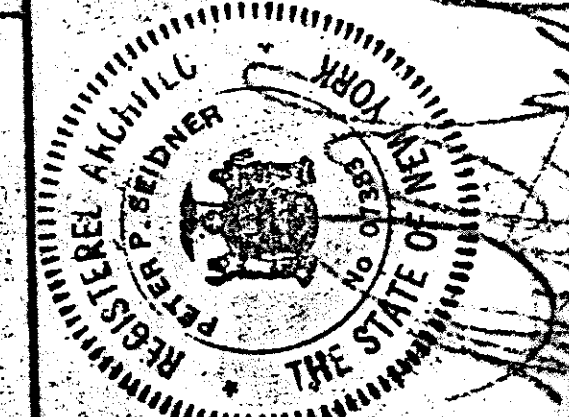

Barry, Bette, & Led Duke, Inc.

DRAWING NO.

1



TOWN OF BETHLEHEM

J-22