


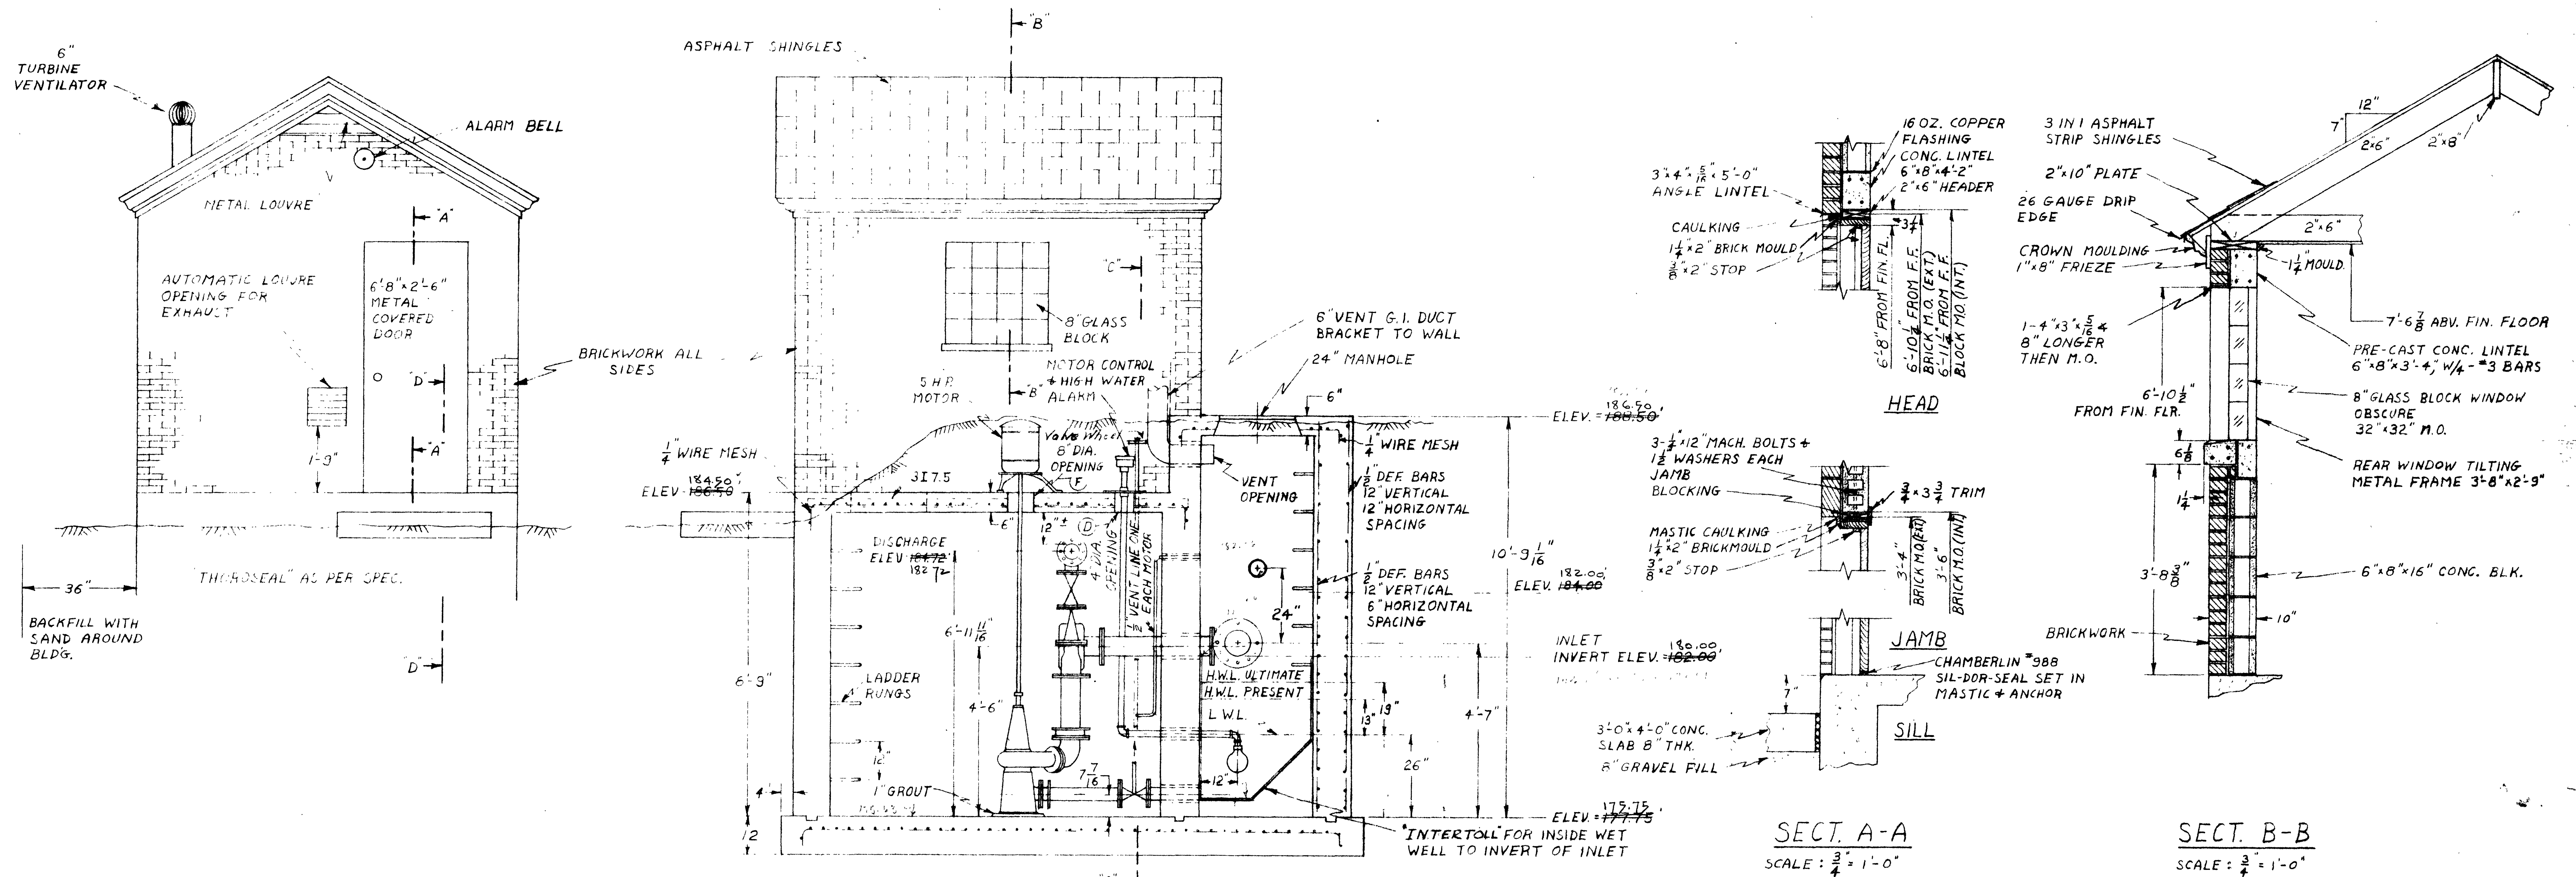

FOUNDATION AND PUMP FLOOR PLAN

MOTOR FLOOR PLAN

SEWAGE PUMPING STATION DETAILS
"KENHOLM SUBDIVISION"
DELMAR-ELSMERE SEWER DISTRICT
TOWN OF BETHLEHEM ALBANY CO. N.Y.
SCALE AS SHOWN OCT. 15, 1959