


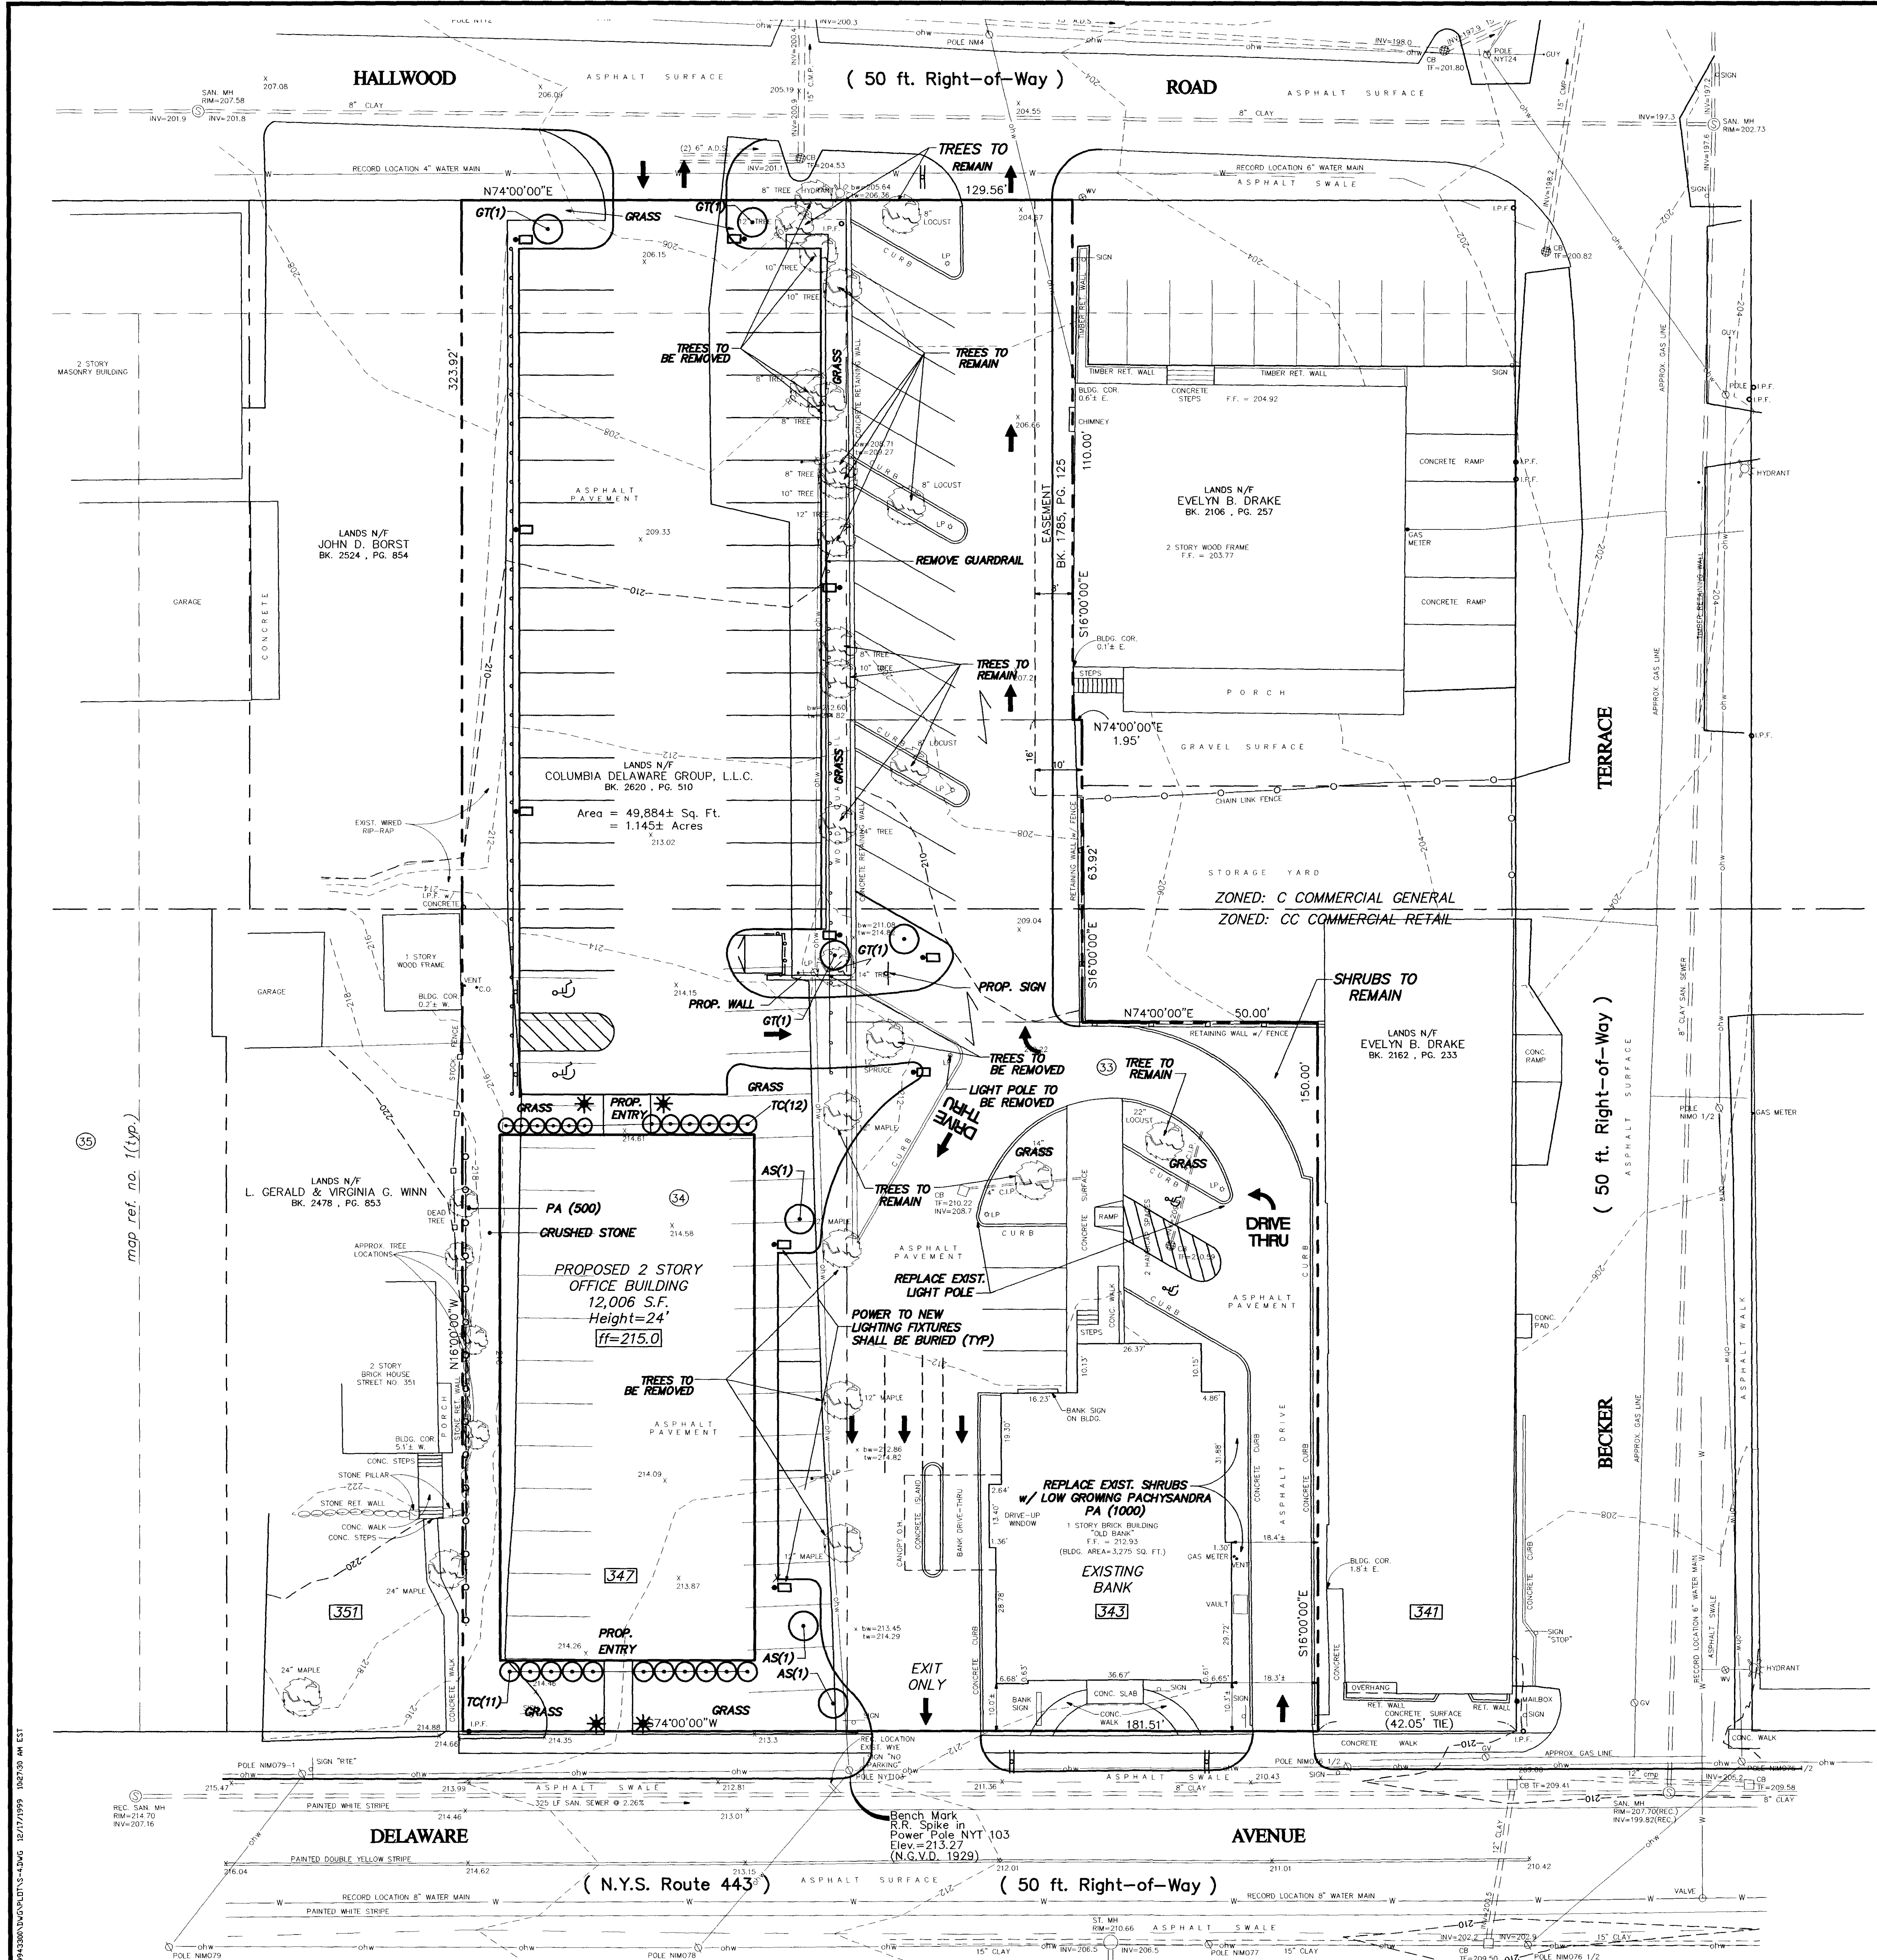

LANDSCAPE TABLE


SYM.	QUAN.	BOTANICAL NAME	COMMON NAME	SIZE	ROOT	ROOT	COMMENTS
GT	4	GLEDITSIA TRIACANTHUS	HONEY LOCUST	2 1/2" CAL.	B + B	AS SHOWN	ALL SIZES ARE
AS	3	ACER SACCHARUM	SUGAR MAPLE	2 1/2" CAL.	B + B	AS SHOWN	MINIMUM SIZE AT
TQ	23	TAXUS CUSPIDATA	YEW	2' HT.	B + B	AS SHOWN	TIME OF
PA	1500	PACHYSANDRA TERMINALIS	PACHYSANDRA	2 YRS.	2-1/2" POTS		PLANTING

NOTES: 1. EXISTING LANDSCAPING TO REMAIN UNLESS NOTED OTHERWISE AND MAINTAINED BY EVERGREEN BANK.
2. TREES TO REMAIN MUST BE MARKED BY L.A.

LIGHTING TABLE

SYM.	QUANTITY	COMPANY **	WATTS	TYPE	HT.	BASE
BxT	10	GENERAL ELECTRIC	150 W HPS	SINGLE HEAD SHOE BOX	20' MT HT	24" DIA. CONC. BASE 4" DEPTH MIN.
PRSM	4	HOLOPHANE	100 W HPS	DECORATIVE	10' POLE	18" DIA. CONC. BASE 4" DEPTH MIN.

NOTES: 1. * DESIGN INTENSITY (AVERAGE) 2-4 FOOT CANDLES, UNIFORMITY RATIO 4:1
2. ** OR APPROVED EQUAL

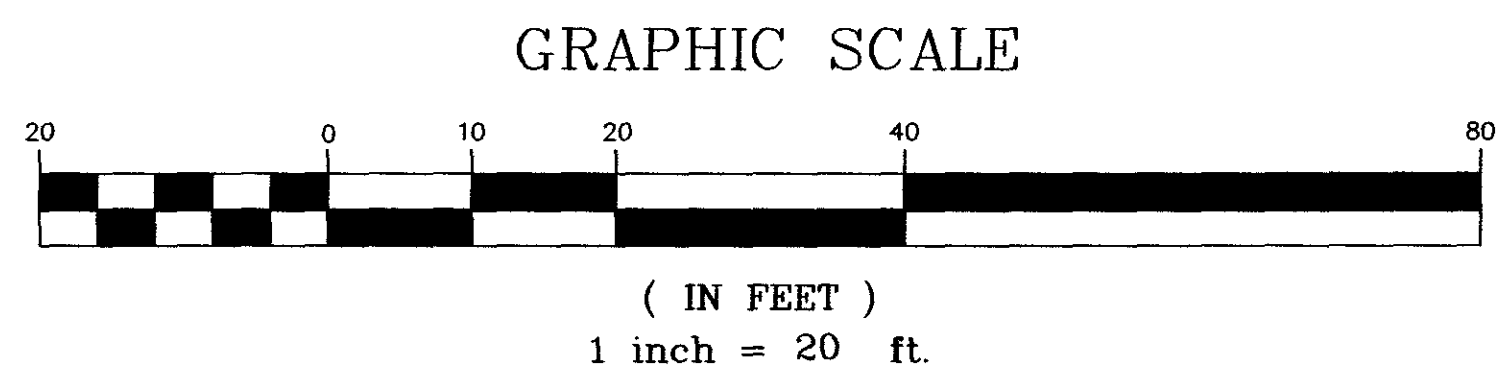

DATE

11-10-99

11-23-99

12-5-99

RECORD OF WORK

REVISED PER TOWN OF BETHELEM COMMENTS

REVISED PER COLUMBIA DEVELOPMENT CORPORATION COMMENTS

REVISED PER COLUMBIA DEVELOPMENT CORPORATION & TOWN OF BETHELEM COMMENTS

APPR.

R.M.D.

R.M.D.

R.M.D.

© Copyright 1999

Vollmer Associates LLP

Engineers, Landscape

Architects, Planners

All rights reserved.

Unauthorized duplication is

a violation of applicable laws.

DRAWN BY: R.D. DAVIS JR.

FIELD SURVEY:

CHK BY: R.M. DEMPFF

ENGINEERS • LANDSCAPE ARCHITECTS • PLANNERS

Pine West Plaza, Building 1A

Washington Ave. Extension, Albany, NY 12205-5510

Tel 518 • 452 • 4358 Fax 518 • 452 • 9234

Unauthorized alteration or

addition to this map is a

violation of section 7209,

sub-division 2 of the New

York State Education Law.

N.Y.S. LIC. NO. 067234

[Signature]

12/19/99

PROPOSED OFFICE BUILDING

347 DELAWARE AVENUE • TOWN OF BETHELEM

COUNTY OF ALBANY • NEW YORK

LANDSCAPING & LIGHTING PLAN

Sheet No.

S-4

Cadd

T:\98433\plan\p-4

ref:\98433\survey\base

ref:\98433\survey\ground

ref:\98433\survey\landscape

DATE: November, 1999

SCALE: 1" = 20'