


1 PROPOSED LIGHTING PLAN
SCALE: 1/4"=1'-0"


LEGEND

- SURFACE MOUNTED EXTERIOR WALLPACK
- RECESSED EXTERIOR REMOTE POWERED EMERGENCY EGRESS FIXTURE, WATERPROOF
- RECESSED DOWN LIGHT FIXTURE

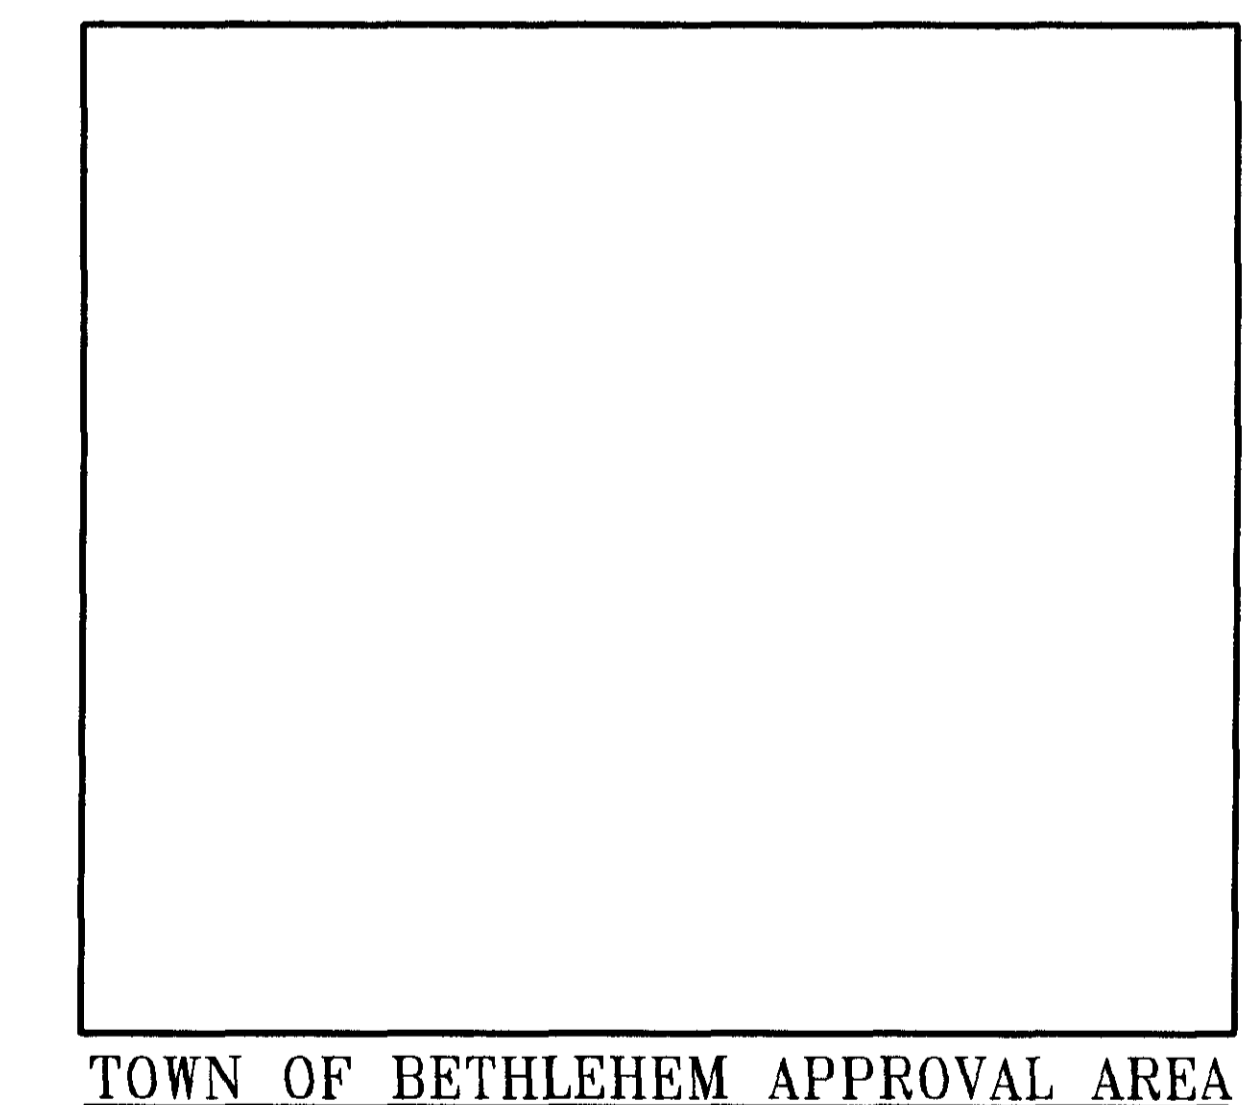

TOWN OF BETHLEHEM APPROVAL AREA

THIS PLAN HAS BEEN TAKEN FROM PLANS PROVIDED BY CUMBERLAND FARMS, INC. AND IS NOT INTENDED FOR CONSTRUCTION PURPOSES.

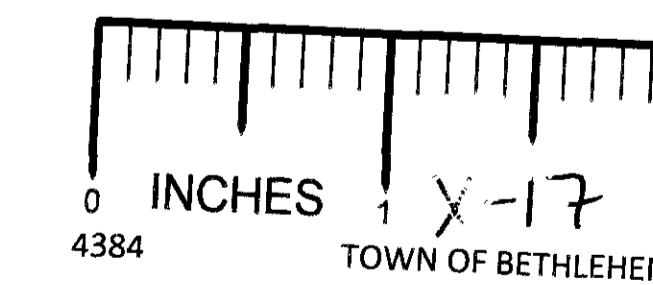

REV.	DATE	BY	COMMENT
10	10/29/07	REVISOR	REVISED PER TOWN COMMENTS
9	10/17/07	ECR	RESIDENTIAL LANDSCAPE BUFFER INCREASED
8	7/18/07	SG	REVISED PER TOWN COMMENTS
7	6/20/07	SG	BLDG. CANOPY REDUCED / SITE REDESIGNED
6	4/27/07	JRC	TRUCK DELIVERY / MAPLE AVE ACCESS
5	4/18/07	SG	REVISED PER DOT COMMENTS
4	2/28/07	ECR	REVISED PER TOWN COMMENTS
3	12/12/06	ECR	REVISED PER CLIENT COMMENTS
2	11/21/06	ECR	SITE LAYOUT REVISED - 90% SUBMITTAL
1	10/24/06	SG	BLDG. FOOTPRINT REVISED

BOHLER ENGINEERING, P.C.
CIVIL & CONSULTING ENGINEERS

5 Computer Drive West
Albany, NY 12205
518.438.9900
fax: 518.438.0900
www.bohlereng.com

PROJECT: CUMBERLAND FARMS, INC.
PROP. CONVENIENCE STORE & GAS STATION
LOTS 7, 9 & 12, BLOCK 1, SECTION 121.04
NEW YORK STATE HIGHWAY ROUTE 9W
TOWN OF BETHLEHEM, ALBANY COUNTY, NEW YORK

L.H. BOHLER
PROFESSIONAL ENGINEER
NEW YORK LICENSE No. 63409
NEW JERSEY LICENSE No. 27410
PENNSYLVANIA LICENSE No. 37184
CONNECTICUT LICENSE No. 17518
MASSACHUSETTS LICENSE No. 37025

W.D. GOEBEL
PROFESSIONAL ENGINEER
NEW YORK LICENSE No. 071284
CONNECTICUT LICENSE No. 21834
VERMONT LICENSE No. 7735
MASSACHUSETTS LICENSE No. 42644
RHODE ISLAND LICENSE No. 7268

TITLE: **EXTERIOR LIGHTING PLAN**

SCALE: (H) 1/4"=1'-0" (V) NONE DATE: 11/09/06 SHEET No: 4 OF 4

DRAWN BY: SMV PROJECT No: B050649 REV. No. 10

CHECKED BY: CEB CAD ID: # CONSTRUCTION CHECK DATE



THE STATE OF NEW YORK REQUIRES NOTIFICATION BY EXCAVATORS, DESIGNERS, OR ANY PERSON PREPARING TO DISTURB THE EARTH'S SURFACE ANYWHERE IN THE STATE.
(1-800-962-7962)

ANY PERSON IS PROHIBITED FROM ALTERING ANYTHING ON THESE DRAWINGS AND/OR THE ACCOMPANYING SPECIFICATIONS, UNLESS IT IS UNDER THE WRITTEN DIRECTION OF A LICENSED PROFESSIONAL ENGINEER OF THE FIRM. IN THE EVENT SUCH ALTERATIONS ARE MADE, THE PROFESSIONAL ENGINEER OF THE FIRM MUST SIGN, SEAL, DATE, AND DESCRIBE THE FULL EXTENT OF THE ALTERATION ON THE DRAWINGS AND/OR IN THE SPECIFICATIONS. (SEE EDUCATION LAW SECTION 2209-2)

07 Nov. 2007